


- BUILDING CHARACTERISTICS**
- Construction classification: 5-B
 - Renovation Area: 2,885 s.f.
 - Building Use Group: A-3 Assembly-Church/E DayCare
 - Floor Live Load: 40 psf
 - Building Code: NJLCC-Rehab Code
 - Existing 1st Floor Occupant Load: 495 Occupants
 - Proposed 1st Floor Occupant Load: 495 Occupants


INDEX OF DRAWINGS	CONTENTS
DRAWING A-1.0	COVER SHEET - EXISTING FLOOR PLANS, CODE NOTES, GENERAL NOTES
DRAWING A-2.0	OVERALL PROPOSED FLOOR PLANS, FINISH SCHEDULE & NOTES
DRAWING A-3.0	ENLARGED FLOOR PLANS, FINISH SCHEDULE, DETAILS & NOTES
DRAWING A-3.1	ENLARGED PARTIAL FOUNDATION PLAN, WALL SECTION & NOTES
DRAWING A-3.2	STAGE BUILDING SECTION & NOTES
DRAWING A-3.3	BATHROOM BUILDING SECTIONS & NOTES
DRAWING A-3.4	ENLARGED PARTIAL FOUNDATION PLAN, WALL SECTION & NOTES
DRAWING A-4.0	ENLARGED PARTIAL FOUNDATION PLAN, WALL SECTION & NOTES
DRAWING A-5.0	ENLARGED PARTIAL FOUNDATION PLAN, WALL SECTION & NOTES
DRAWING A-6.0	ENLARGED PARTIAL FOUNDATION PLAN, WALL SECTION & NOTES
DRAWING M-1.0	MECHANICAL PLANS & NOTES
DRAWING E-1.0	ELECTRICAL PLANS & NOTES
DRAWING P-1.0	PLUMBING PLAN, DETAILS & NOTES

GENERAL NOTES:

- THE DRAWINGS, SPECIFICATIONS, AND OTHER DOCUMENTS PREPARED BY THE ARCHITECT FOR THIS PROJECT ARE INSTRUMENTS OF THE ARCHITECT'S SERVICE FOR USE SOLELY WITH RESPECT TO THIS PROJECT AND, UNLESS OTHERWISE PROVIDED, THE ARCHITECT SHALL BE DEEMED THE AUTHOR OF THESE DOCUMENTS AND SHALL RETAIN ALL COMMON LAW, STATUTORY AND OTHER RESERVED RIGHTS, INCLUDING THE COPYRIGHT THEREOF.
- BUILDING PERMITS SHALL BE ISSUED ONLY IF THESE DOCUMENTS HAVE THE SIGNATURE AND SEAL OF THE ARCHITECT.
- ALL CONSTRUCTION INCLUDING PLUMBING, HEATING, AIR CONDITIONING AND ELECTRICAL WORK SHALL COMPLY WITH THE LOCAL CONSTRUCTION CODE AND ALL OTHER APPLICABLE CODES AND ORDINANCES INCLUDING UNDERWRITERS LAB APPROVAL, AND ALL STATE AND FEDERAL OSHA SAFETY REQUIREMENTS.
- WRITTEN DIMENSIONS SHALL HAVE PRECEDENCE OVER SCALED DIMENSIONS AND LARGER SCALE DETAILS SHALL HAVE PRECEDENCE OVER SMALLER SCALE DETAILS.
- THE CONTRACTOR SHALL BE RESPONSIBLE FOR VERIFYING ALL DIMENSION IN THE FIELD AND COORDINATING ALL JOB CONDITIONS.

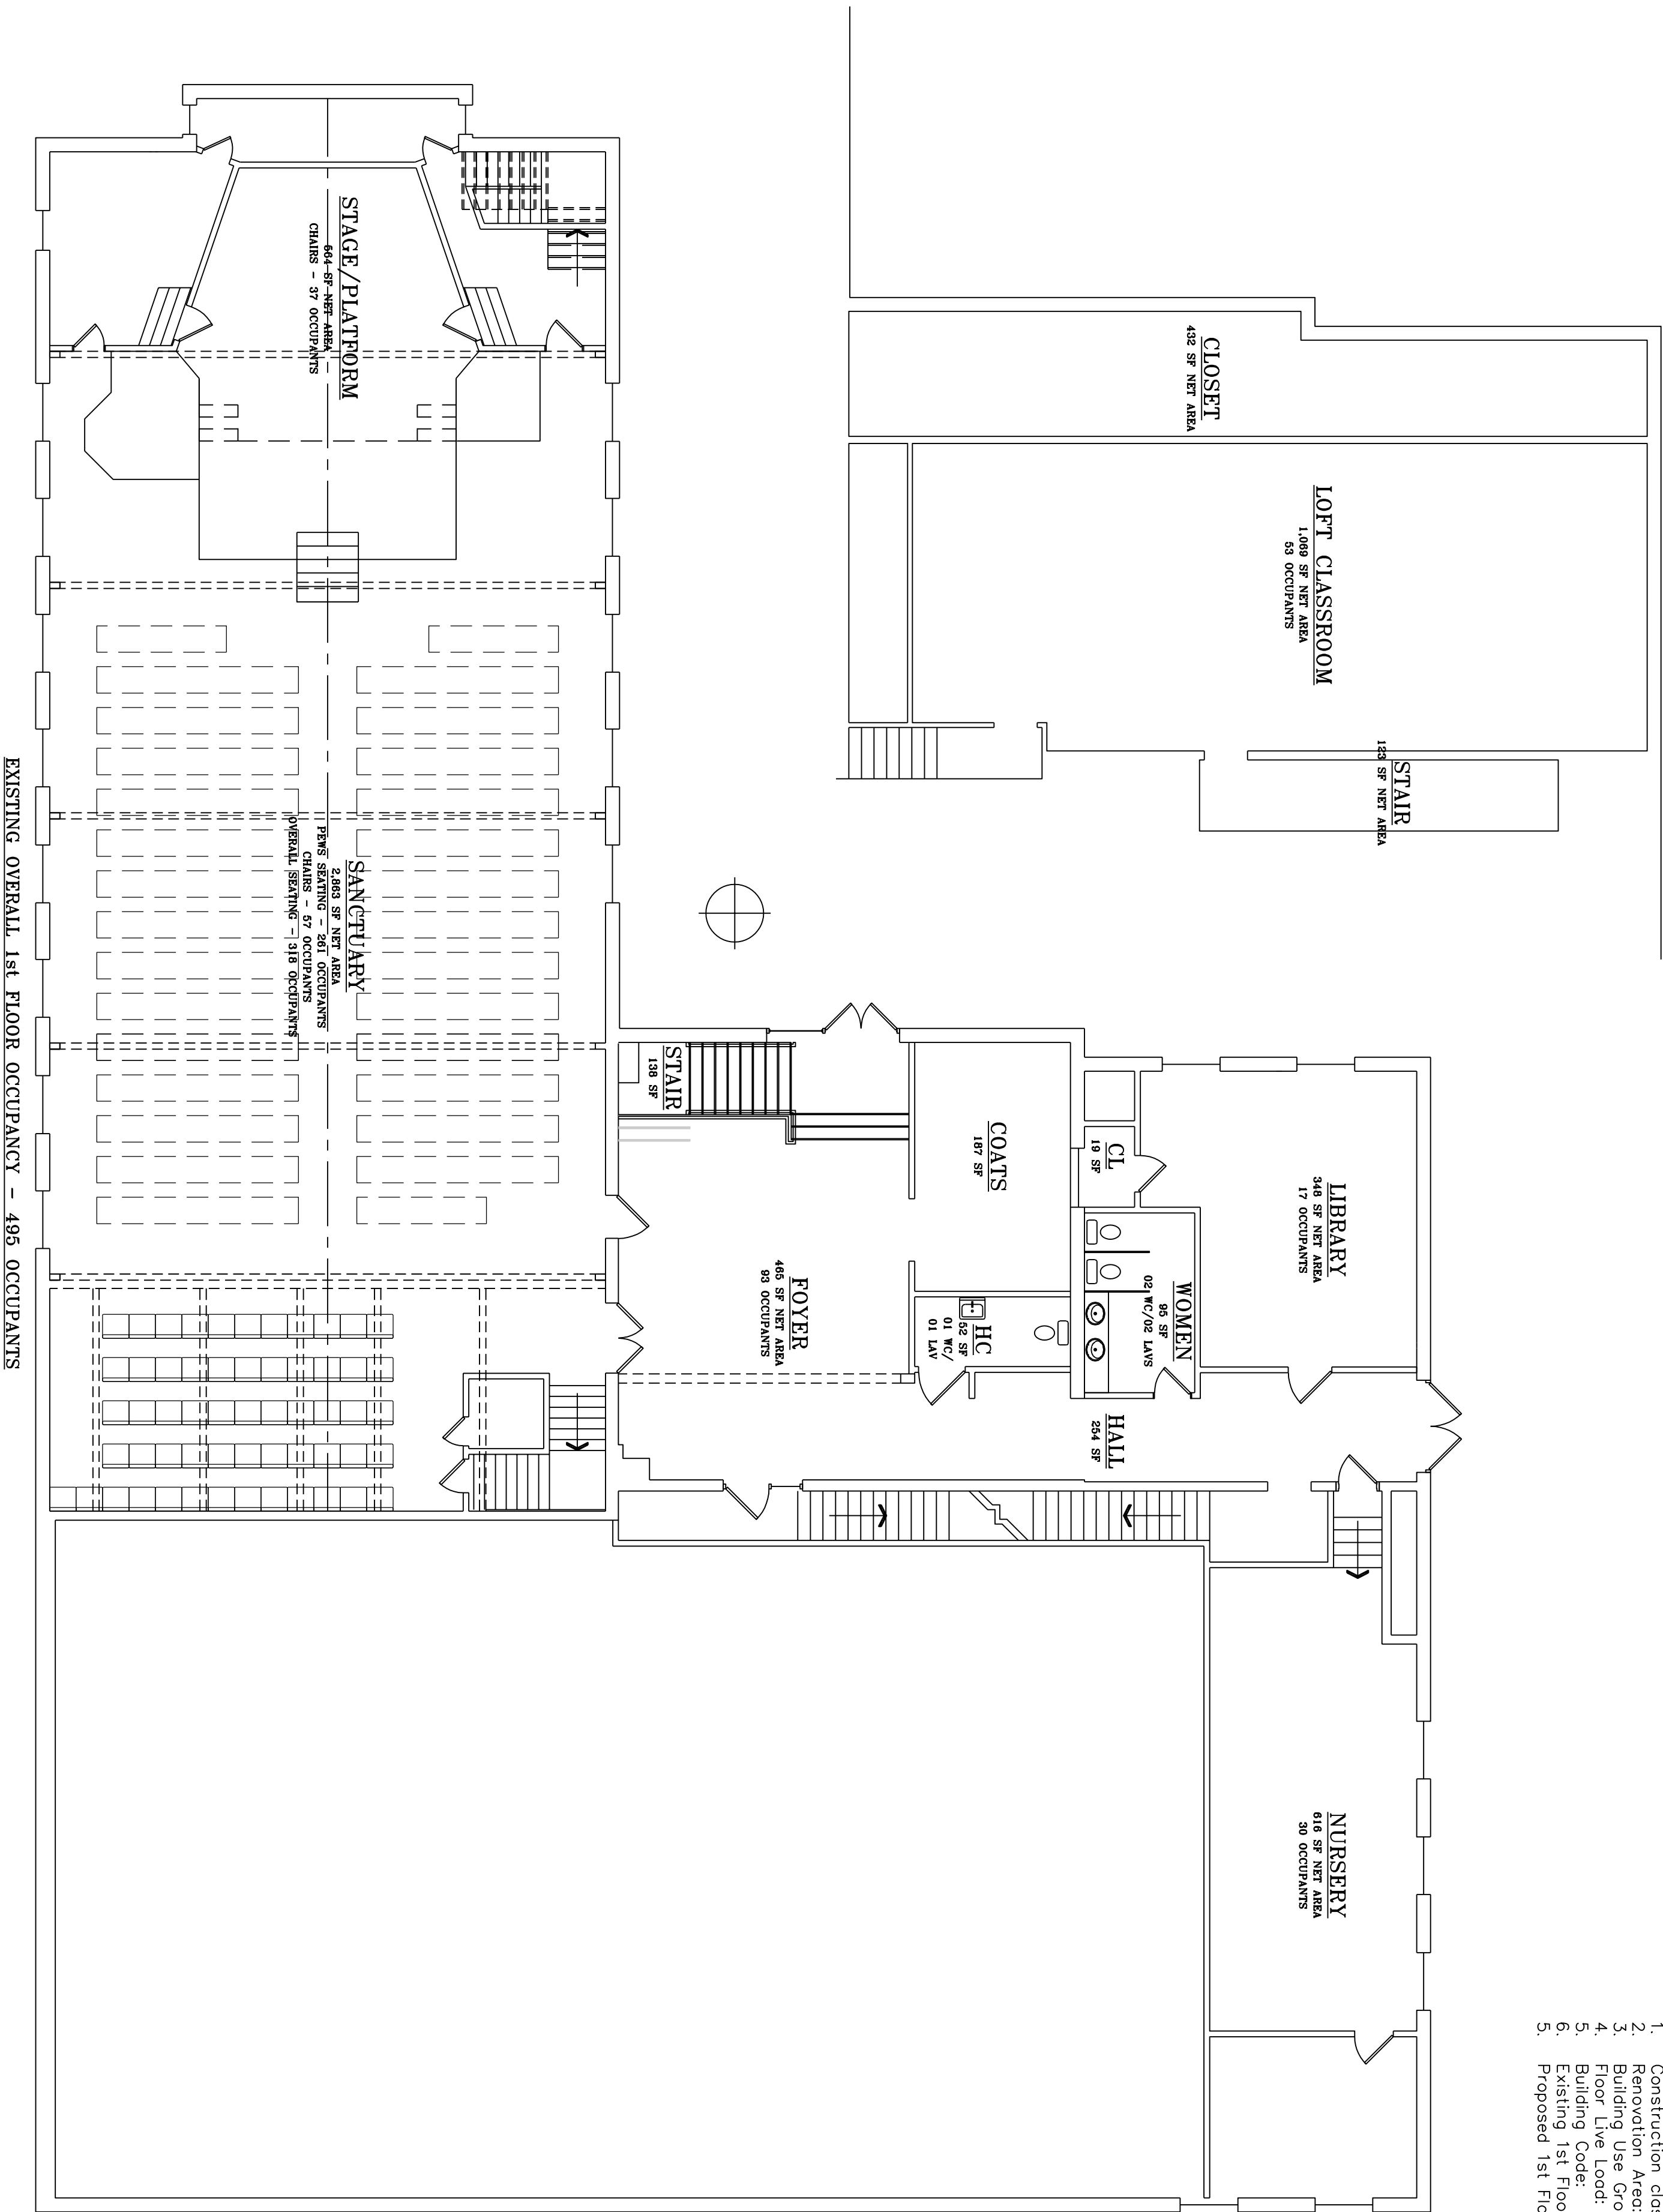

2 EXISTING FIRST FLOOR PLAN
1/8" = 1'-0"

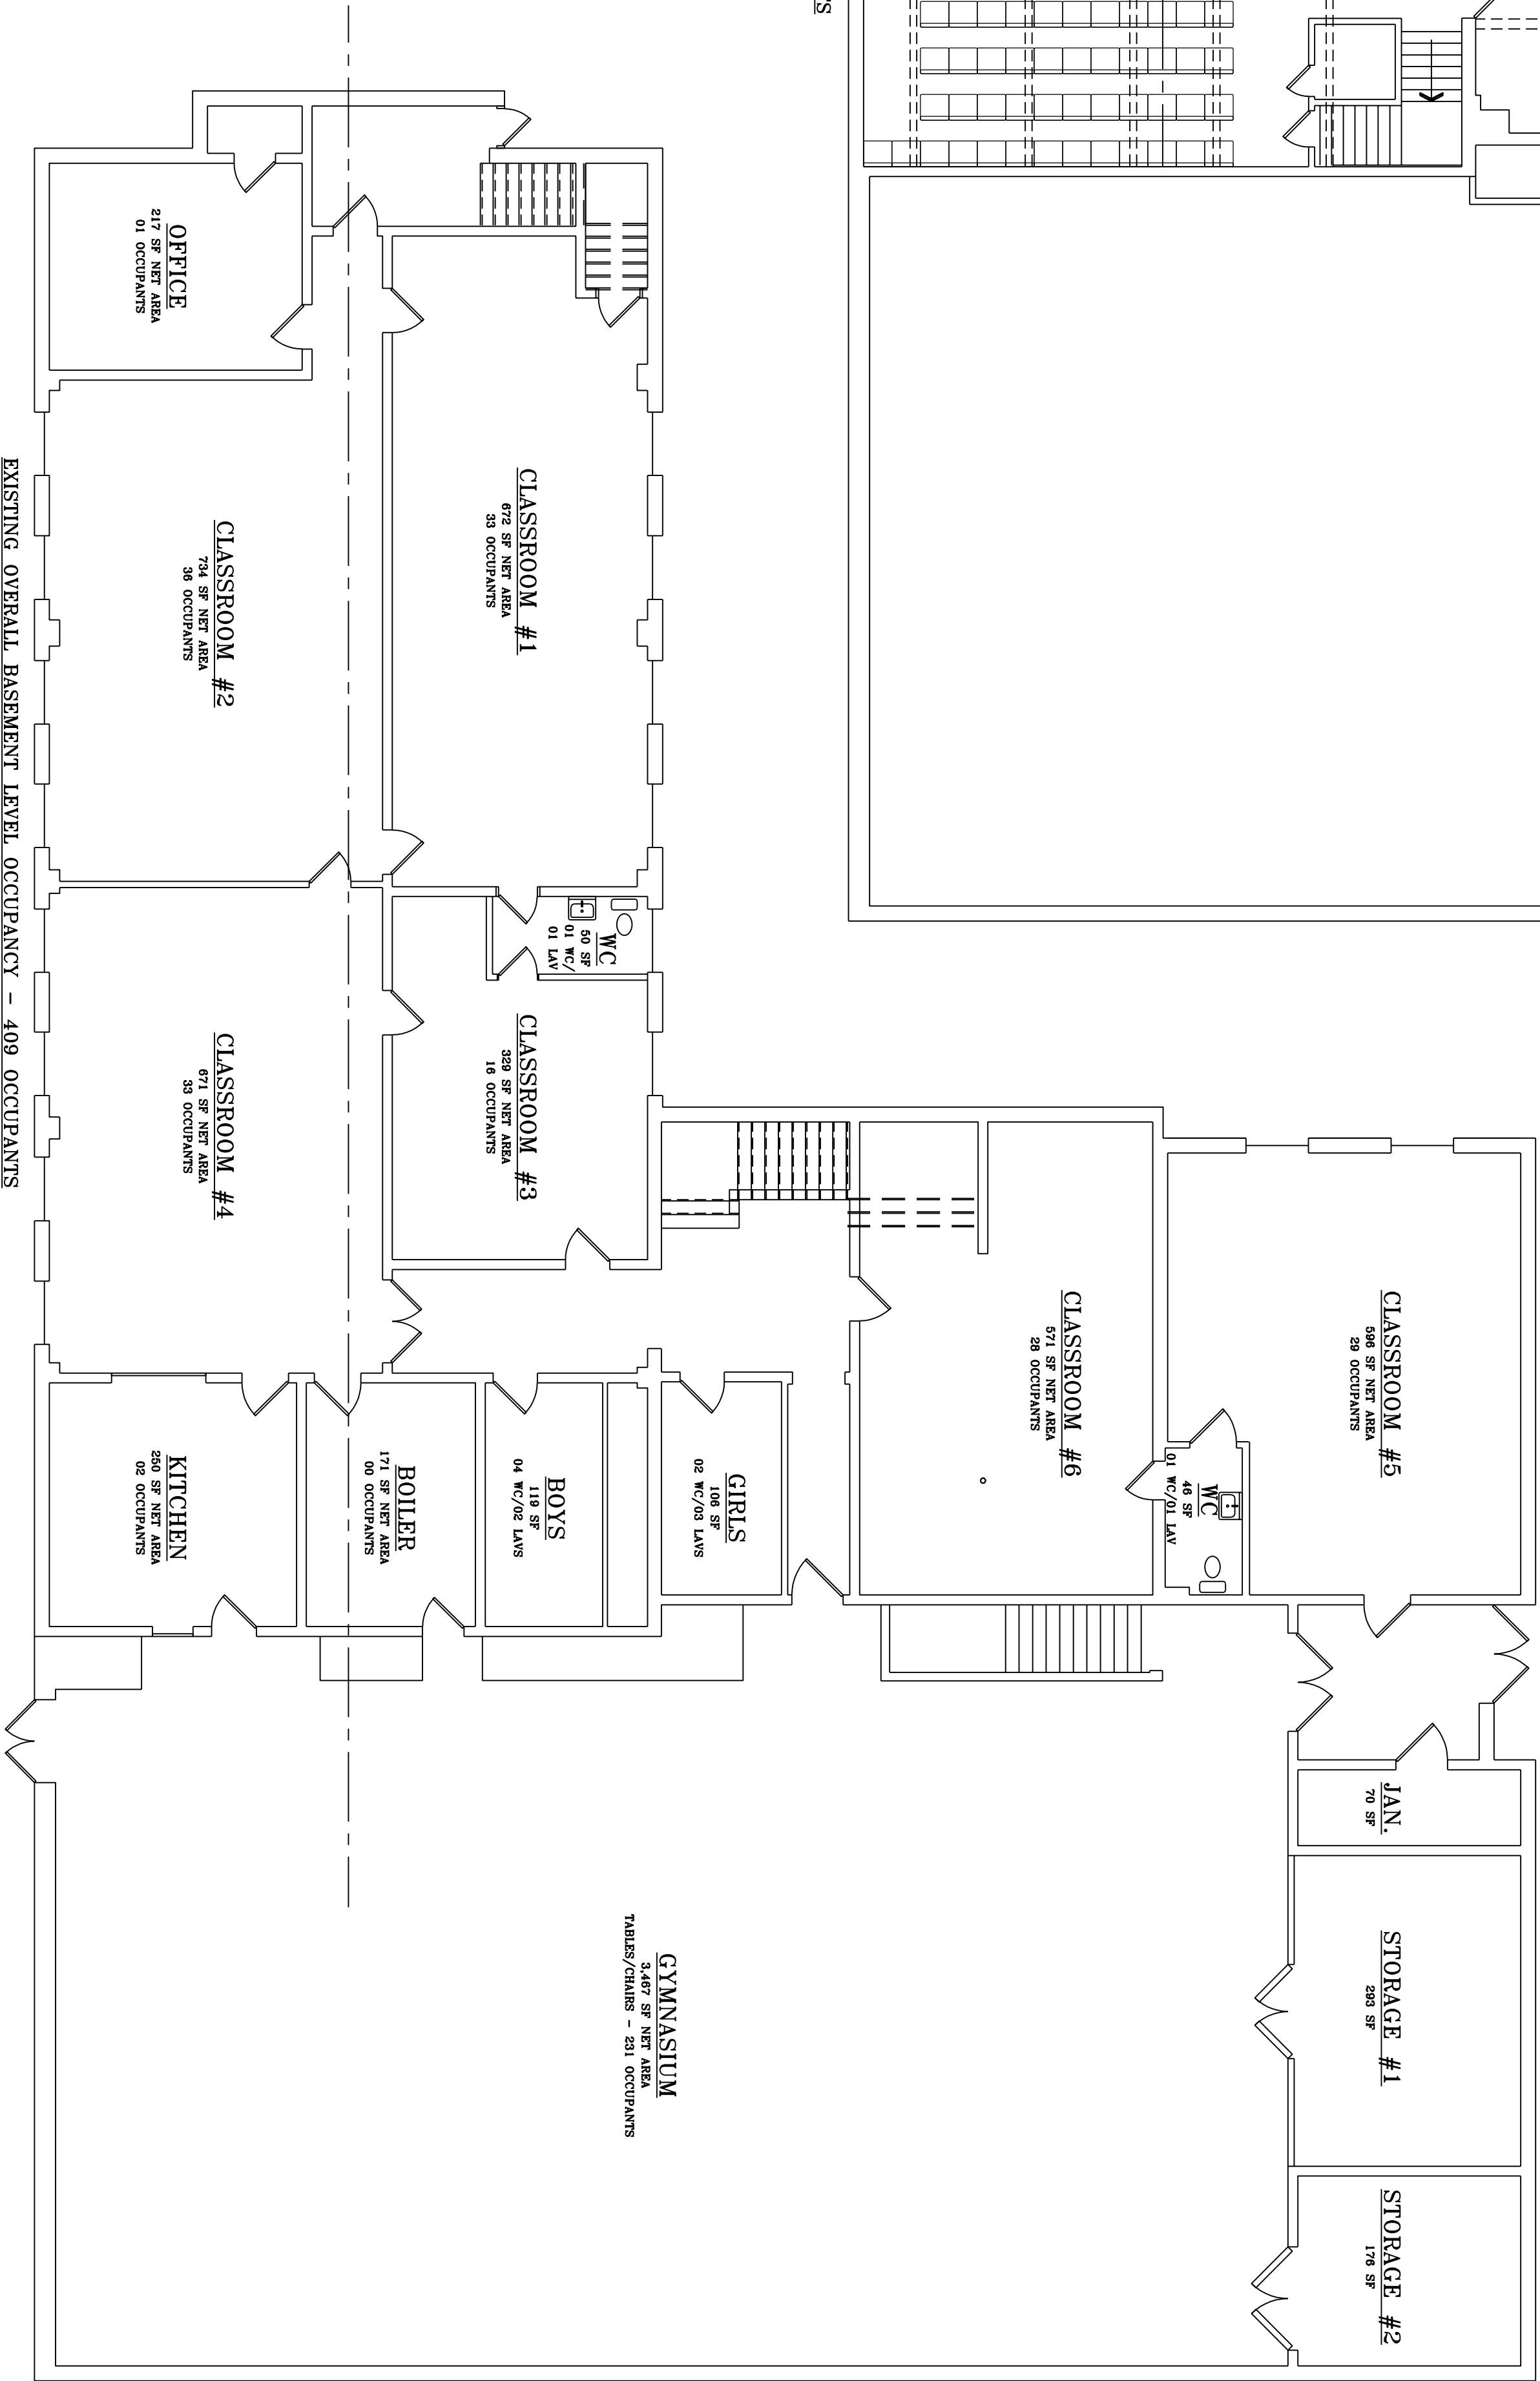


1 EXISTING BASEMENT FLOOR PLAN
1/8" = 1'-0"


PROPOSED FOYER RENOVATION & ACCESSIBILITY UPGRADES FOR CROSSBRIDGE COMMUNITY CHURCH 11 GRISCOM ROAD * WEST DEPTFORD, NJ 08096 B-356A L-1&1A			
EXISTING FLOOR PLANS & NOTES			
Drawn By:	RLH	Date:	05/23/2025
Checked By:	RLH	Revised:	07/18/2025
Scale:	1/8" = 1'-0"	Project No.:	23-37

FINISH SCHEDULE											
ROOM NO.	ROOM NAME	FLOOR	BASE	WALLS		EAST	SOUTH	WEST	CEILING		REMARKS
				NORTH					Mat.	Ht.	
FIRST FLOOR											
001	BASEMENT FOYER	EXISTING**	VB	PAINT-1	PAINT-1	PAINT-1	PAINT-1*	EXISTING	VERIFY		* CUT NEW DOOR
002	OFFICE	-	-	-	-	-	-	EXISTING	-		**SAW CUT FLOOR FOR HEAT PIPE
003	CLOSET	-	-	-	-	-	-	EXISTING	-		-
004	CLASSROOM 2	-	-	-	-	-	-	EXISTING	-		-
005	CLASSROOM 1	-	-	-	-	-	-	EXISTING	-		-
006	CLASSROOM 4	-	-	-	-	-	-	EXISTING	-		-
007	WATER CLOSET	-	-	-	-	-	-	EXISTING	-		-
008	CLASSROOM 3	-	-	-	-	-	-	EXISTING	-		-
009	KITCHEN	-	-	-	-	-	-	EXISTING	-		-
010	BOILER ROOM	-	-	-	-	-	-	EXISTING	-		-
011	BOY'S RESTROOM	-	-	-	-	-	-	EXISTING	-		-
012	HALL	-	-	-	-	-	-	EXISTING	-		-
013	GIRL'S RESTROOM	-	-	-	-	-	-	EXISTING	-		-
014	STAIR (up)	PAINT	-	-	-	-	-	EXISTING	-		-
015	HALL	-	-	-	-	-	-	EXISTING	-		-
016	CLASSROOM 6	-	-	-	-	-	-	EXISTING	-		-
017	WATER CLOSET	-	-	PAINT**	PAINT	PAINT	PAINT	EXISTING*	-		* PARTIALLY REMOVE & REINSTALL
018	CLASSROOM 5	-	-	-	-	-	-	EXISTING*	-		**DEMO FOR PLUMBING ACCESS
019	VESTIBULE	-	-	-	-	-	-	EXISTING	-		-
020	JANITOR	-	-	-	-	-	-	EXISTING	-		-
021	STORAGE 1	-	-	-	-	-	-	EXISTING	-		-
022	STORAGE 2	-	-	-	-	-	-	EXISTING	-		-
023	GYMNASIUM	-	-	-	-	-	-	EXISTING	-		-
101	BACK STAGE	CARPET-2	VB	PAINT-1	PAINT-1	PAINT-1	PAINT-1	EXISTING	EXISTING	-	-
102	SUB STAGE	CARPET-2	VB	PAINT-1	PAINT-1	PAINT-1	PAINT-1	EXISTING	EXISTING	-	-
103	STAIR	PAINT	VB	PAINT-1	PAINT-1	PAINT-1	PAINT-1	EXIST.WD.	SLOPED	-	-
104	STAGE/PLATFORM	CARPET-1*	VB	-	PAINT-1	PAINT-1	PAINT-1	EXIST.WD.	SLOPED		**WOOD EDGE STRIP
105	SANCTUARY	CARPET-3	VB	PAINT-1	PAINT-1	PAINT-WB*	PAINT-1	EXIST.WD.	SLOPED		**WOOD PLANK STAGE/ALT. PAINTED
106	FOYER	CARPET-4	VB	PAINT-2*	PAINT-2	-	PAINT-2	AC.BD.	8'-4"		**FEATURE GRAPHIC
107	STAIR	VINYL/LVT	VINYL	-	PAINT-2	PAINT-2	PAINT-2	AC.BD.	8'-4"		-
108	CASE	LVT(wood)	VB	-	PAINT-2	WD PLANK	PAINT-2	AC.BD.*	8'-4"		*PLAM BASE & UPPER CABINETS
109	CHAIR/TABLE STORAGE	PAINT*	VB	PAINT-2	PAINT-2	PAINT-2	PAINT-2	AC.BD.*	8'-4"		**EXISTING CONCRETE PATCH/PAINT
110	MEN'S RESTROOM	PORCELAIN	PORCELAIN	PAINT-3	PAINT-3	PAINT-3	PORCELAIN	AC.BD.*	8'-0"		-
111	HALL	CARPET-4	VB	PAINT-2*	-	PAINT-2	PAINT-2	AC.BD.	8'-4"		**FEATURE GRAPHIC
112	WOMEN'S RESTROOM	PORCELAIN	PORCELAIN	PAINT-3	PORCELAIN	PAINT-3	PAINT-3	AC.BD.	8'-0"		-
113	STAIR (up)	VINYL	VINYL	-	-	-	-	EXISTING	-		-
114	STAIR (dn)	VINYL	VINYL	-	-	-	-	EXISTING	-		-
115	NURSERY	VINYL/LVT	VB	PAINT-2	PAINT-2	PAINT-2	PAINT-2	EXISTING	-		-
116	CLOSET	VINYL/LVT	VB	PAINT-2	PAINT-2	PAINT-2	PAINT-2	AC.BD.	8'-0"		-
117	MOP SINK	PAINT	VB	PAINT-2	PAINT-2	PAINT-2	PAINT-2	AC.BD.*	8'-0"		-
118	STAIR (Sanctuary)	CARPET-2*	VB	PAINT-1	PAINT-1	PAINT-1	PAINT-1	-	-		*INCLUDING SOUND BOOTH
201	LOFT CLASSROOM	EXISTING	-	-	-	-	-	EXISTING	-		-
202	LOFT WORKROOM	EXISTING	-	-	-	-	-	EXISTING	-		-
203	CLOSET	EXISTING	-	-	-	-	-	EXISTING	-		-


DOOR SCHEDULE																	REMARKS
BASEMENT & FIRST FLOOR																	
DOORS																	
DOOR NO.	ROOM	TYPE	SIZE	W	HT	MAT.	FIN.	GLAZ.	LYE U.C.	FRAMES				DETAILS			REMARKS
										SIZE	HT	MAT.	FIN.	DTLS.	GLAZ.	HEAD	
01	BASE. FOYER/EXT.	2	3'-0"	7'-0"	FIBR	STPN	U	1	3'-4"	7'-4"	HM	PTD	2	**	**	**THERMAL BREAK FRAME **SEE DETAILS A-2.1	
02	SANCT/SIDE STAGE	2	3'-0"	6'-8"	WD	STN	2	*	WD	PTD	2	-	-	-	-	**PRE-HUNG DOOR/FRAME	
03	SANCTUARY/STAIR	2	3'-0"	6'-8"	WD	STN	2	*	WD	PTD	2	-	-	-	-	**PRE-HUNG DOOR/FRAME	
04	FOYER/CHAIR STOL	2	3'-0"	6'-8"	WD	STN	2	*	WD	PTD	2	-	-	-	-	**PRE-HUNG DOOR/FRAME	
05	MEN'S ROOM/HALL	2	3'-0"	6'-8"	WD	STN	2	*	WD	PTD	4	-	-	-	-	**PRE-HUNG DOOR/FRAME	
06	HALL/WOMEN'S RM.	2	3'-0"	6'-8"	WD	STN	2	*	WD	PTD	4	-	-	-	-	**PRE-HUNG DOOR/FRAME	
07	MOP RM./HALL	2	3'-0"	6'-8"	WD	STPN	2	*	WD	PTD	2	-	-	-	-	**PRE-HUNG DOOR/FRAME	

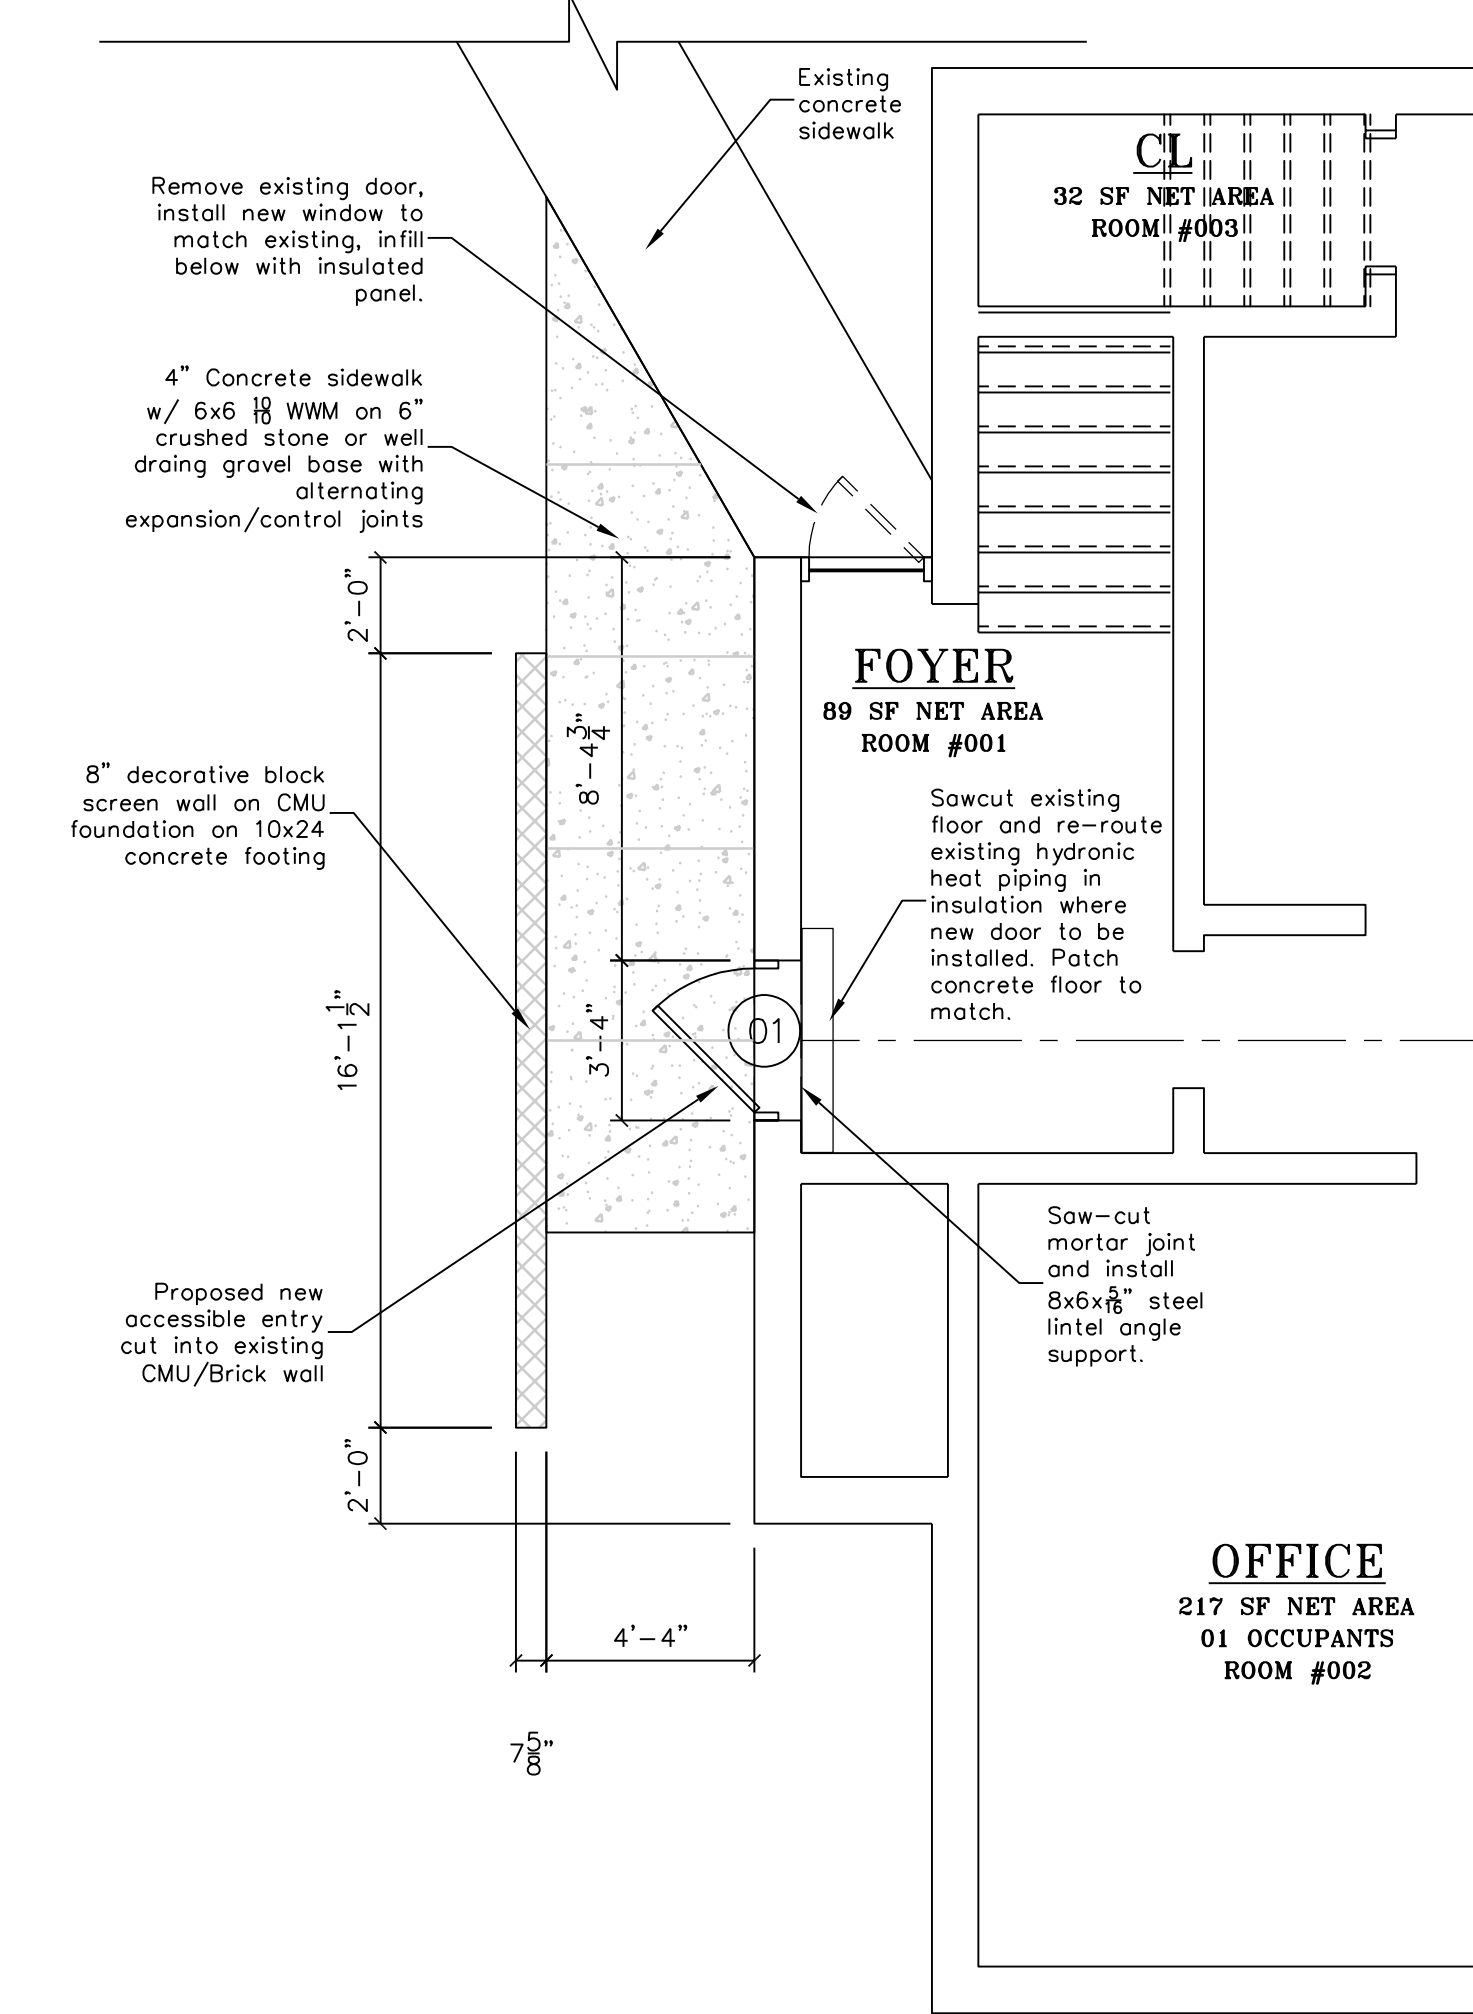

PROPOSED ENLARGED BASEMENT PLAN-EXIT

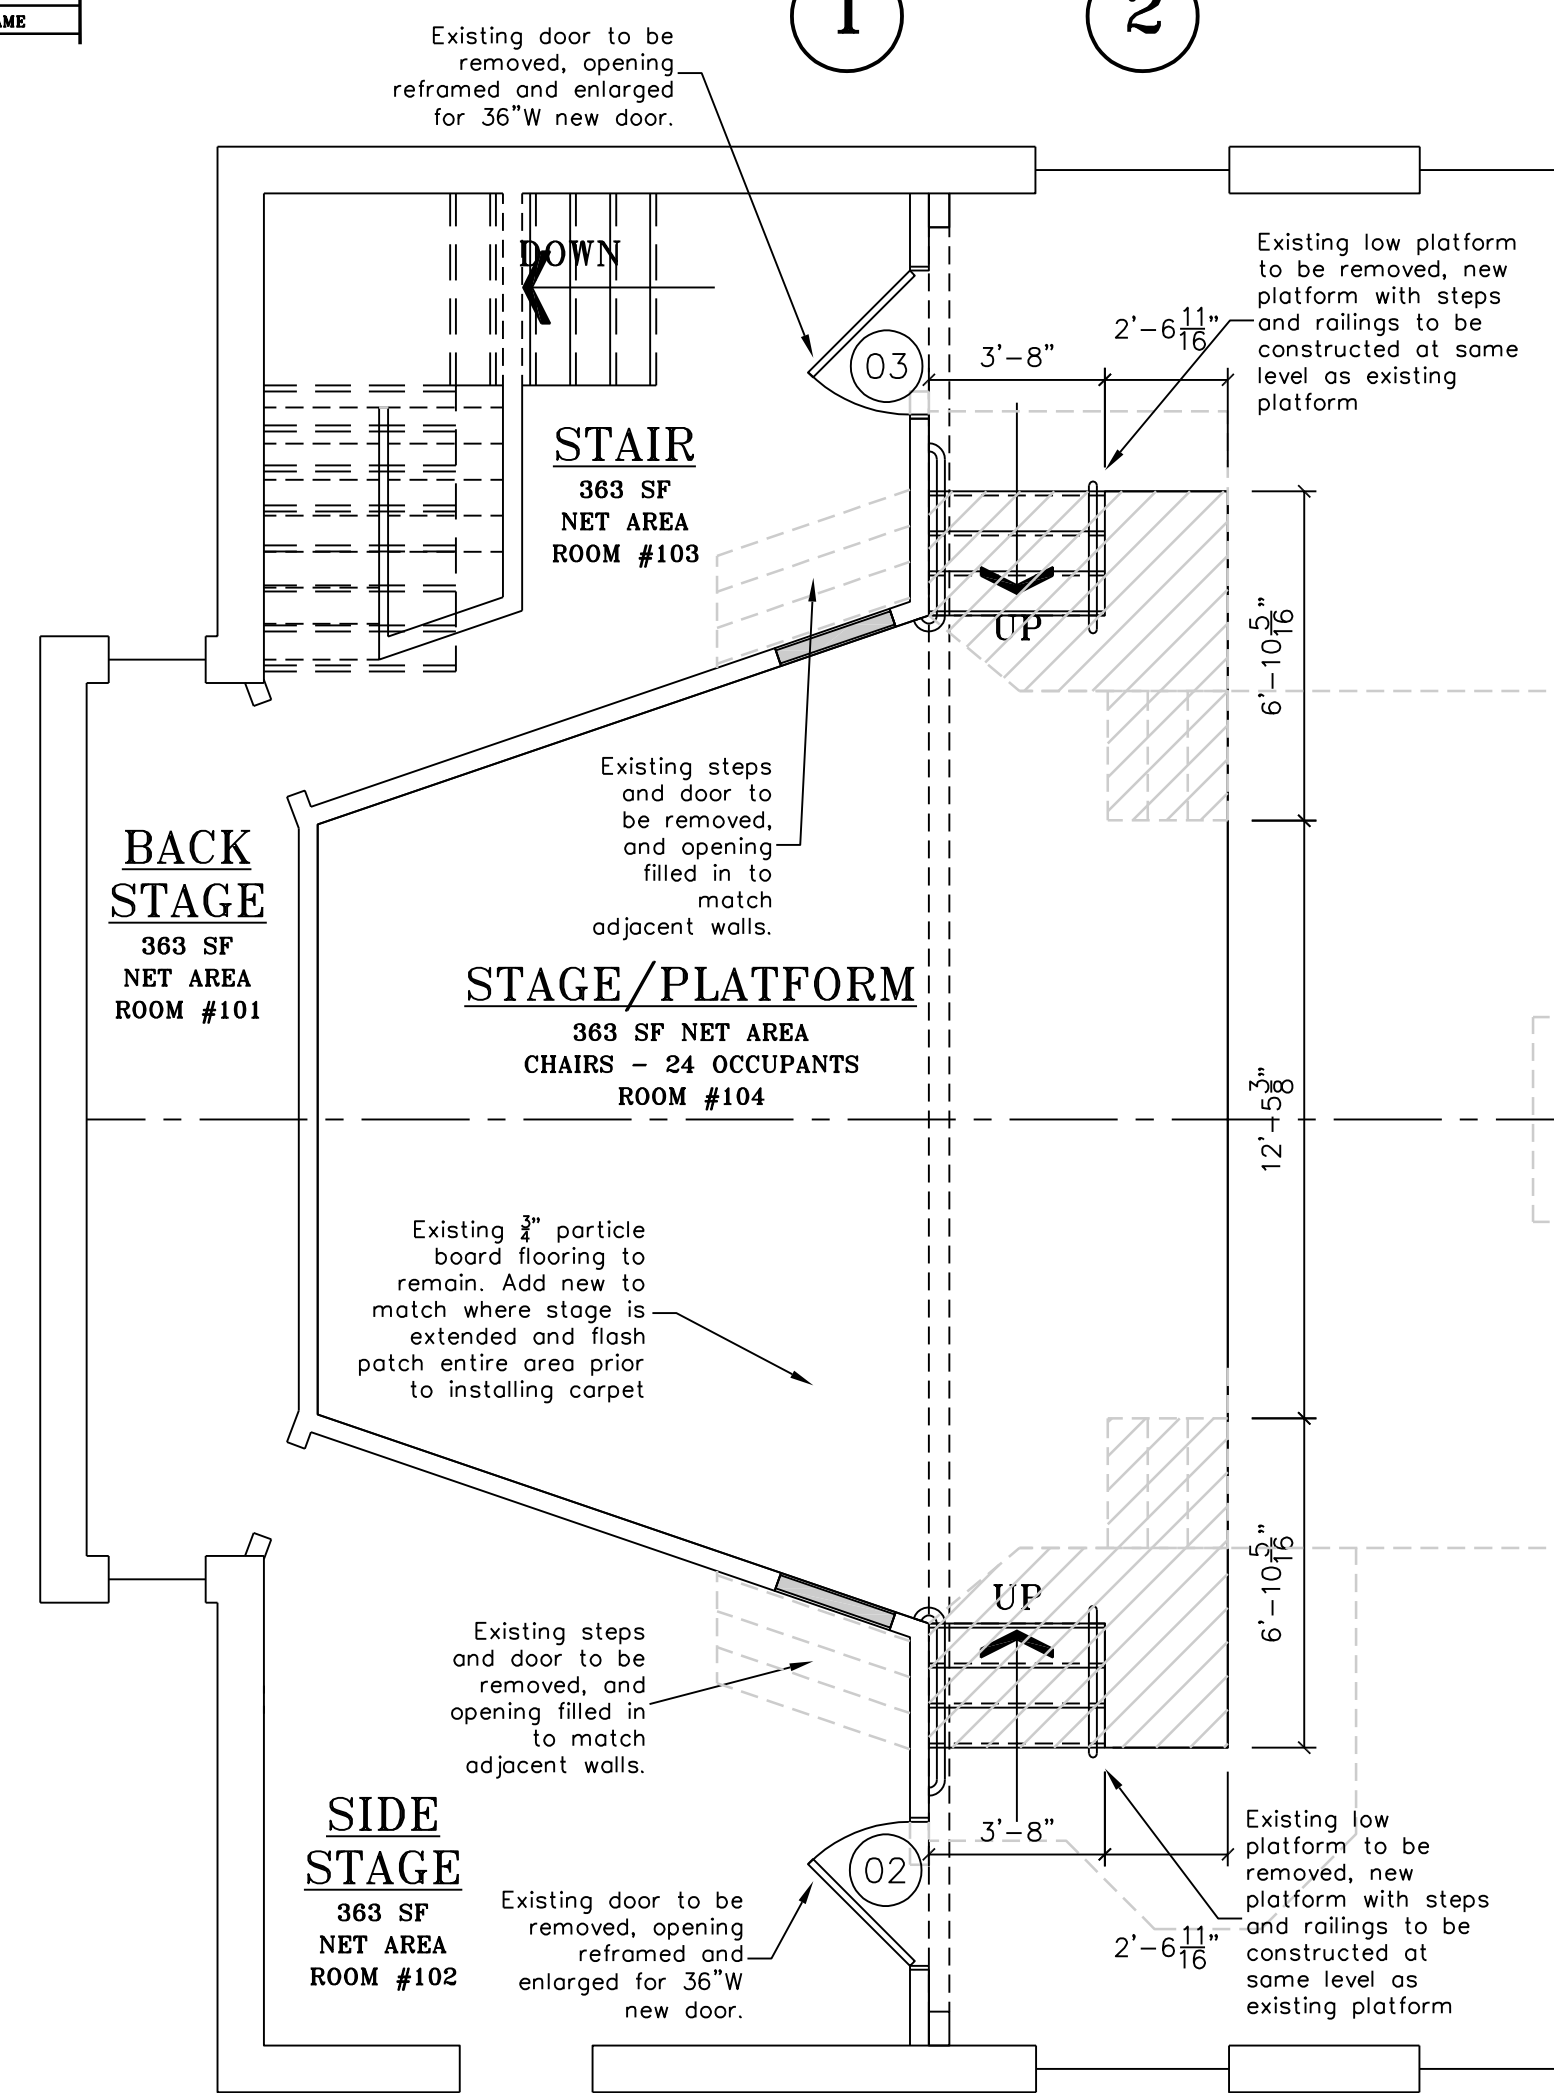

PROPOSED ENLARGED FLOOR PLAN-STAGE

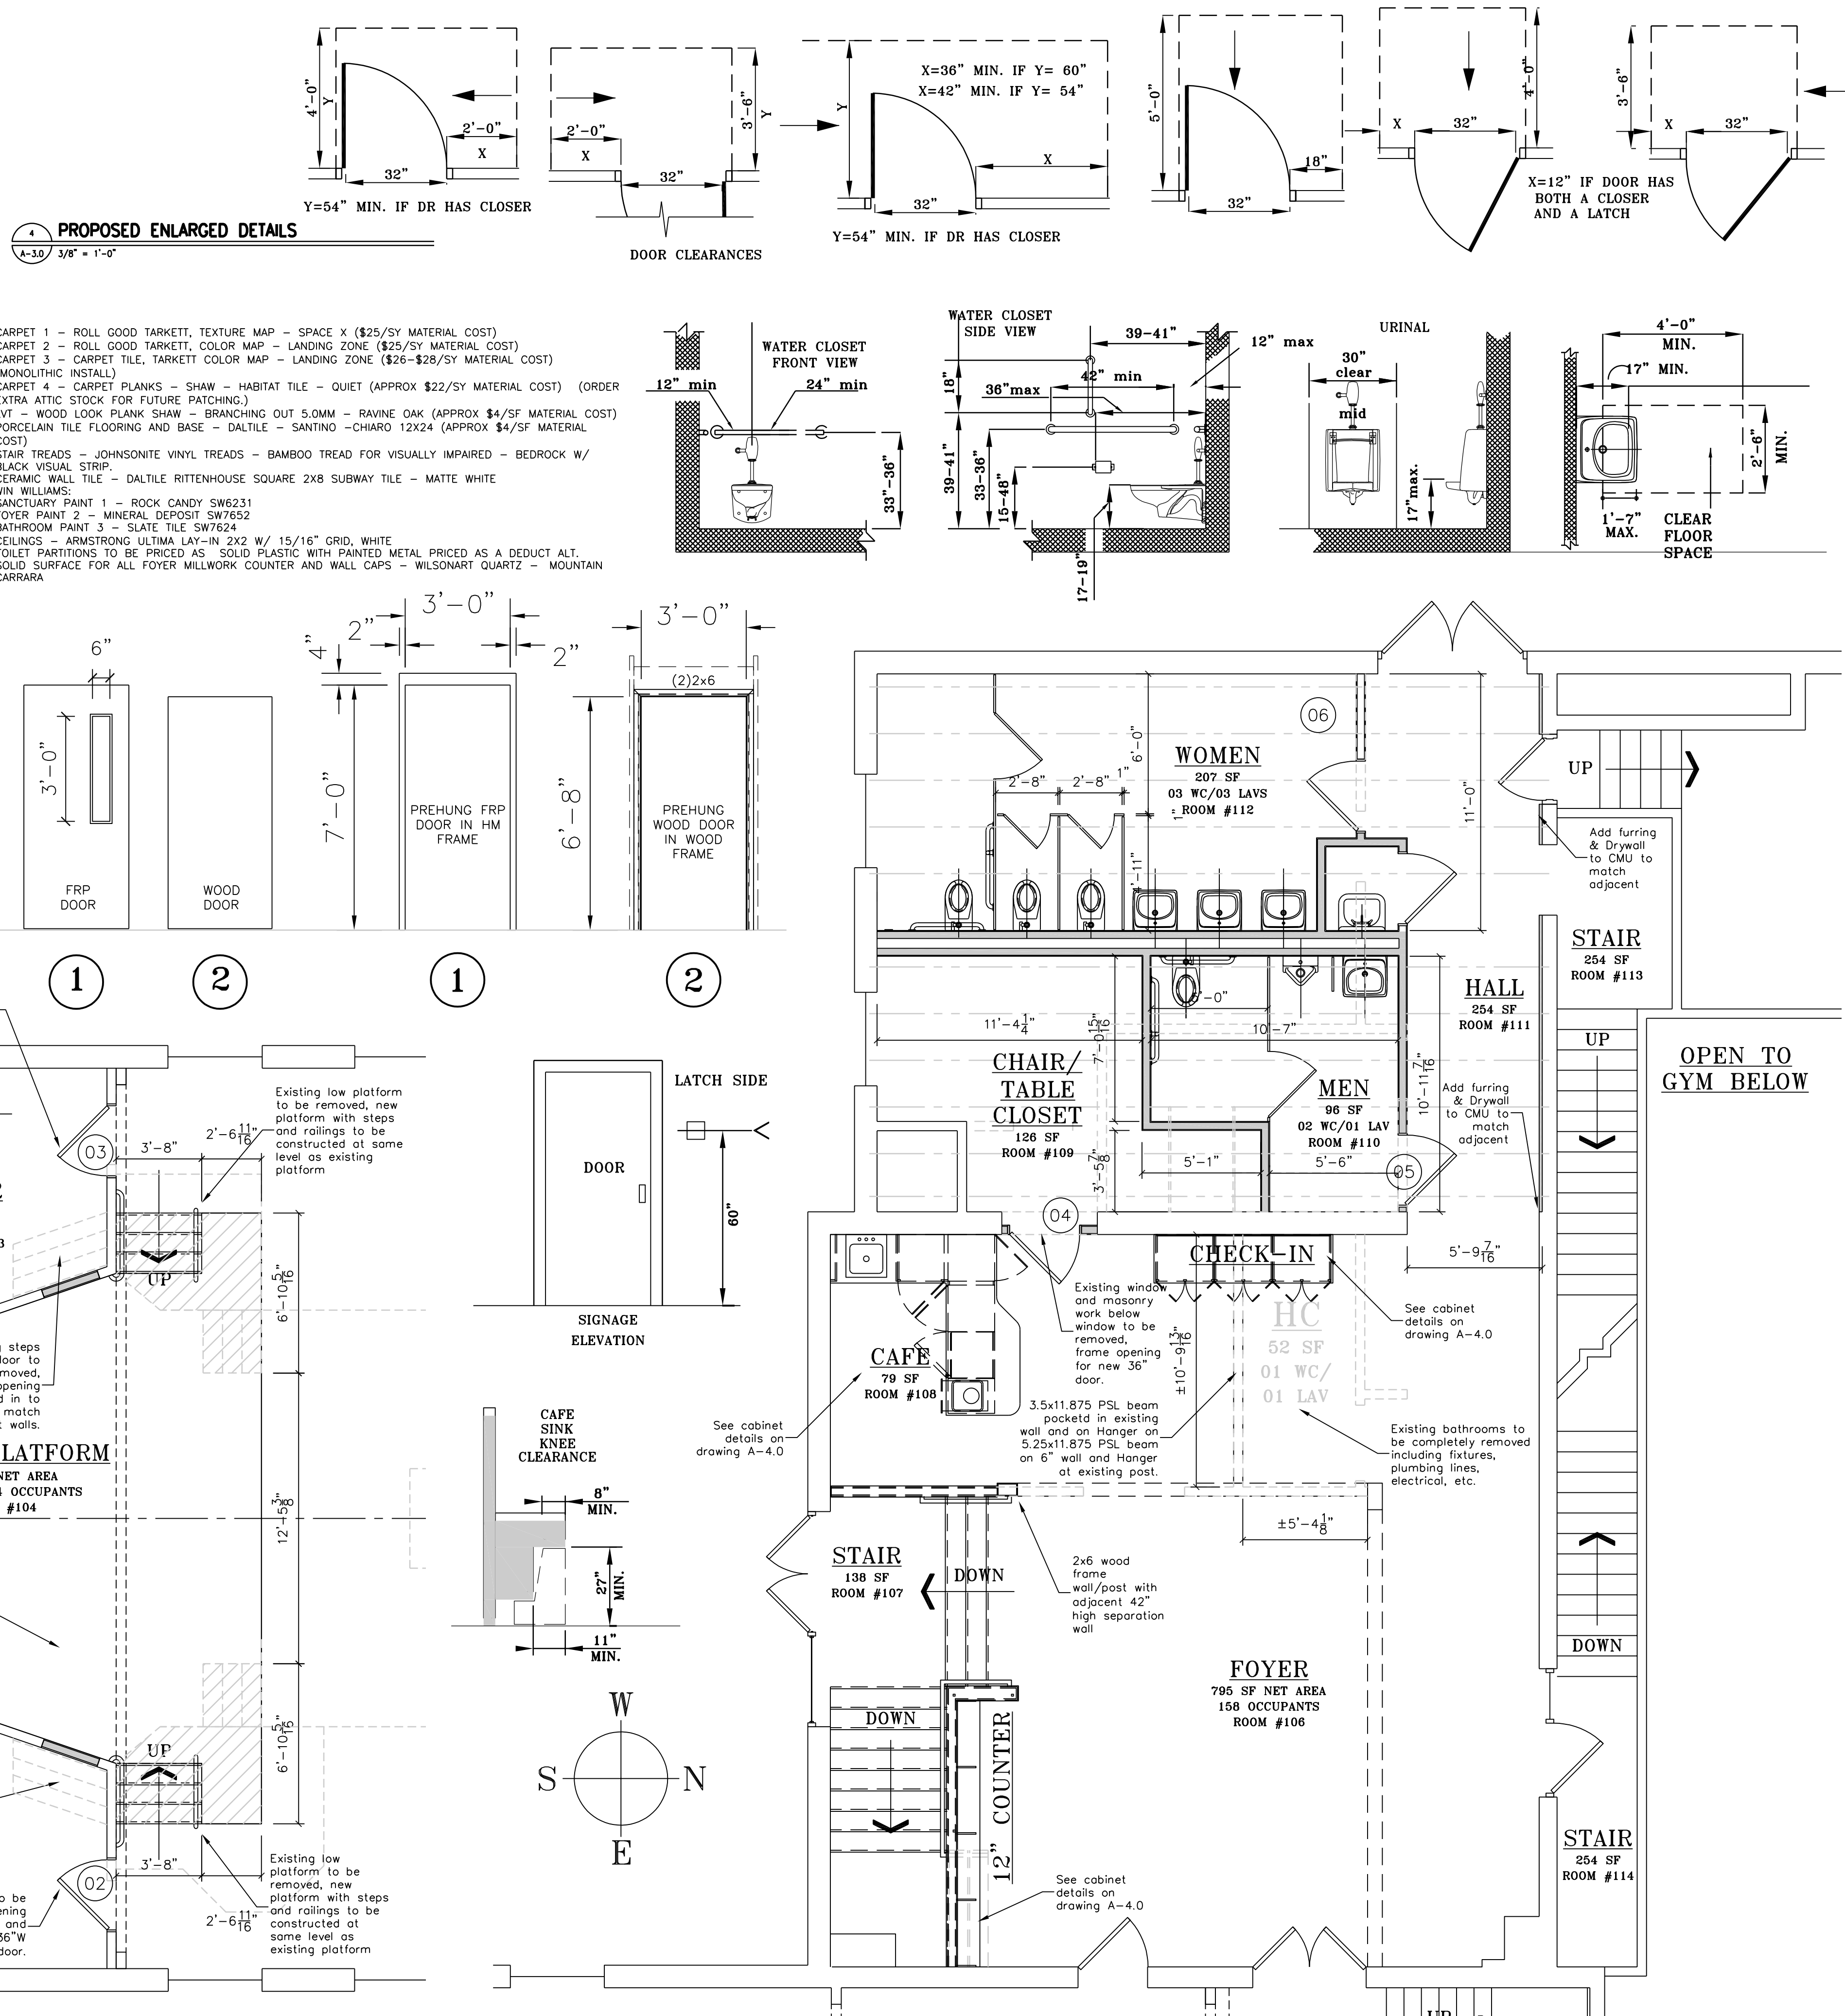

PROPOSED ENLARGED FLOOR PLAN-FOYER

RLH NJ REG. 10848

RANDALL HOLBERG LLC
A R C H I T E C T


178 SOUTH LAKESIDE DRIVE EAST • MEDFORD, NEW JERSEY 08055
TELE: (609) 923-3423 Email: RLHrktect@gmail.com

COPYRIGHT © 2025
RANDALL HOLBERG LLC
ARCHITECT
ALL RIGHTS RESERVED.


PROPOSED FOYER RENOVATION & ACCESSIBILITY UPGRADES FOR CROSSBRIDGE COMMUNITY CHURCH 11 GRISCOM ROAD * WEST DEPTFORD, NJ 08096 B-356A L-141A BASEMENT & FIRST FLOOR PLAN & NOTES					
Drawn By:	RLH	Date:	05/23/2025	Scale:	AS NOTED
Checked By:	RLH	Revised:	05/27/2025	Project No.:	21-01

Drawing No.

A-3.0

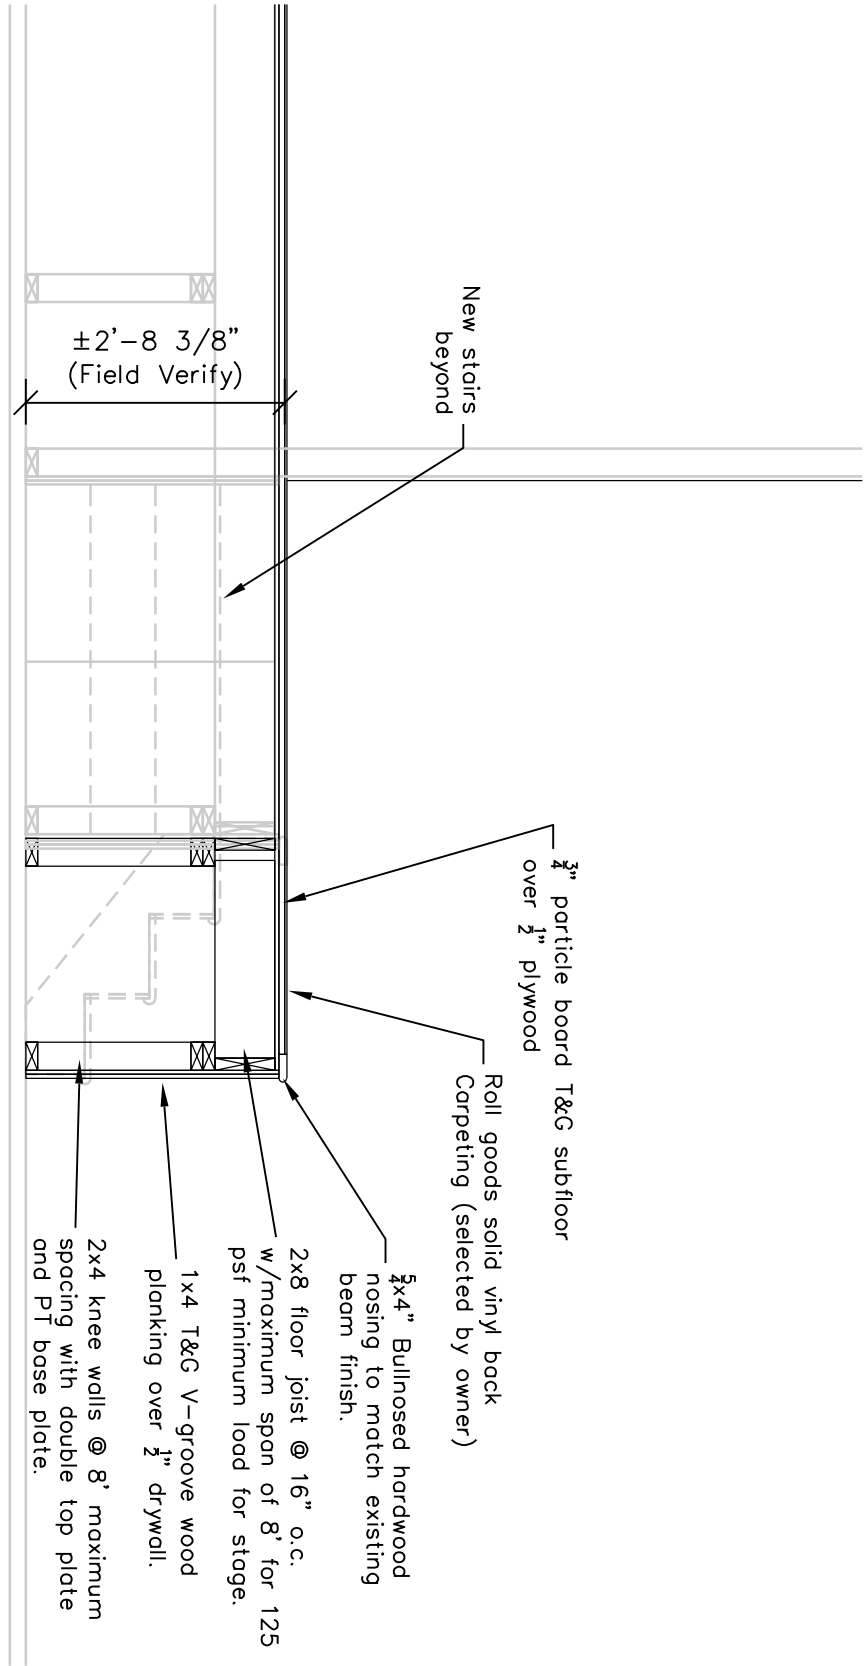

2 STAGE EXTENSION SECTION
A-3.2 / 1/2" = 1'-0"

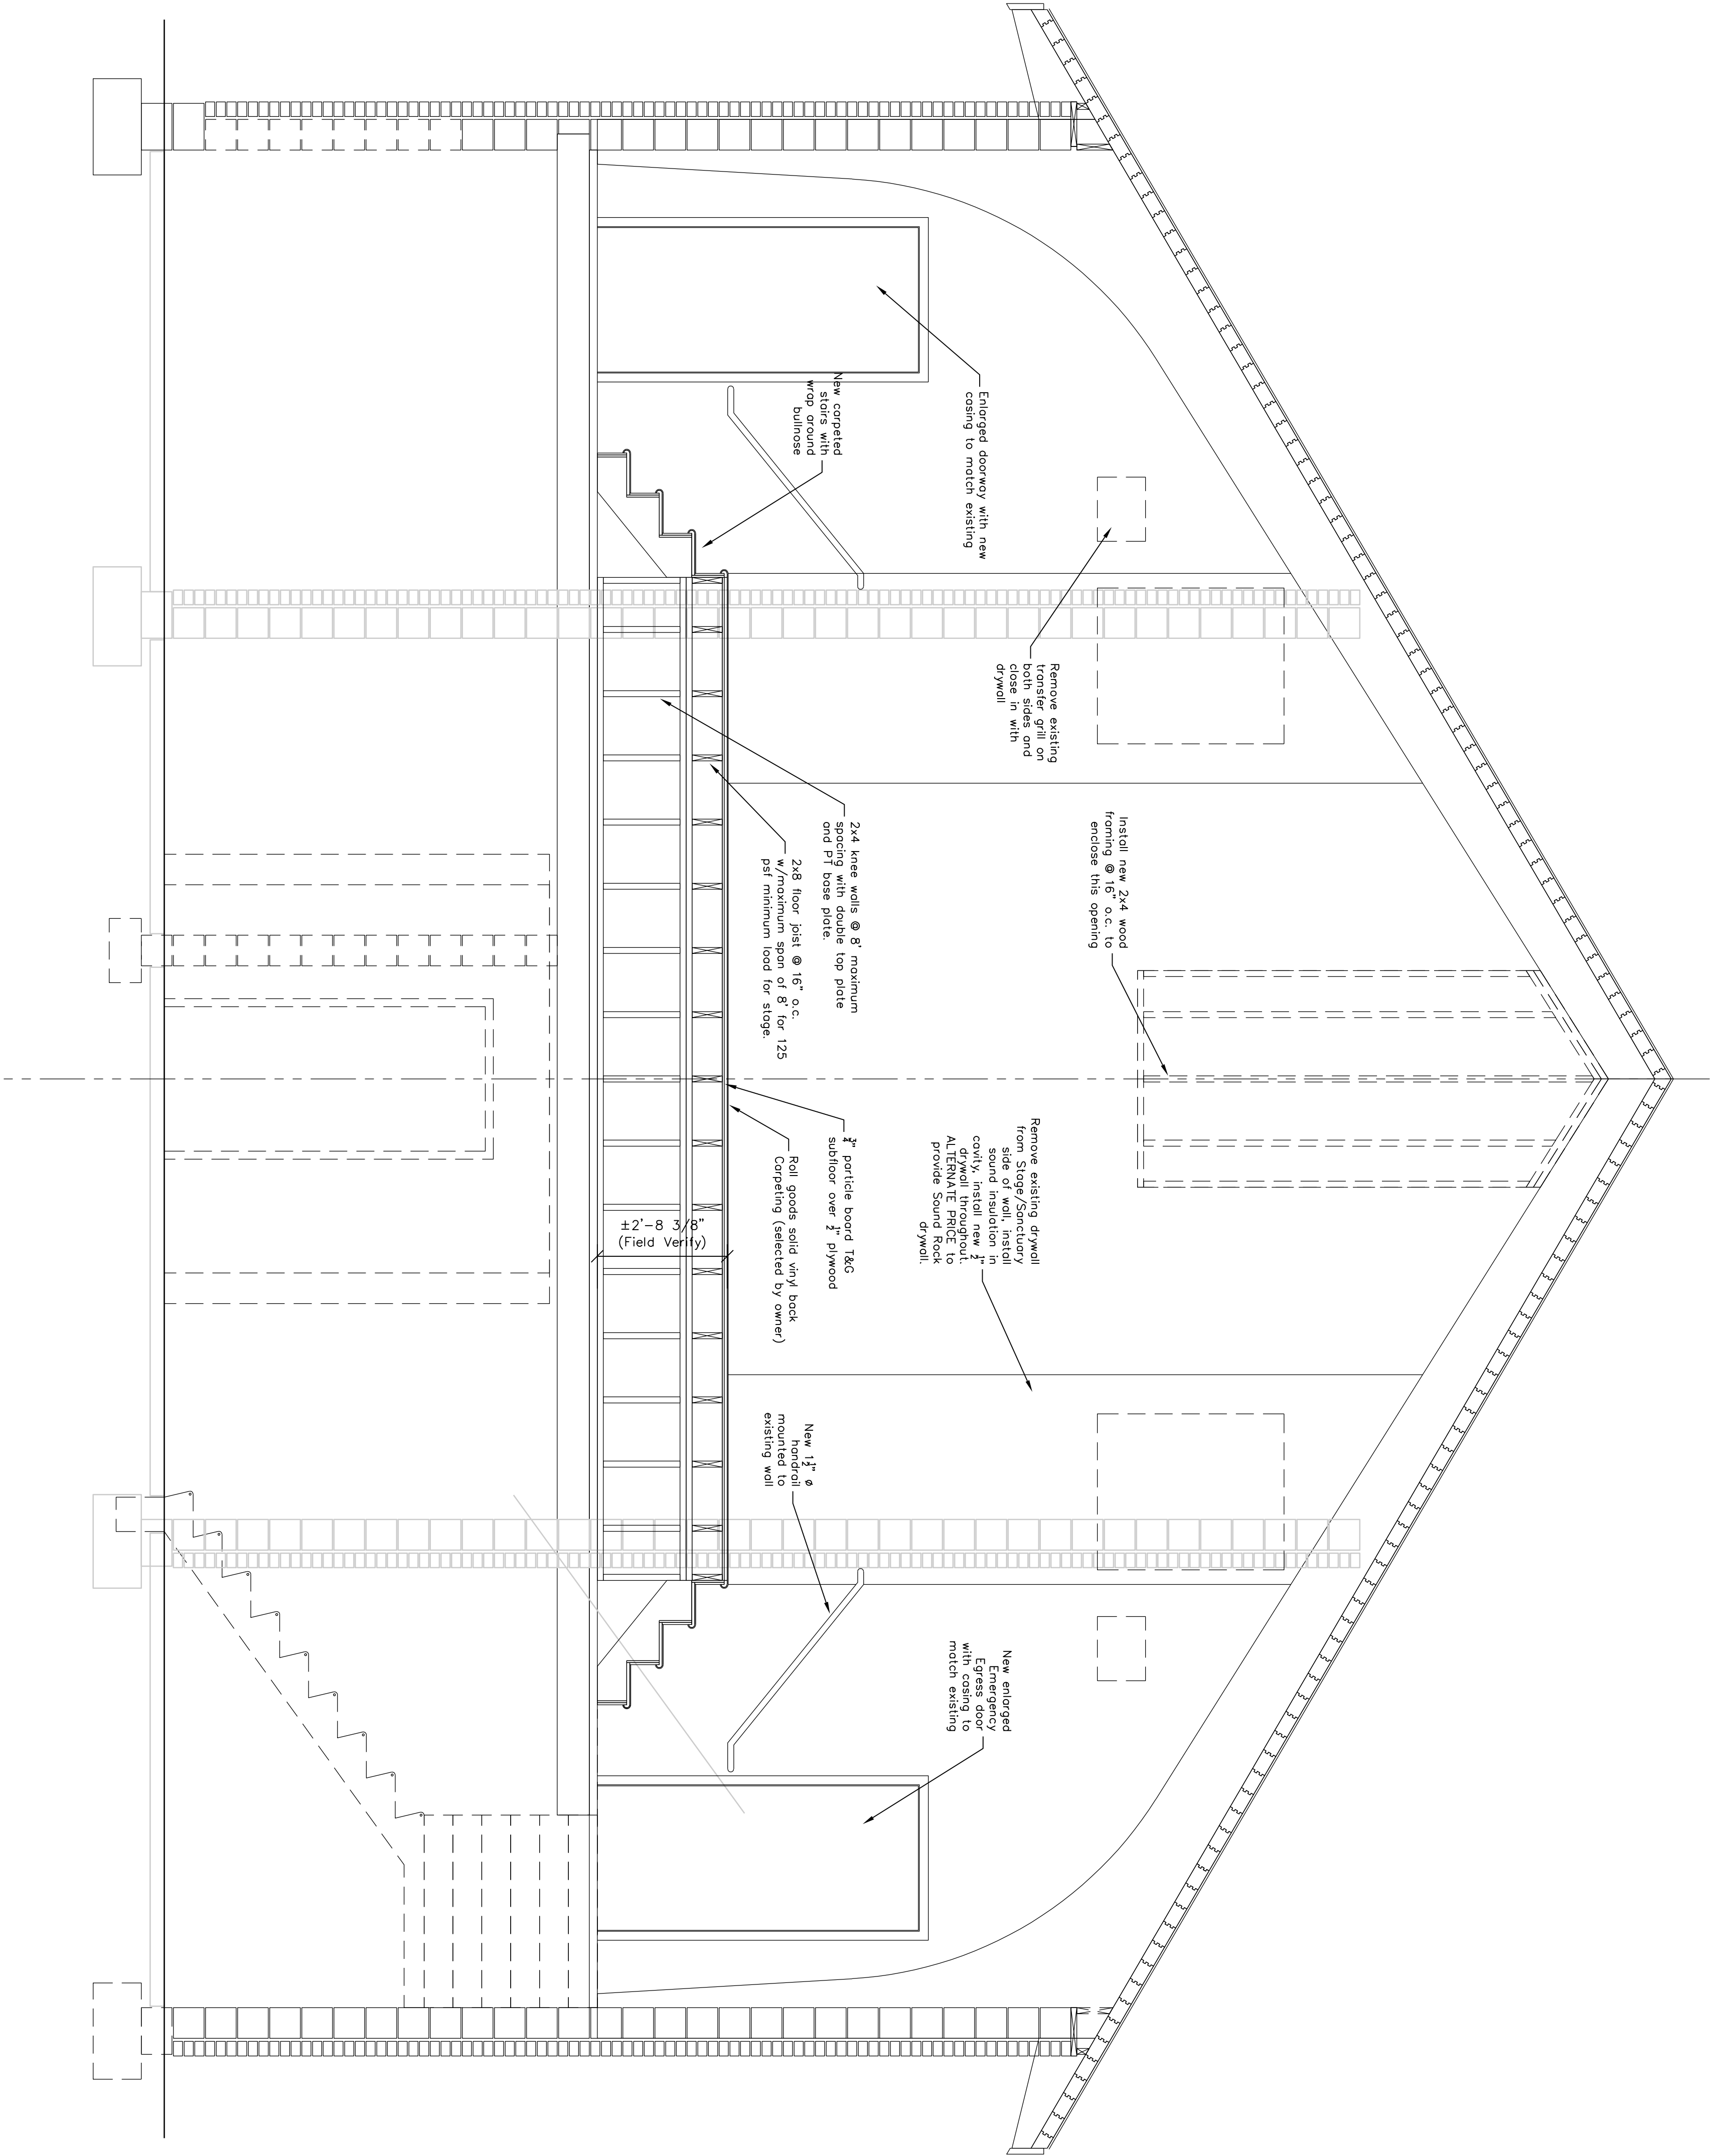

1 SANCTUARY STAGE CROSS SECTION
A-3.2 / 1/2" = 1'-0"

Drawing No.

A-3.2


PROPOSED FOYER RENOVATION & ACCESSIBILITY UPGRADES FOR CROSSBRIDGE COMMUNITY CHURCH 11 GRISCOM ROAD * WEST DEPTFORD, NJ 08096 B-356A L-1&1A			
SANCTUARY SECTIONS & NOTES			
Drawn By:	RLH	Date:	05/23/2025
Checked By:	RLH	Revised:	05/27/2025
Scale:	AS NOTED		
Project No.:	21-01		

COPYRIGHT © 2025
RANDALL HOLBERG LLC
ARCHITECT
ALL RIGHTS RESERVED.


RANDALL HOLBERG LLC
ARCHITECT

178 SOUTH LAKESIDE DRIVE EAST * MEDFORD, NEW JERSEY 08055
TELE: (609) 923-3423 Email: RLHrktect@gmail.com

RLH NJ REG. 10848

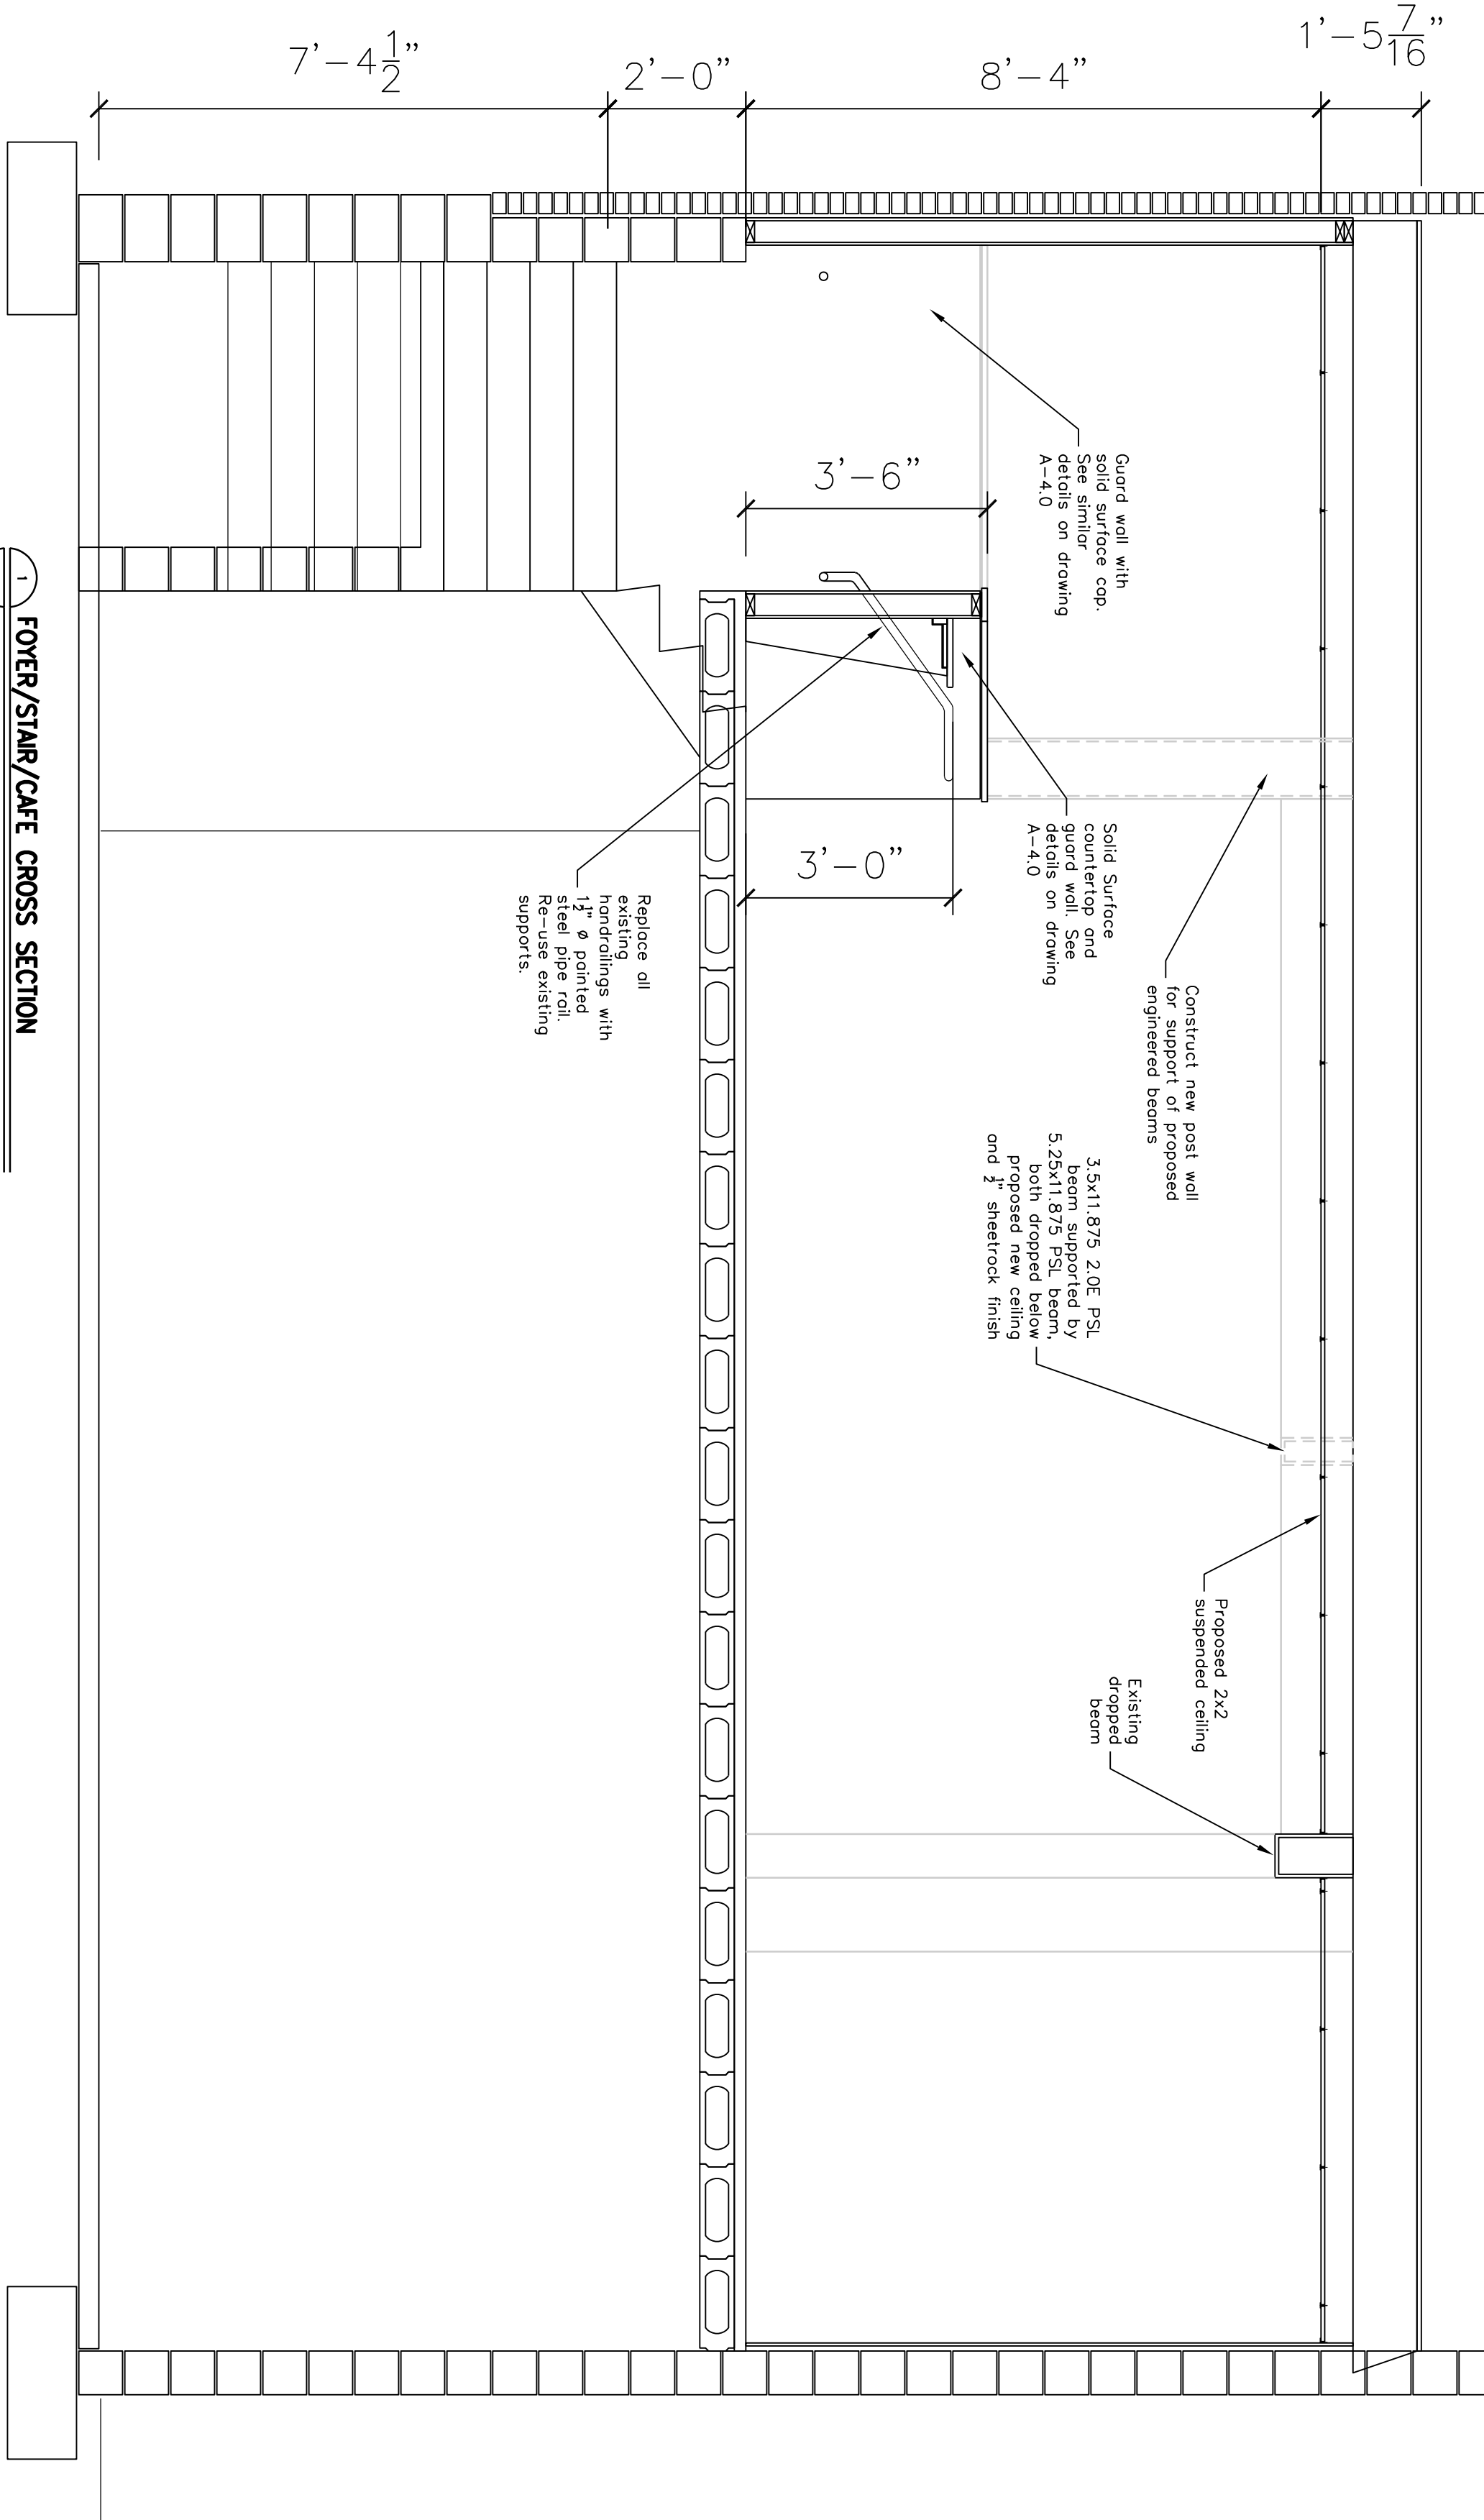

1 Foyer/Stair/Cafe CROSS SECTION
A-3.3 1/2" = 1'-0"

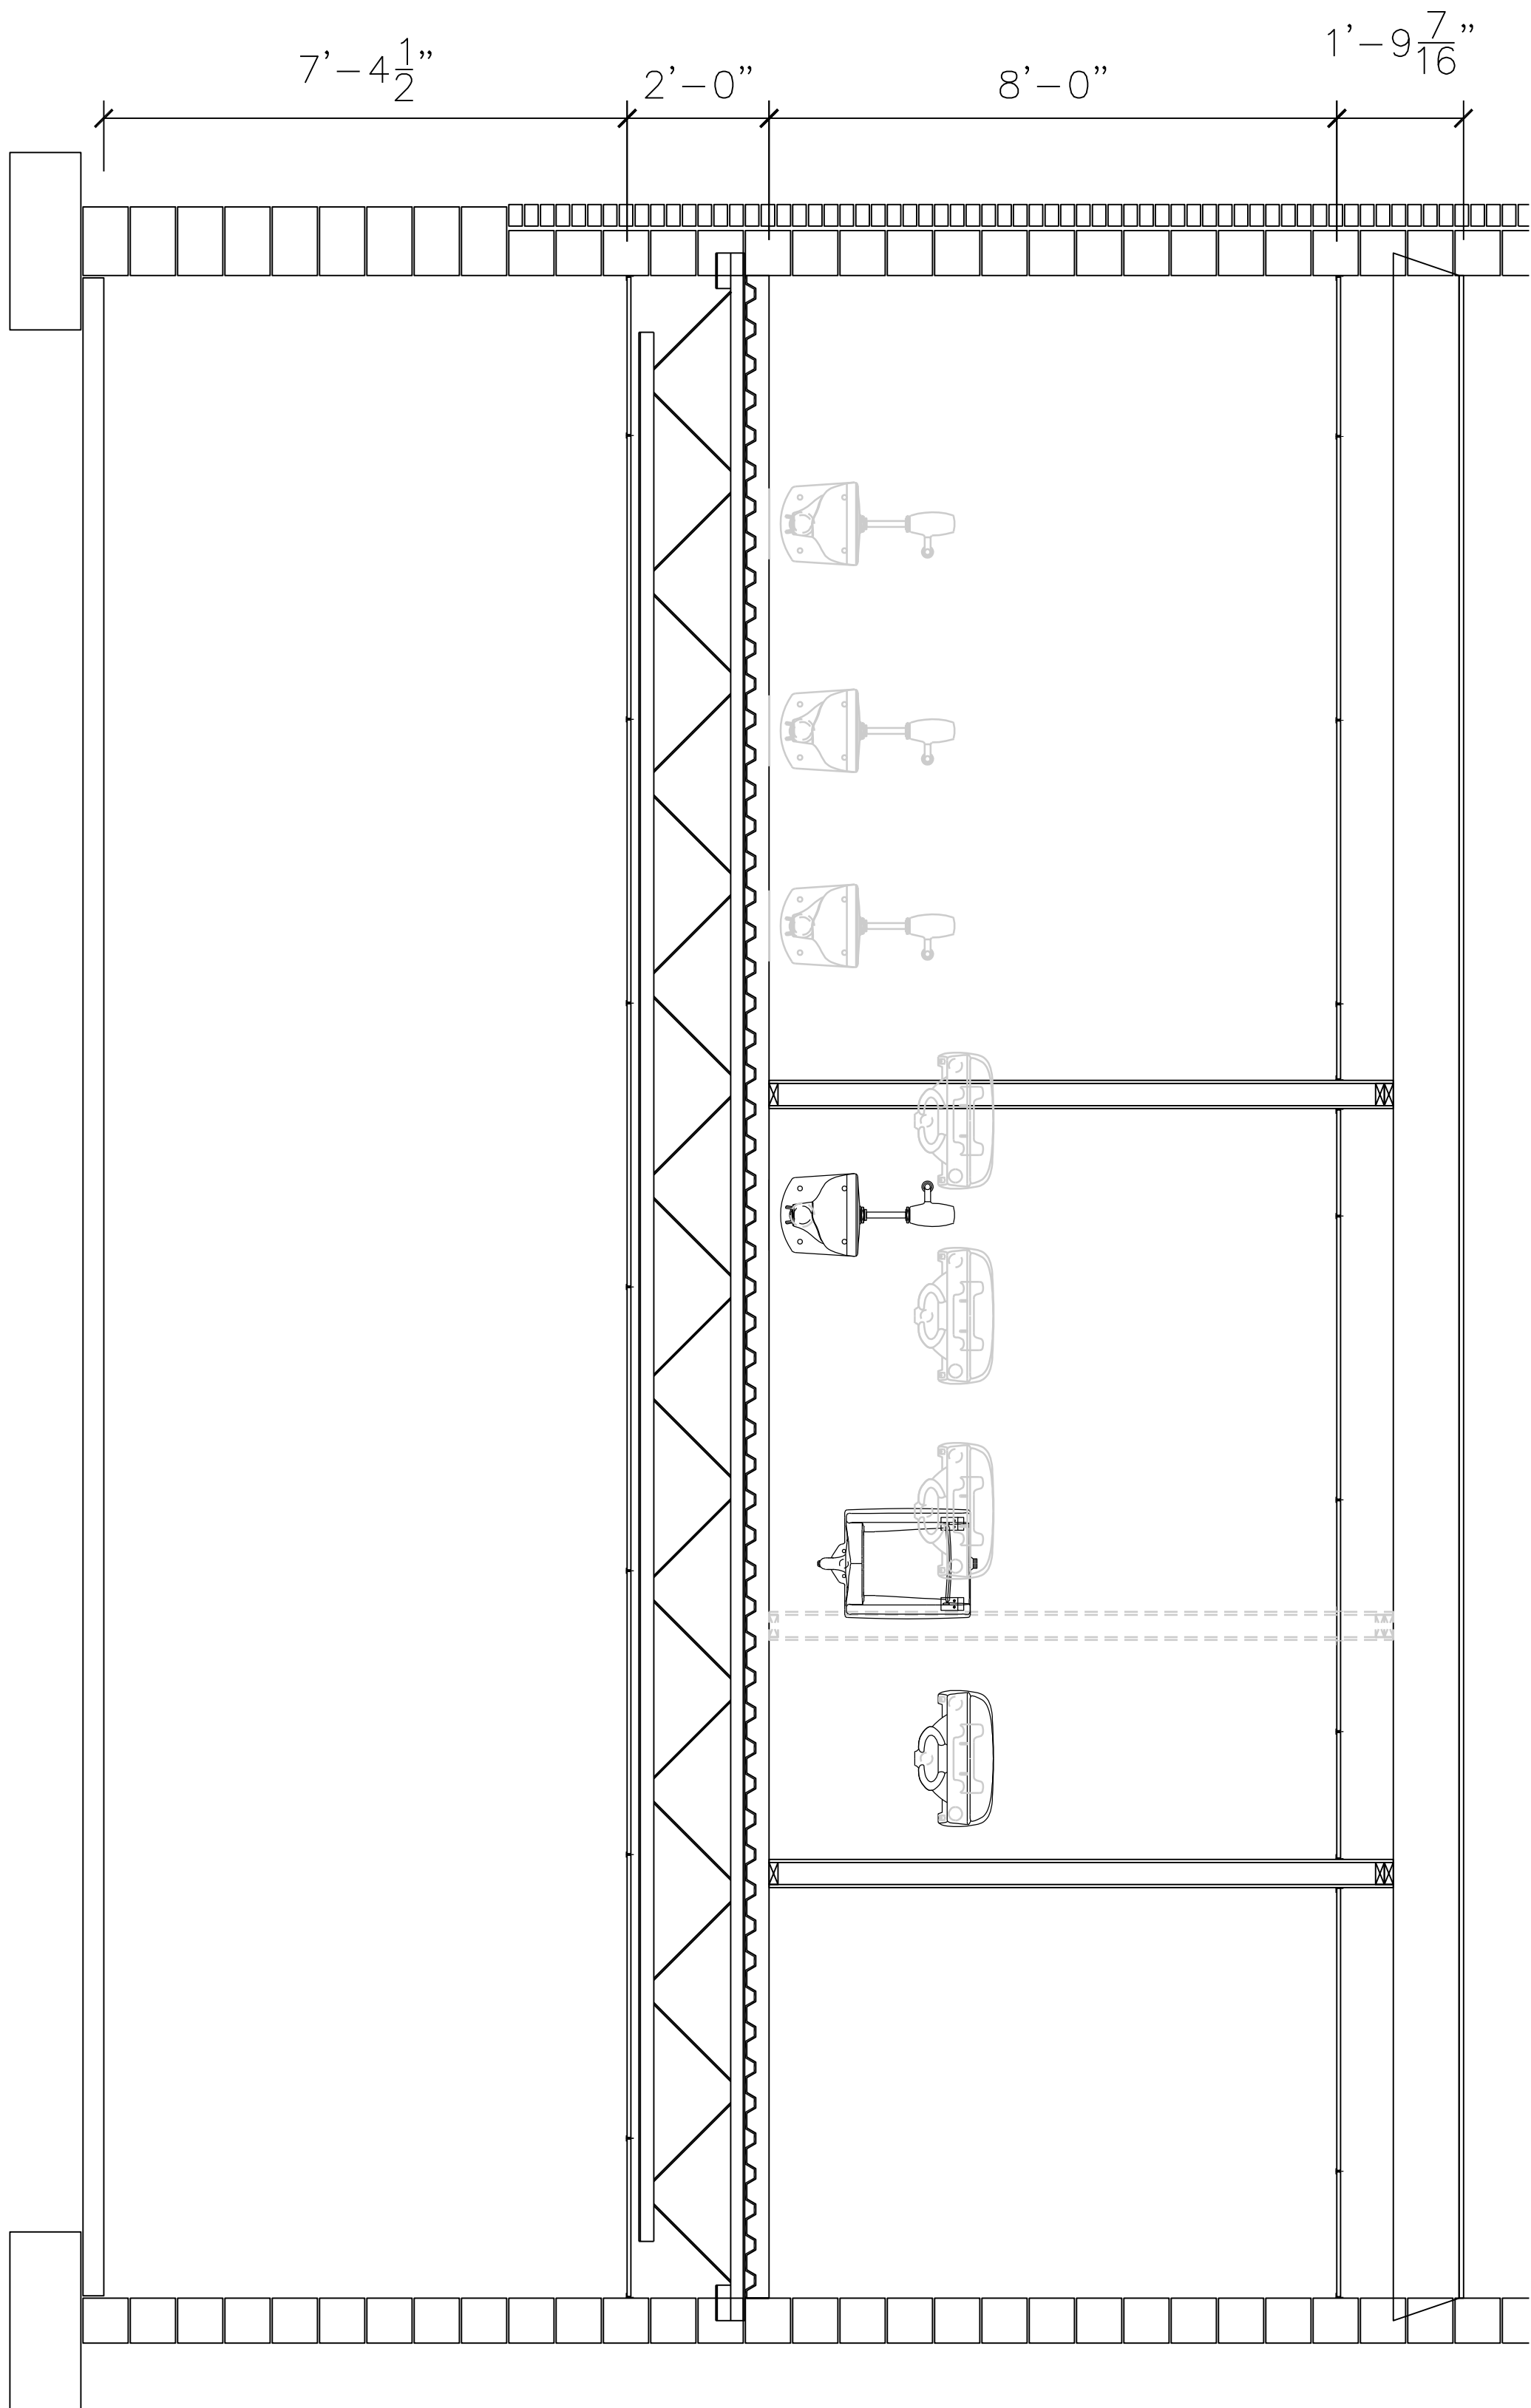

2 STAGE EXTENSION SECTION
A-3.3 1/2" = 1'-0"

A-3.3

Drawing No.

PROPOSED FOYER RENOVATION & ACCESSIBILITY UPGRADES FOR
CROSSBRIDGE COMMUNITY CHURCH
11 GRISCOM ROAD * WEST DEPTFORD, NJ 08096 B-356A L-1&1A

FOYER & BATHROOM SECTIONS & NOTES


Drawn By:	RLH	Date:	05/23/2025	Scale:	AS NOTED
Checked By:	RLH	Revised:	05/27/2025	Project No.:	21-01

COPYRIGHT © 2025
RANDALL HOLBERG LLC
ARCHITECT
ALL RIGHTS RESERVED.

RANDALL HOLBERG LLC
ARCHITECT



178 SOUTH LAKESIDE DRIVE EAST * MEDFORD, NEW JERSEY 08055
TELE: (609) 923-3423 Email: RLHrktect@gmail.com

RLH NJ REG. 10848


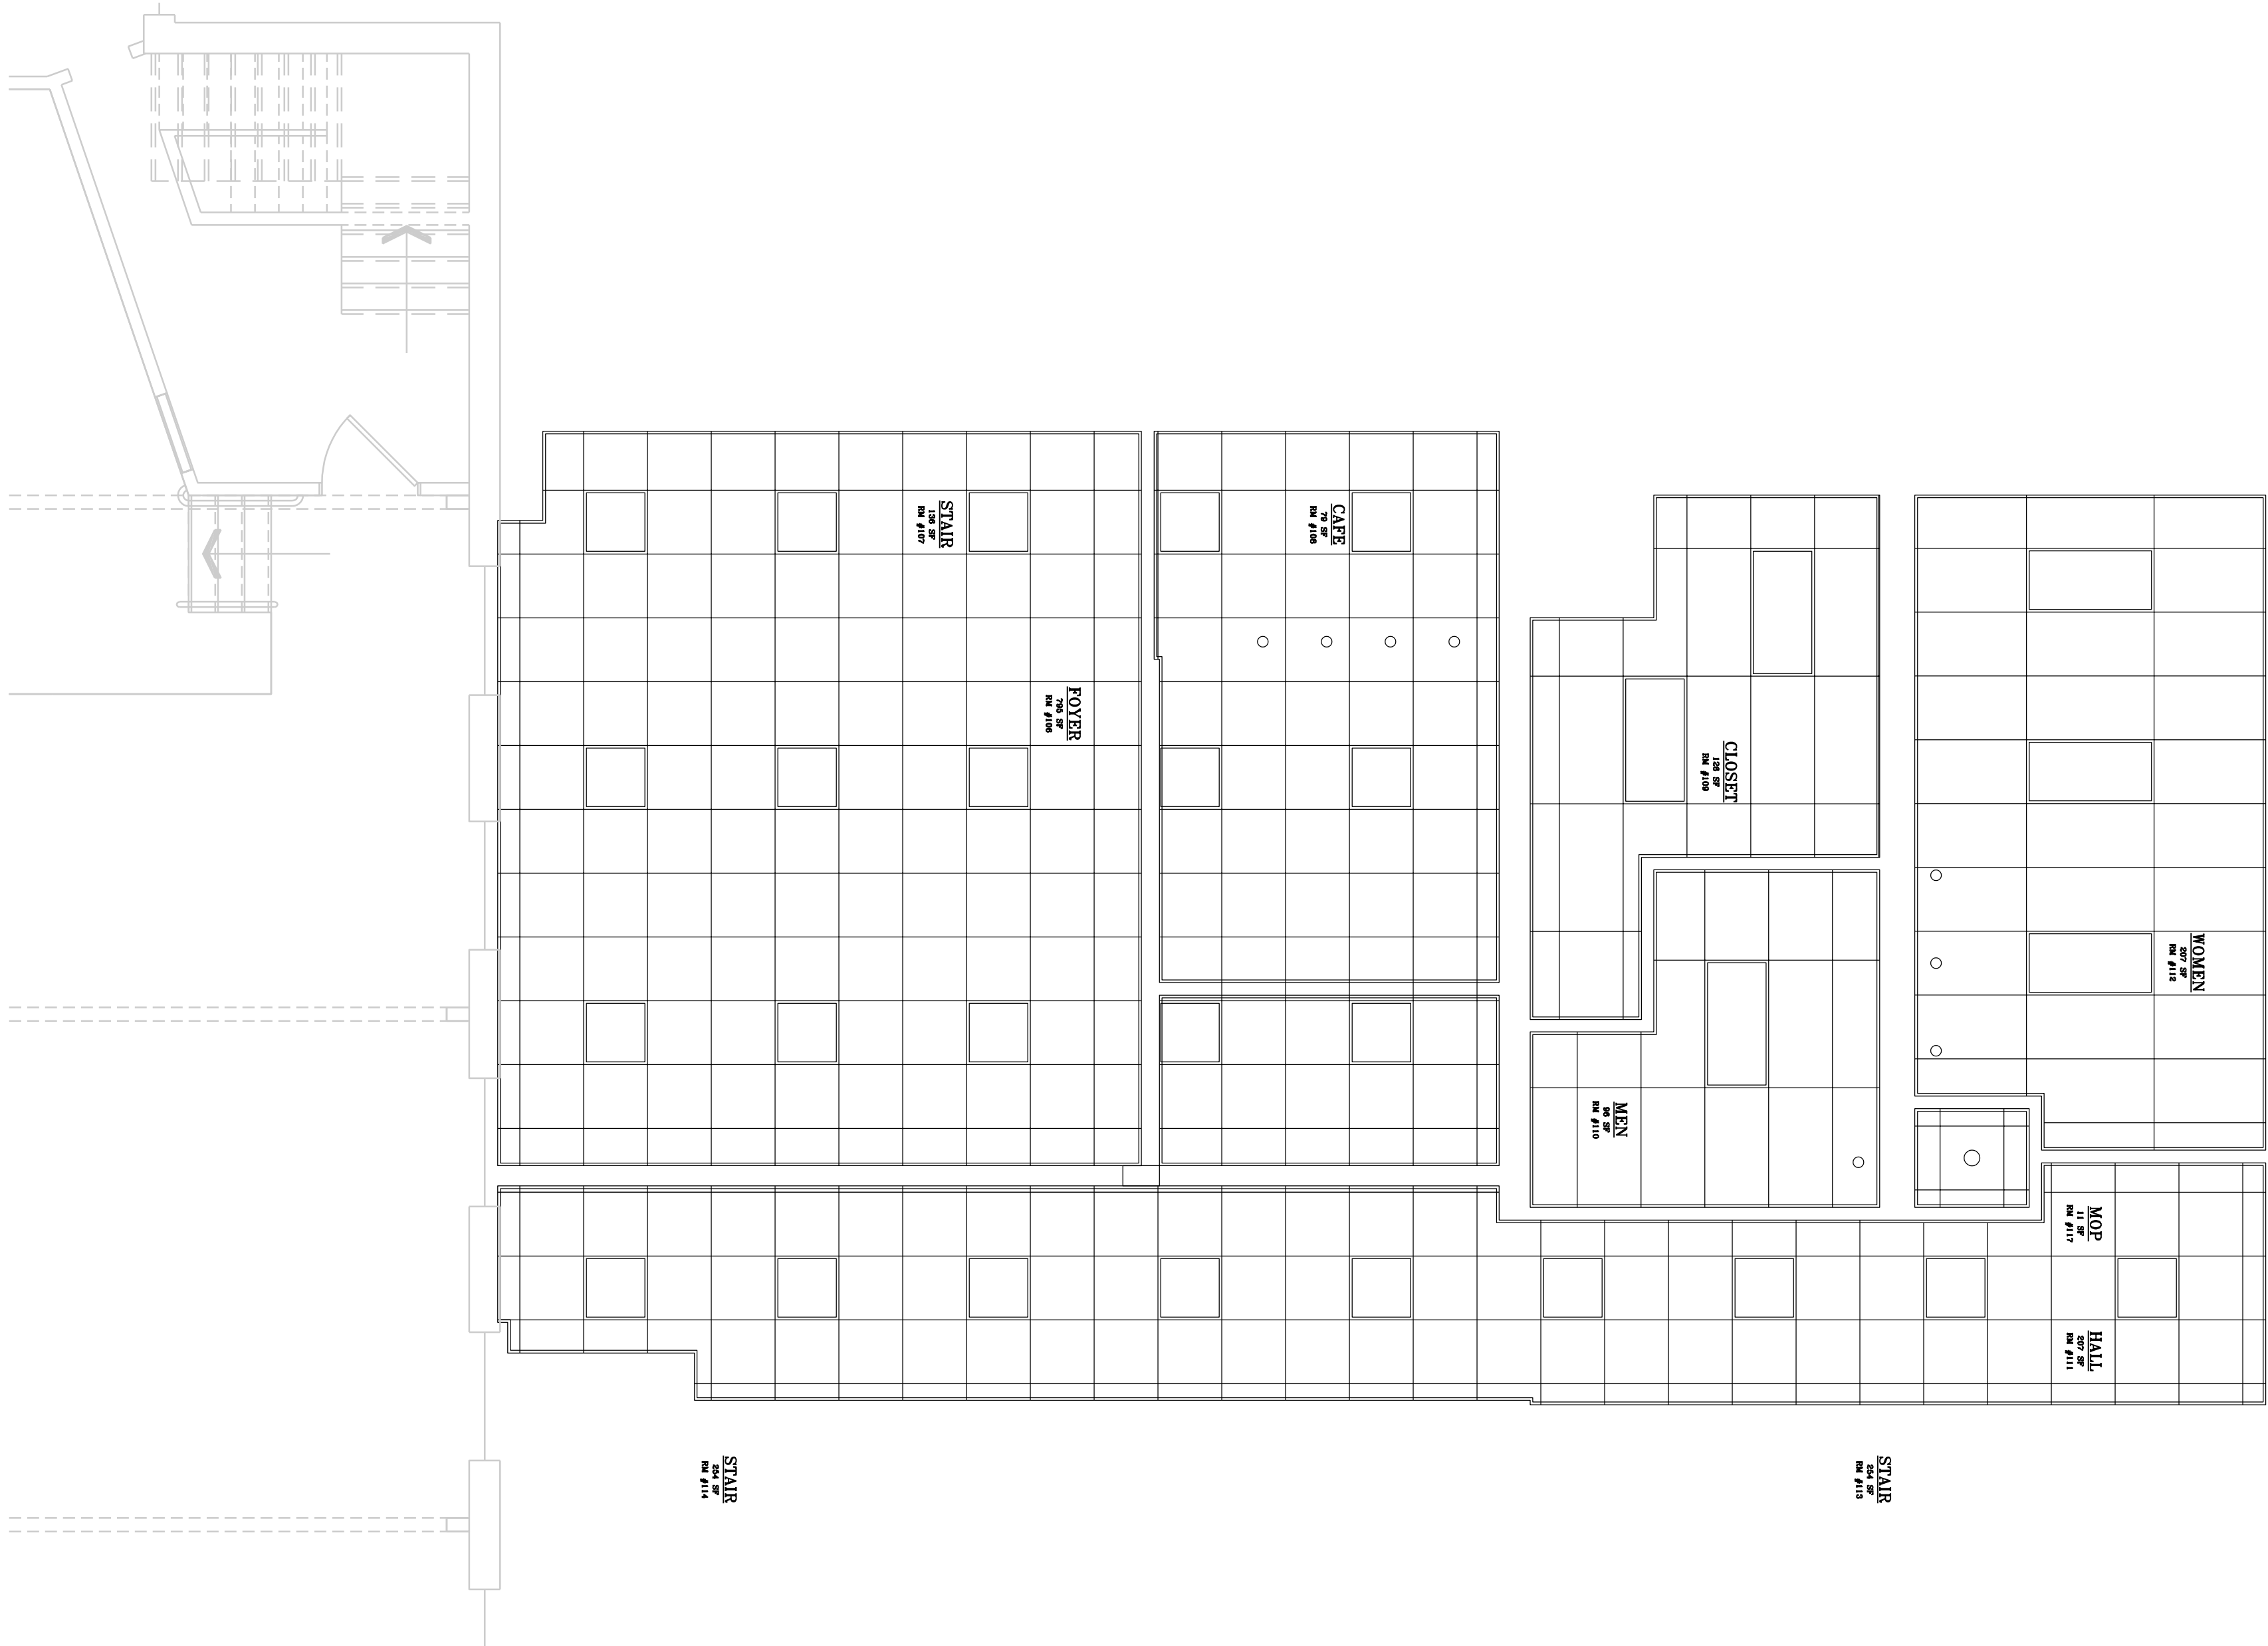


2 FIRST REFLECTED CEILING PLAN


095100 ACoustical GRD AND CEILING,
ARMSTRONG ULTIMA LXV-IN 2X2 W/ 15/16" GRD, WHITE

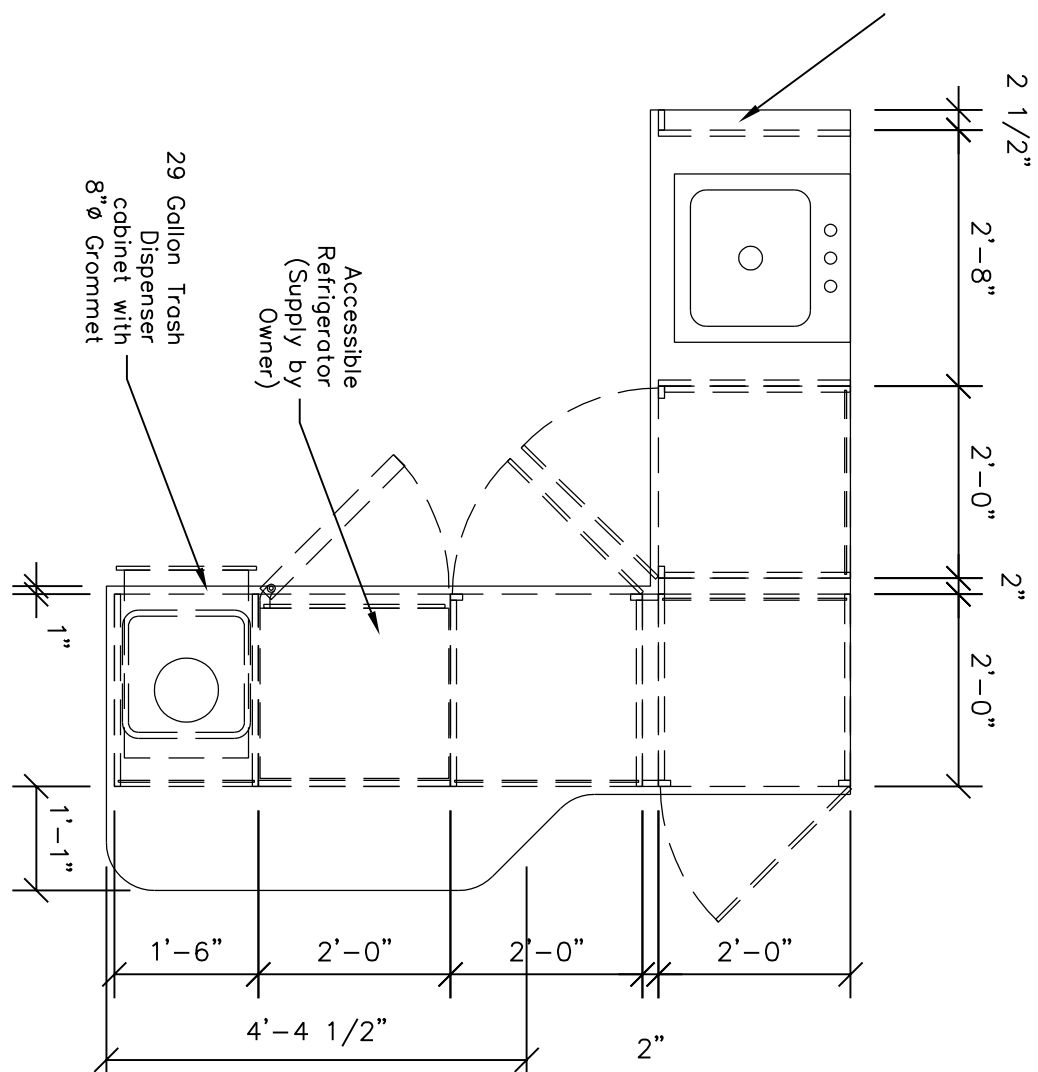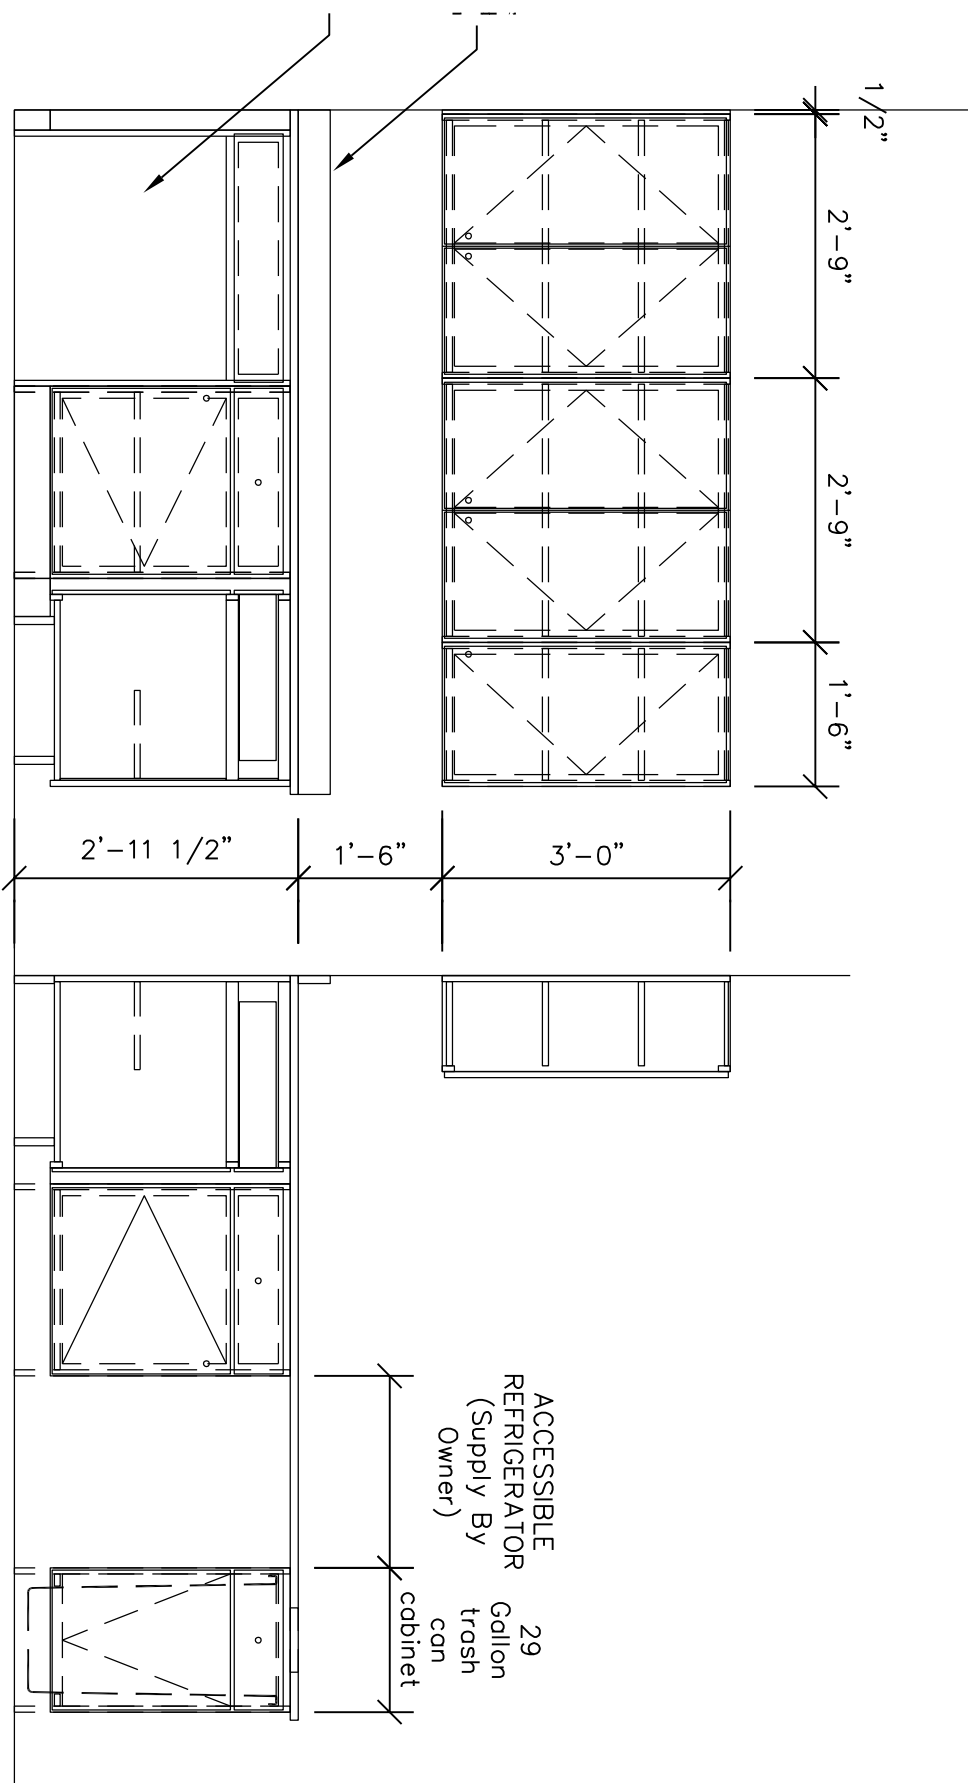



3 CAFE CABINETRY PLAN & ELEVATIONS

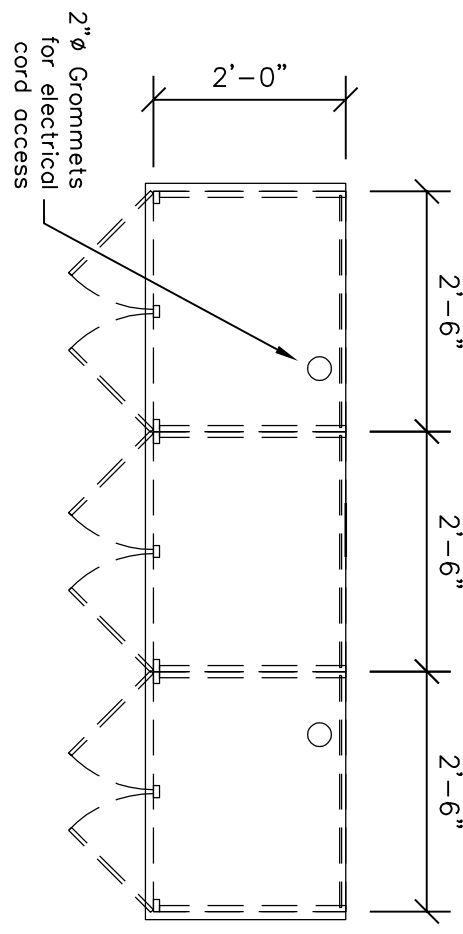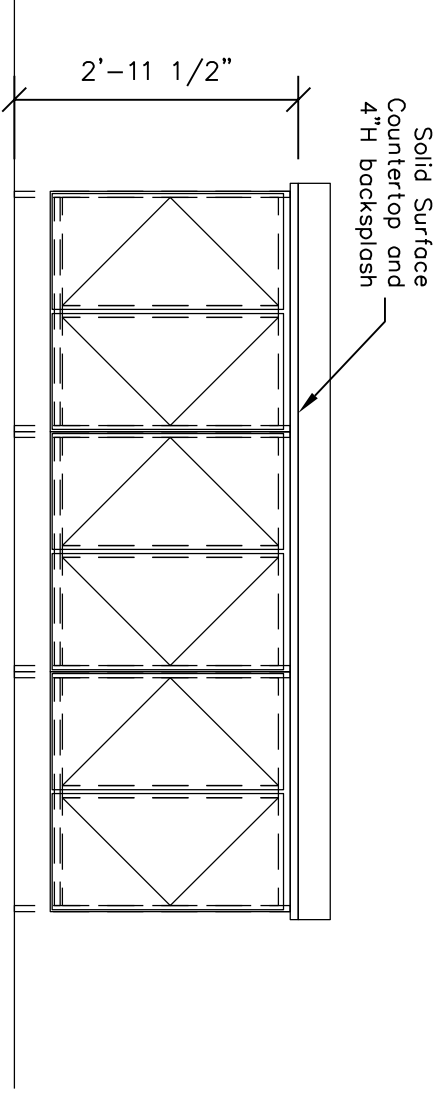

4 CHECK-IN CABINETRY PLAN & ELEVATIONS

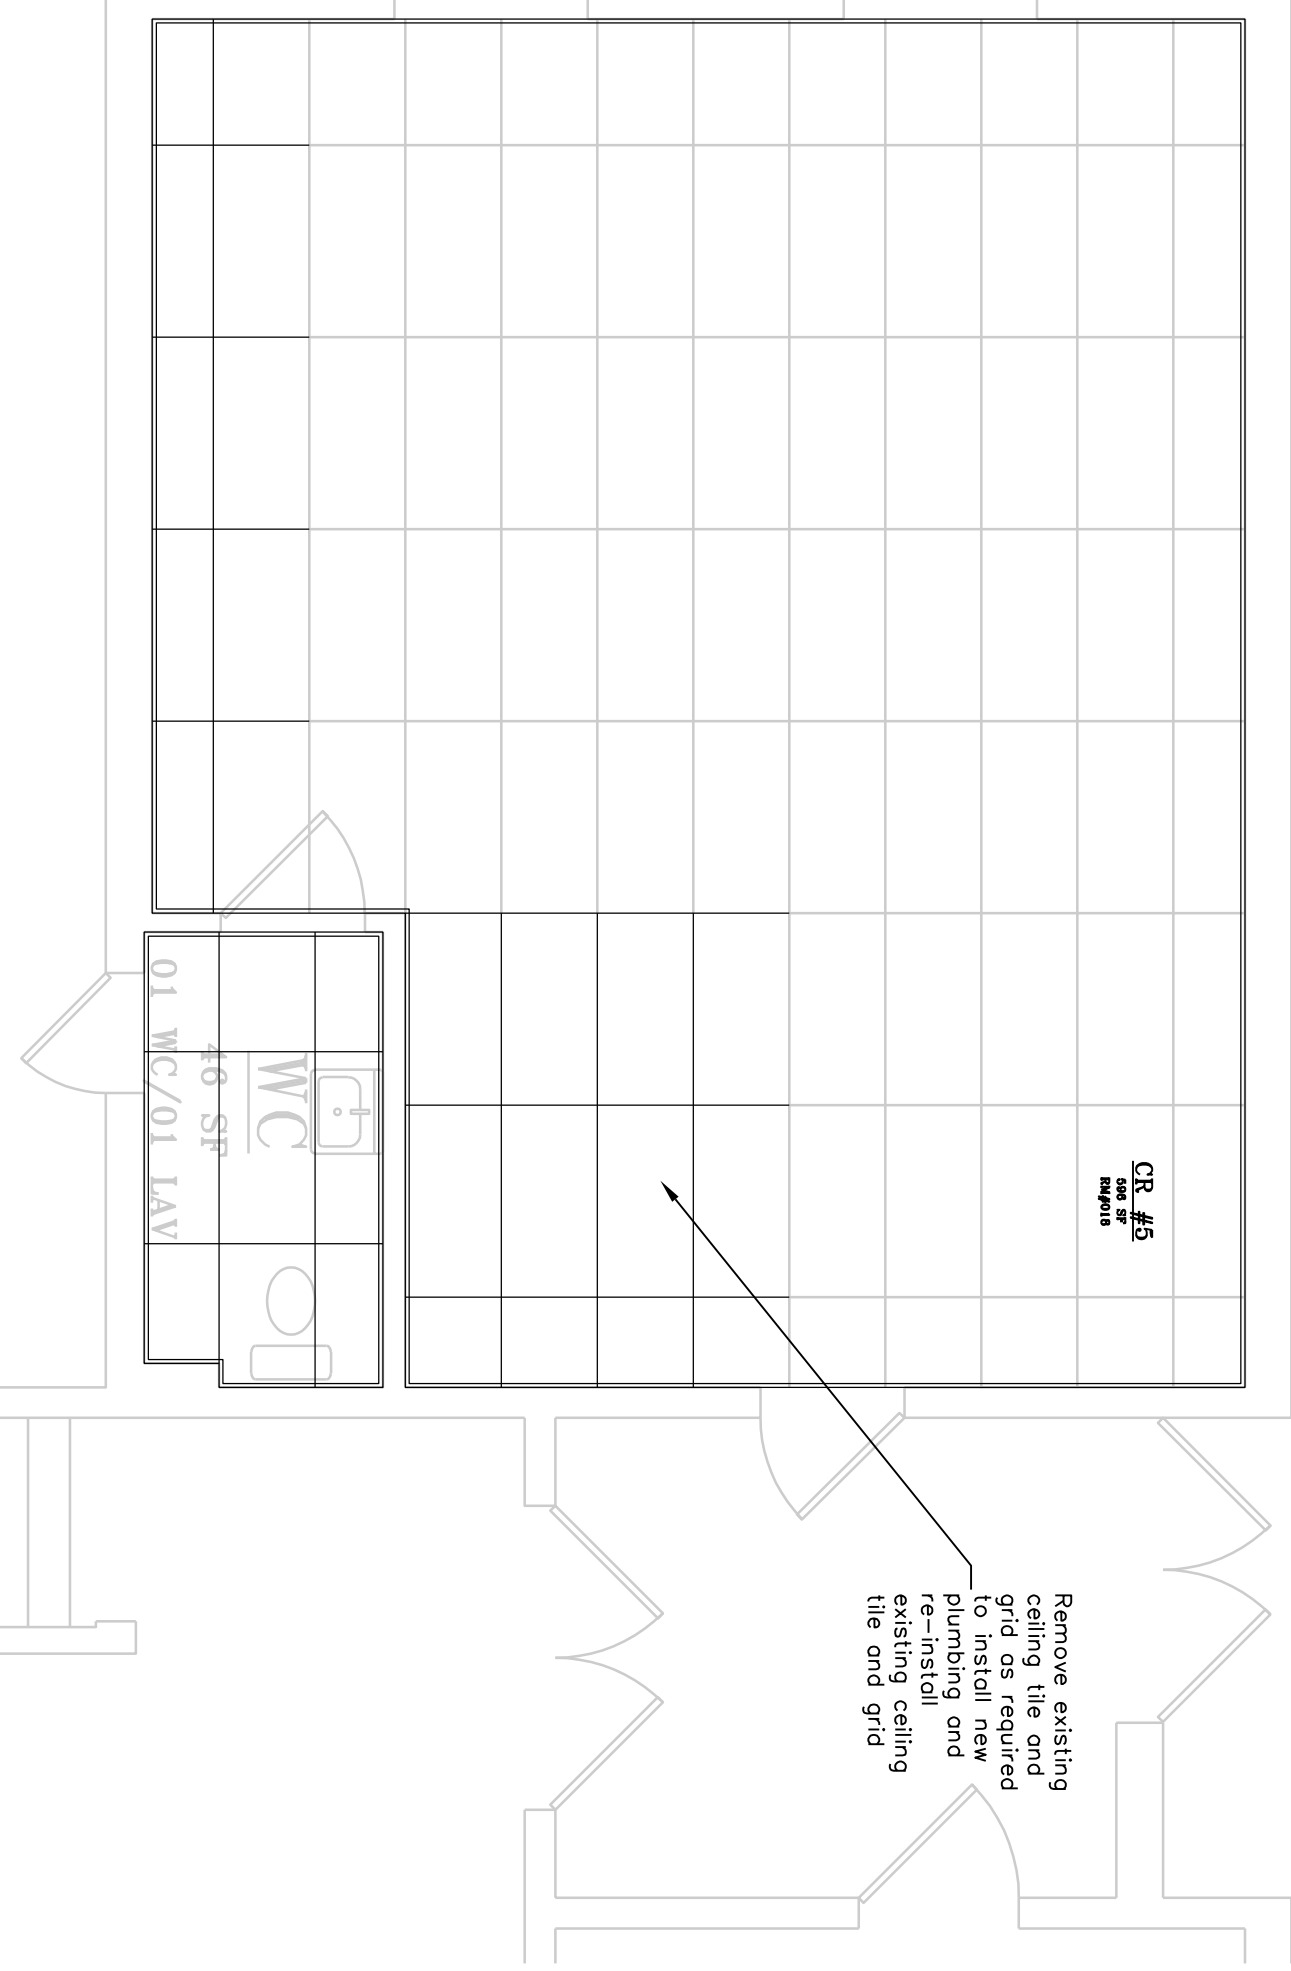

1 BASEMENT REFLECTED PLAN

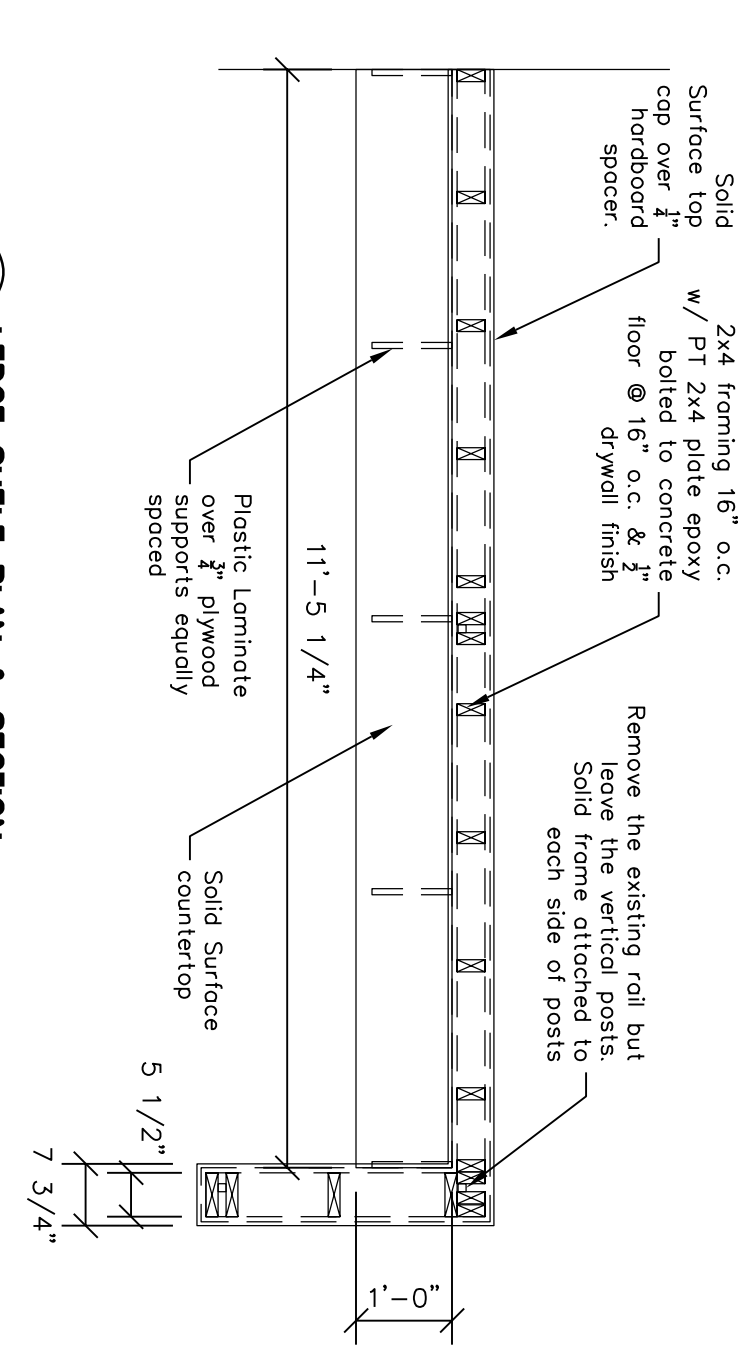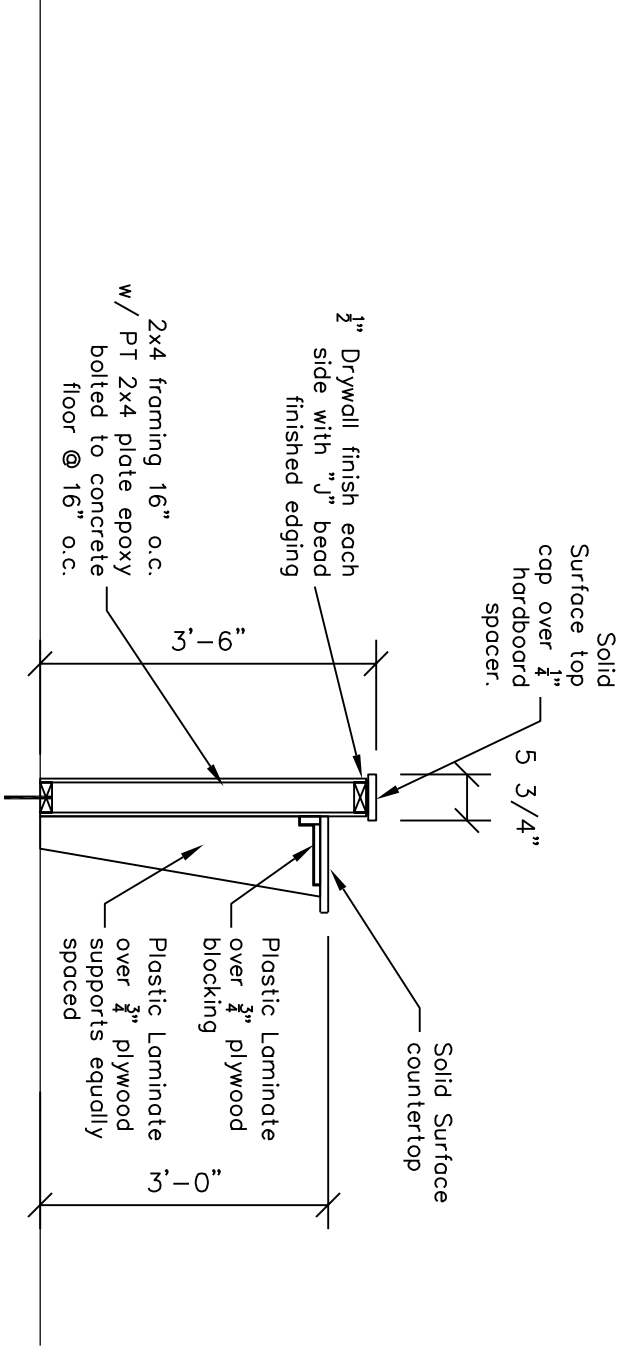

5 LEDGE SHELF PLAN & SECTION

PROPOSED FOYER RENOVATION & ACCESSIBILITY UPGRADES FOR CROSSBRIDGE COMMUNITY CHURCH 11 GRISCOM ROAD * WEST DEPTFORD, NJ 08096 B-356A L-1&1A			
REFLECTED CEILING PLANS & CABINETRY			
Drawn By:	RLH	Date:	05/23/2025
Checked By:	RLH	Revised:	05/27/2025
Scale:	AS NOTED	Project No.:	23-37

COPYRIGHT © 2025
RANDALL HOLBERG LLC
ARCHITECT
ALL RIGHTS RESERVED.


RANDALL HOLBERG LLC
ARCHITECT

178 SOUTH LAKESIDE DRIVE EAST • MEDFORD, NEW JERSEY 08055
TELE: (609) 923-3423 Email: RLHrktect@gmail.com


RLH NJ REG. 10848

Drawing No.


A-4.0

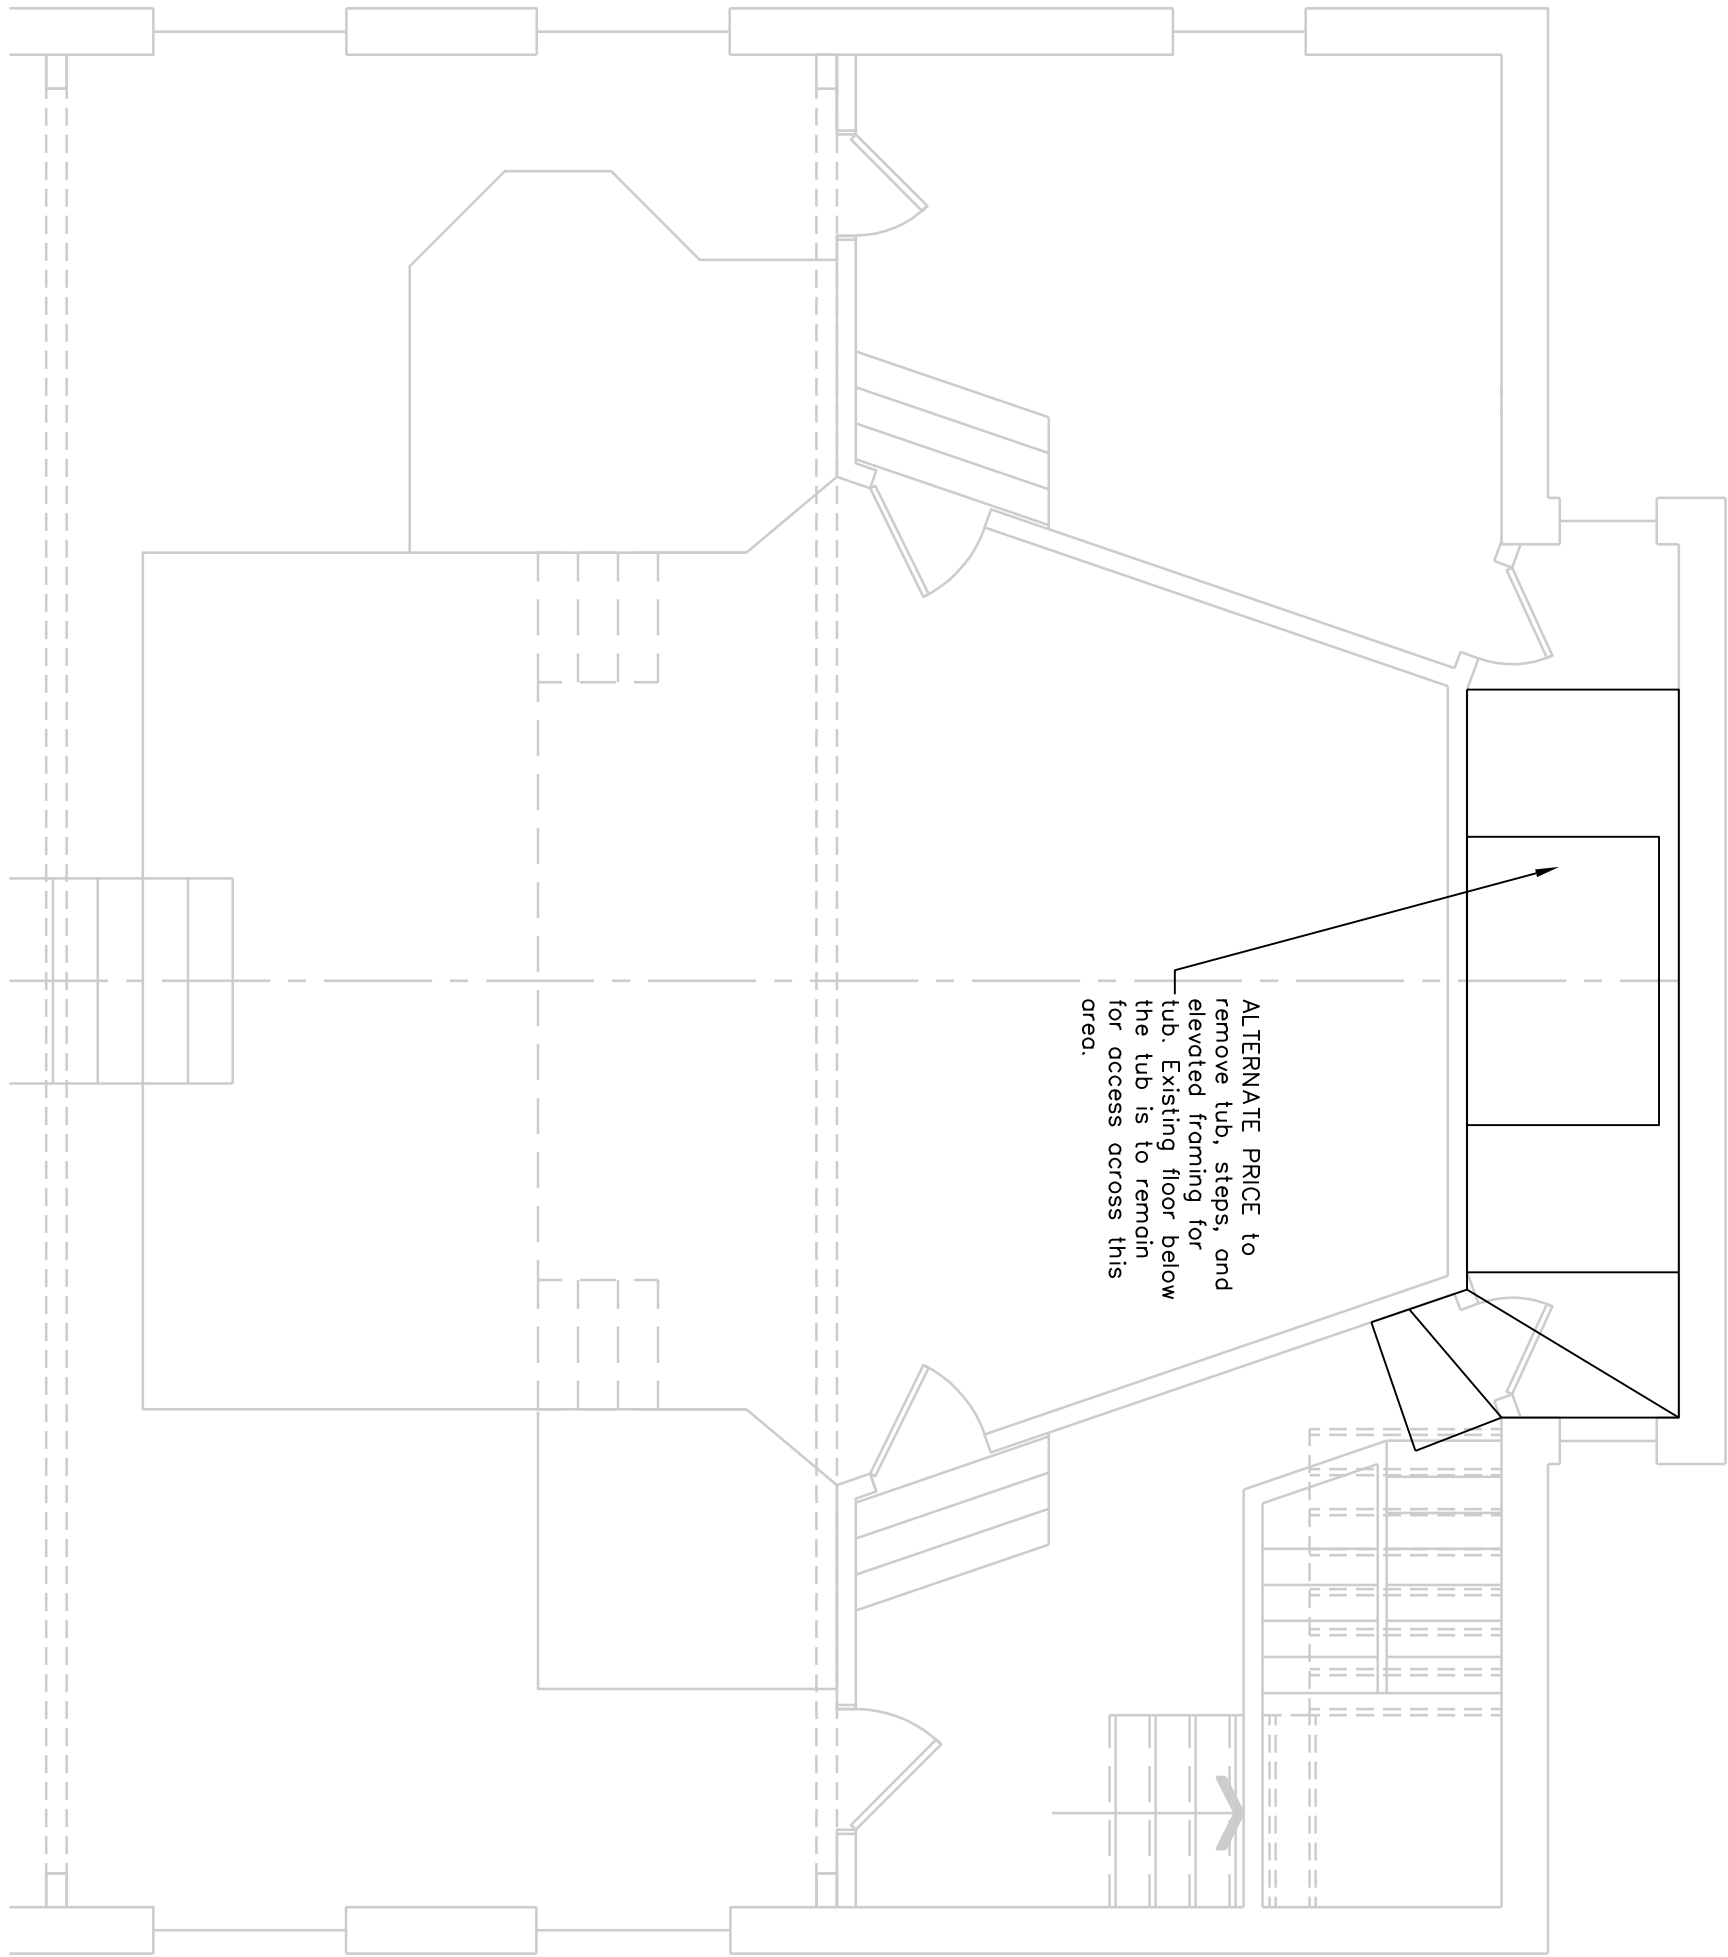


3 PROPOSED MEZZANINE TUB/PLATFORM DEMO.

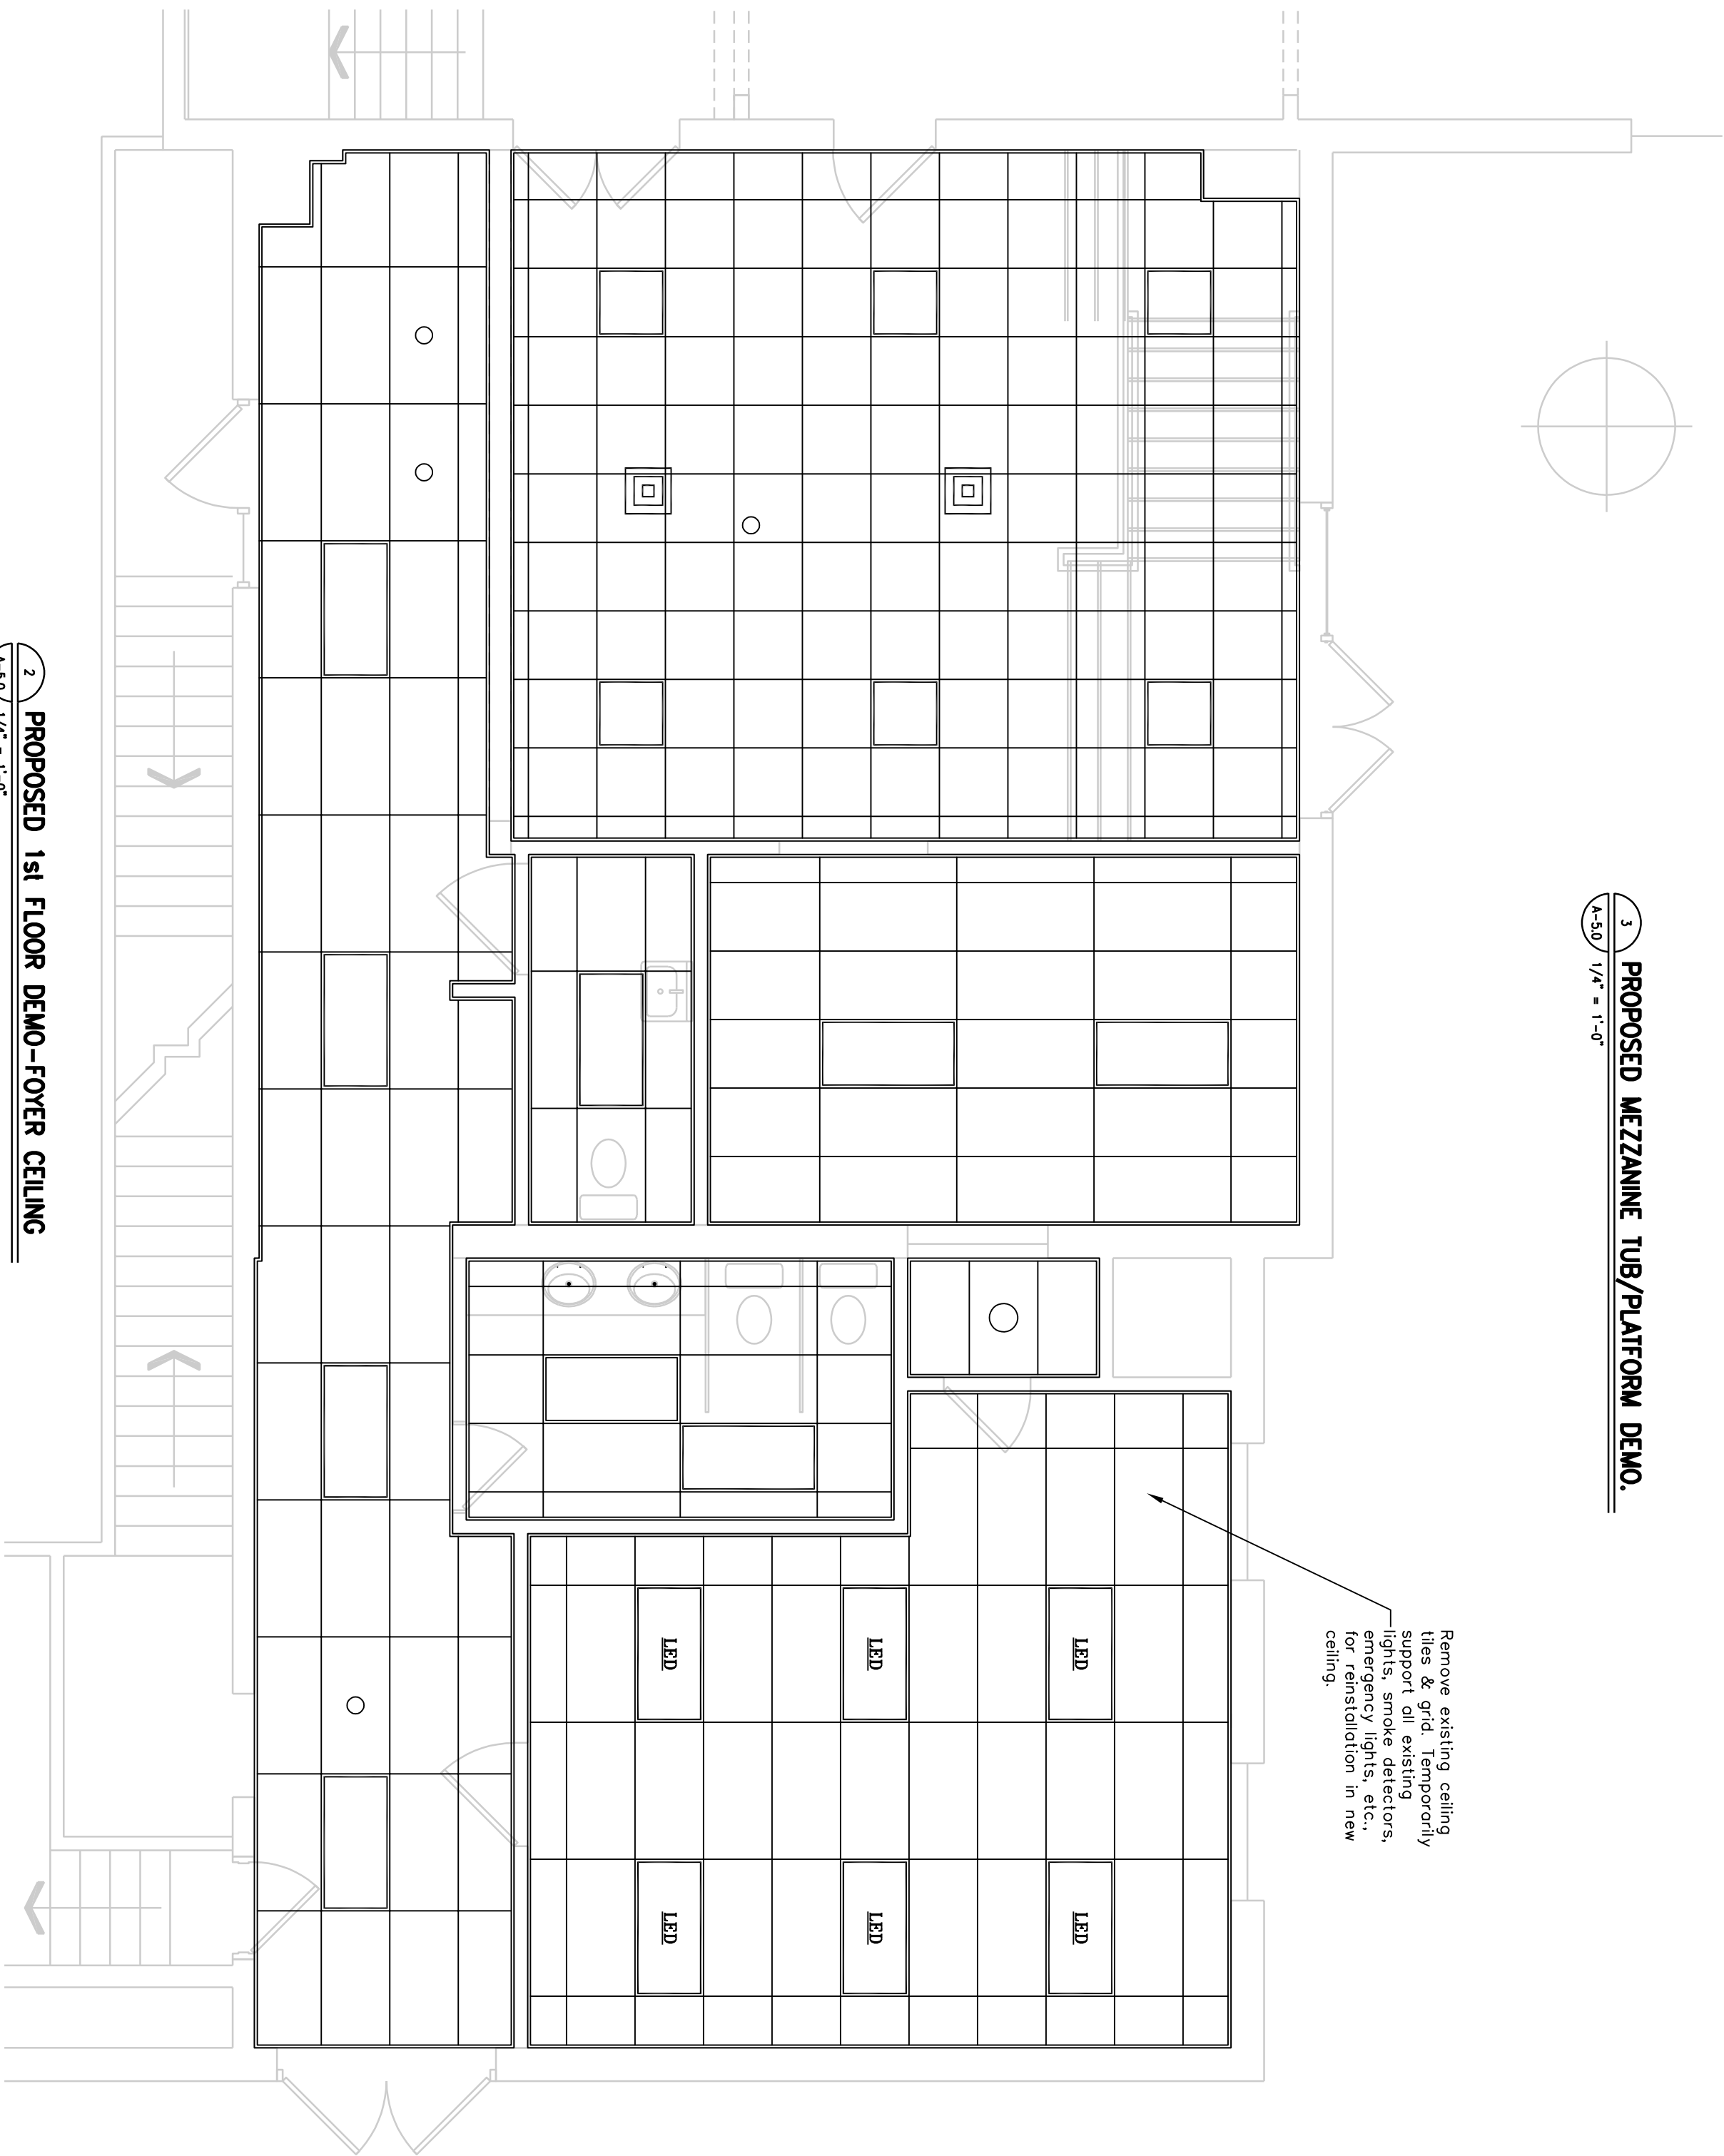

2 PROPOSED 1st FLOOR DEMO-FOYER CEILING

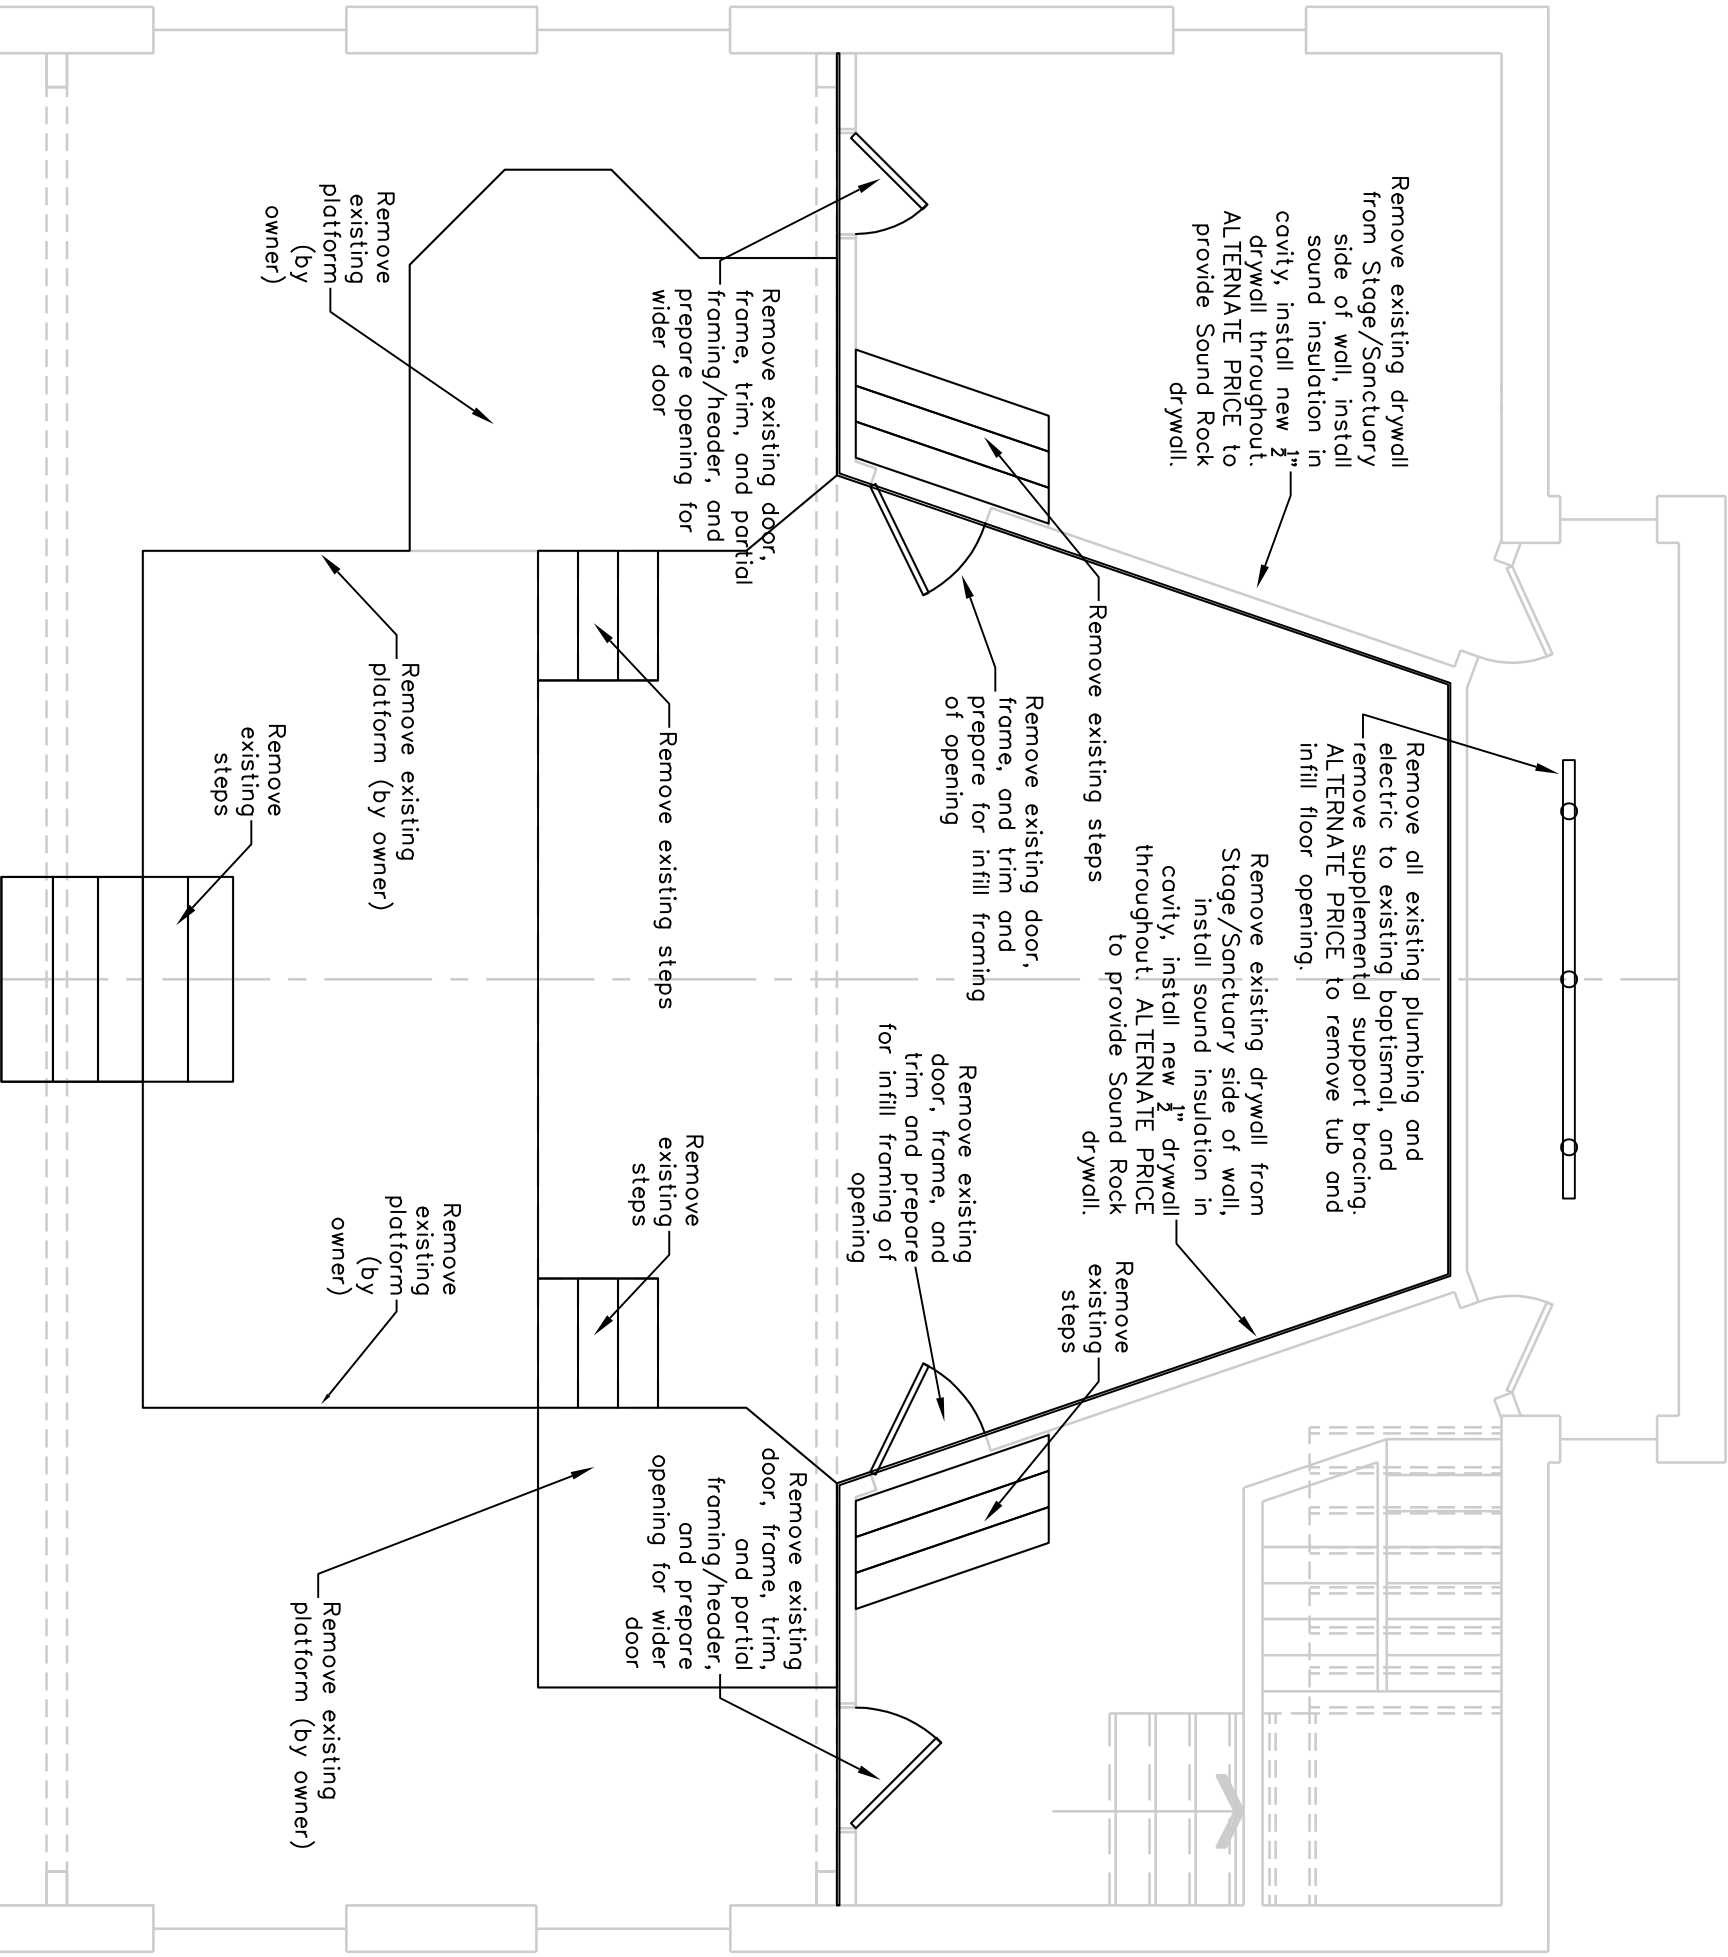


4 PROPOSED 1st FLOOR DEMO-FOYER WALLS

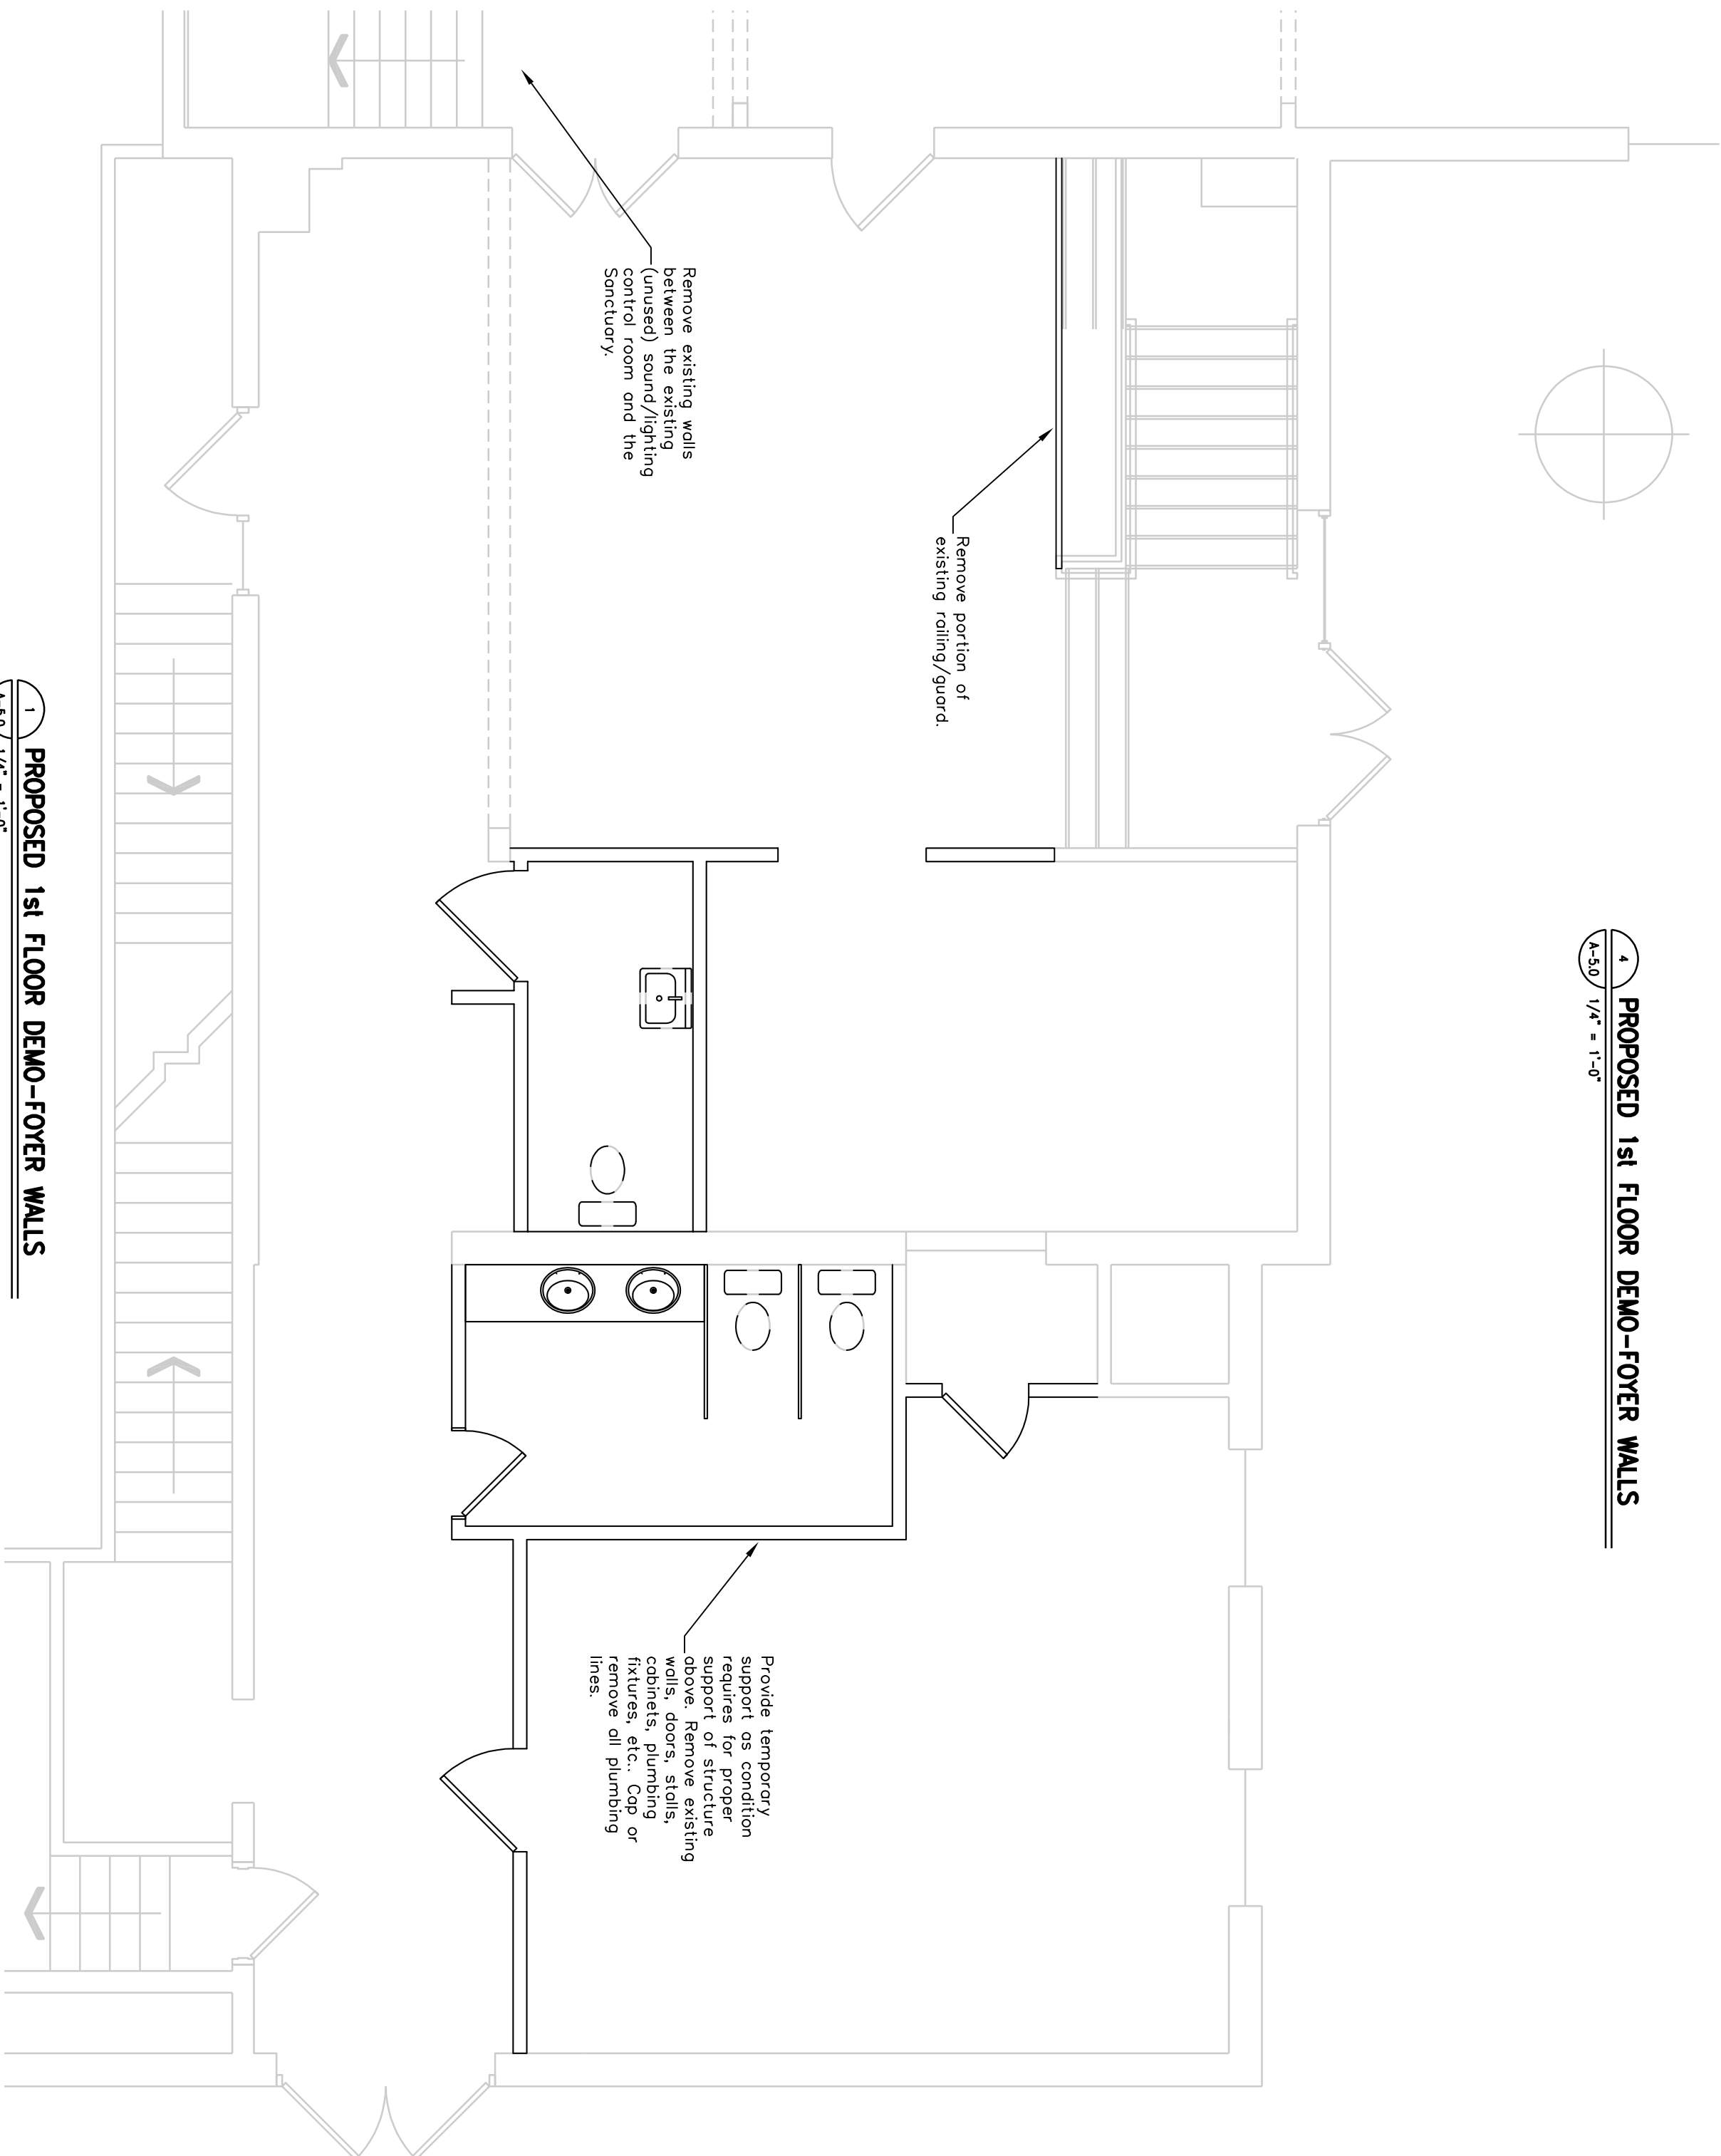



1 PROPOSED 1st FLOOR DEMO-FOYER WALLS

[illegible]

3 ELEC POWER/LIGHTING PLAN-BASEMENT
E-1.0 1/4" = 1'-0"

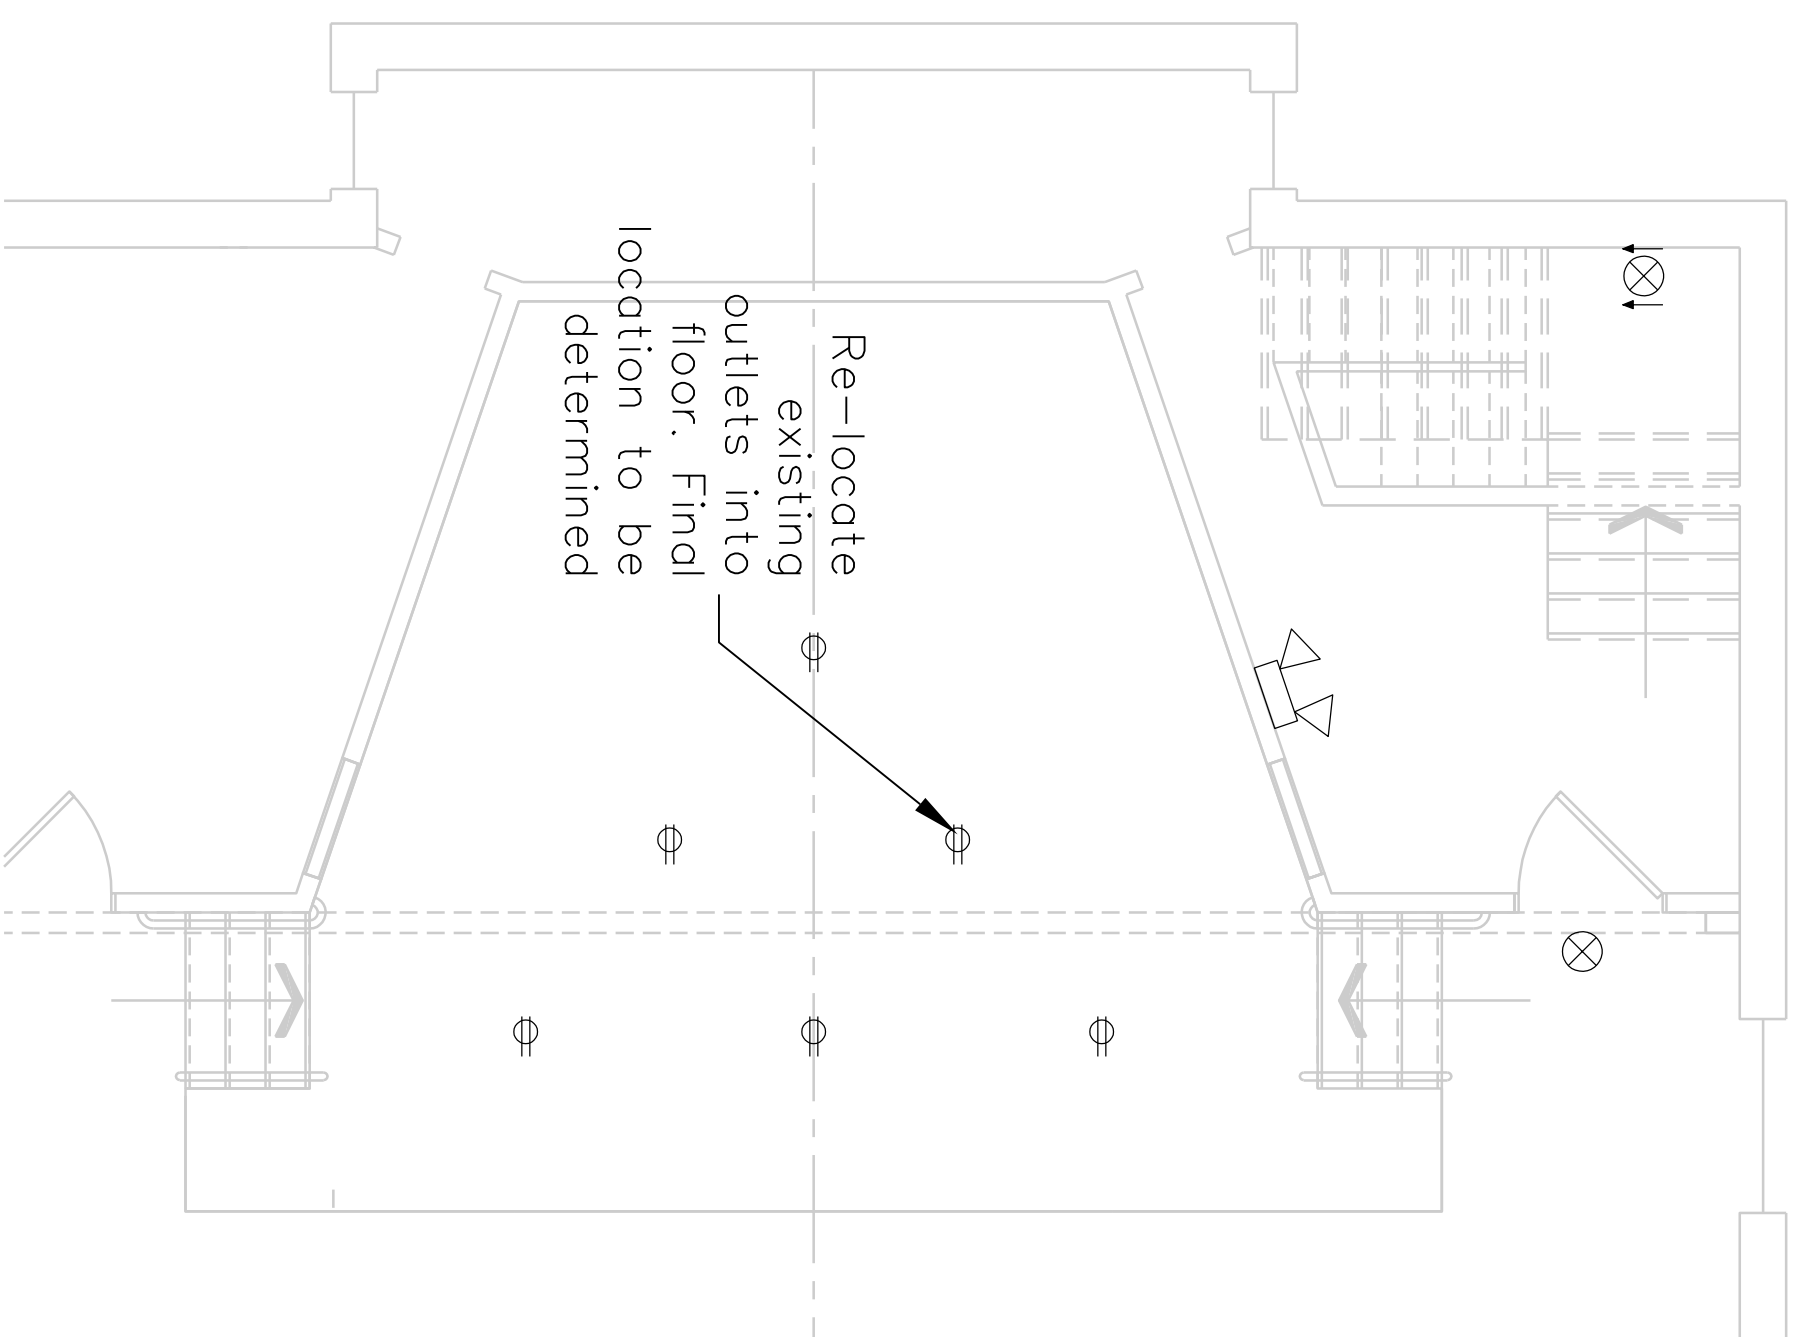

3 ELEC POWER/LIGHTING PLAN-BASEMENT
E-1.0 1/4" = 1'-0"

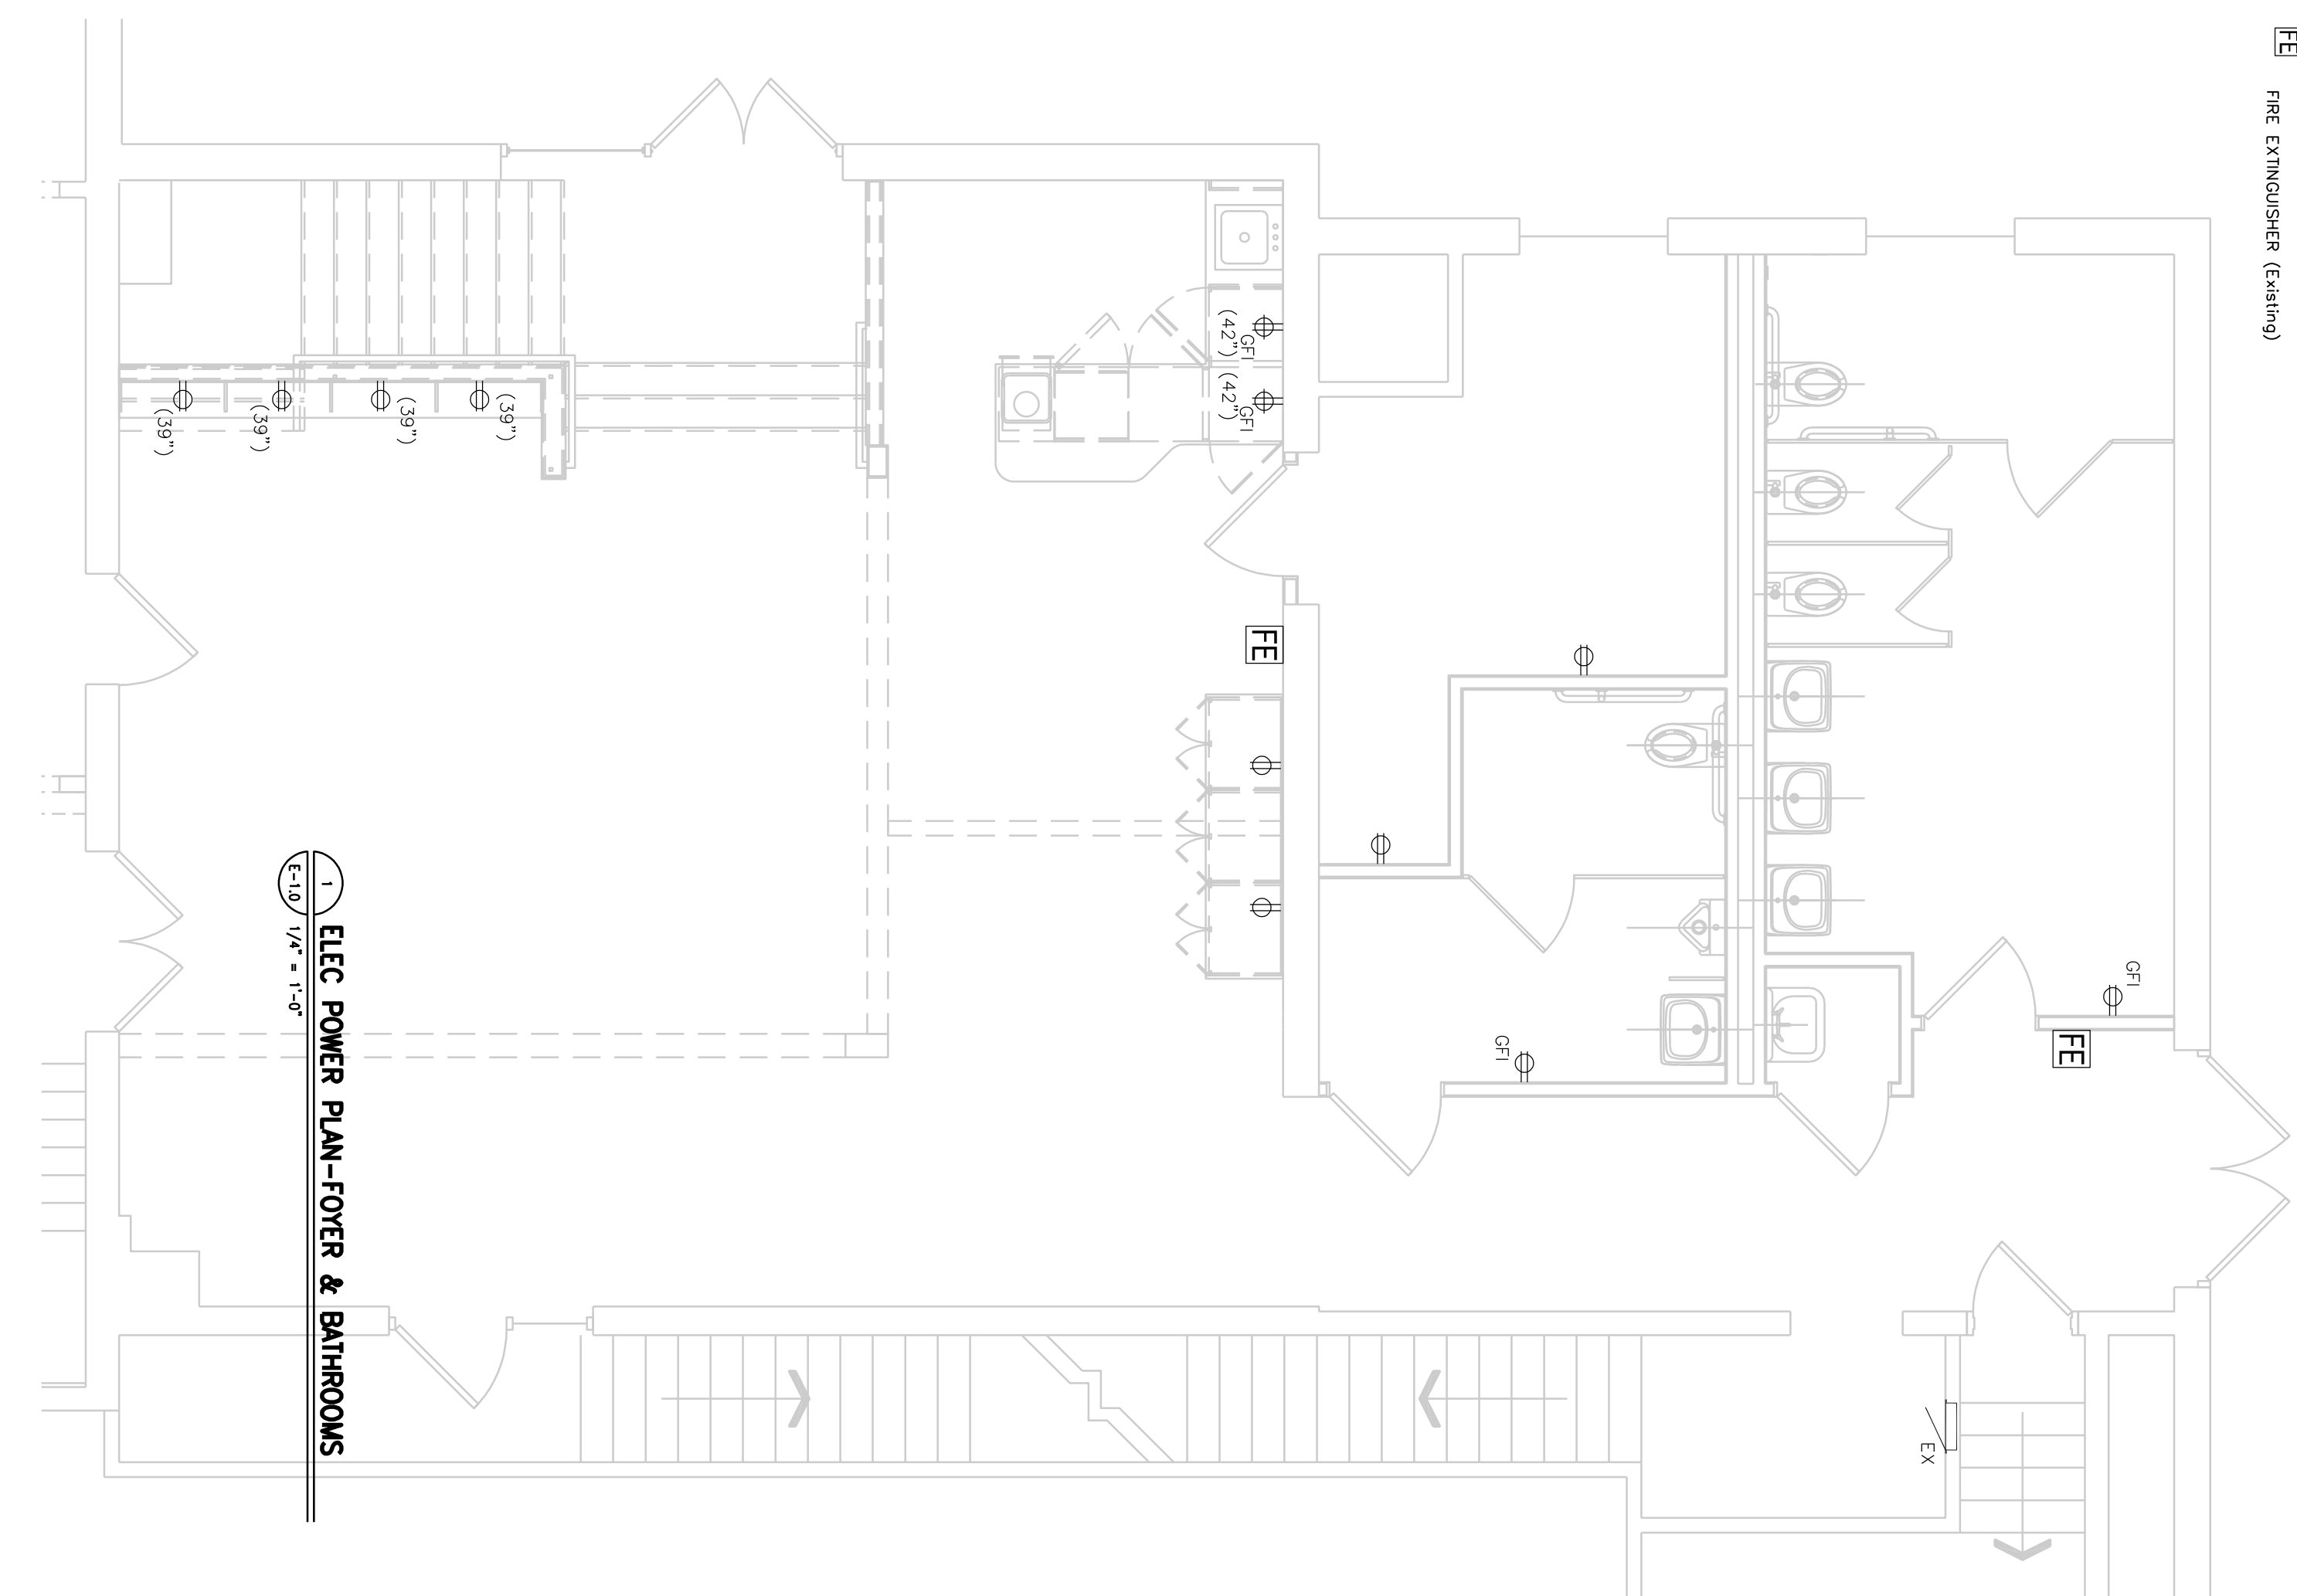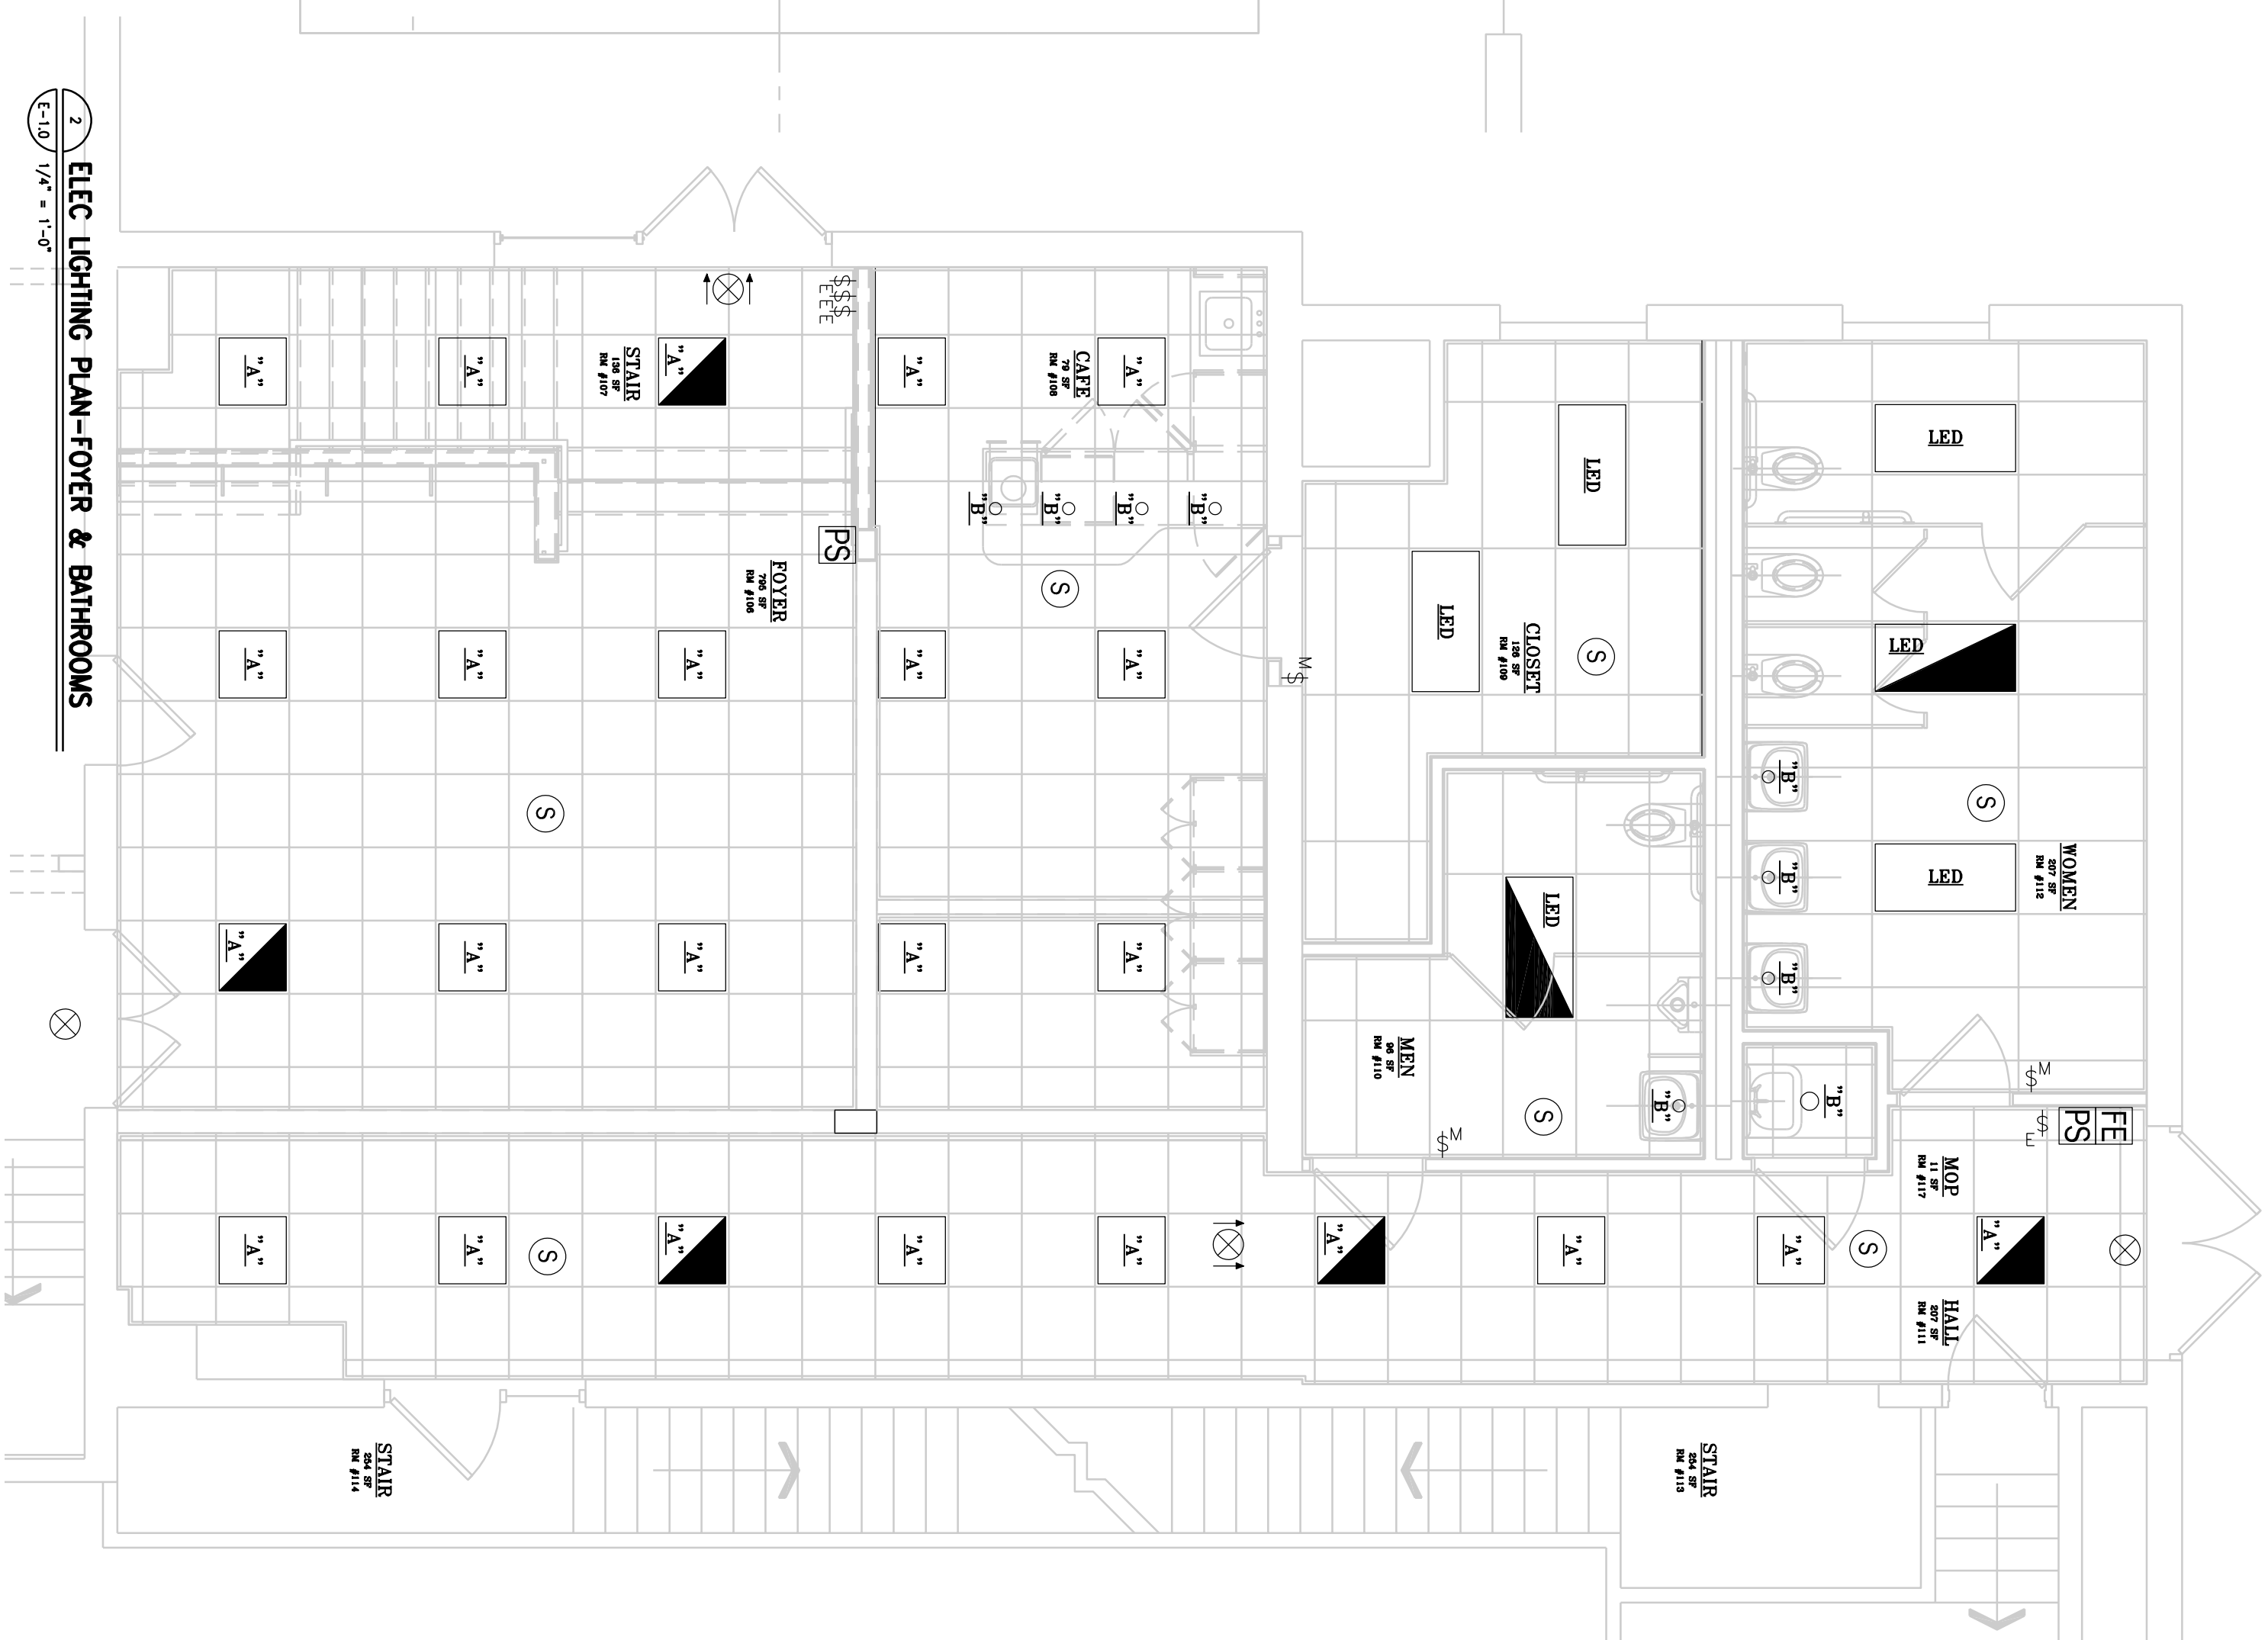

1	ELEC POWER PLAN-FOYER & BATHROOMS
E-10	1/4" = 1'-0"

ELECTRICAL SYMBOLS:

- | | |
|---|---|
|  | EXISTING ELECTRICAL PANELBOARD |
|  | DUPLEX RECEPTACLE OUTLET (12V) |
|  | DUPLEX RECEPTACLE OUTLET (High) |
|  | DUPLEX OUTLET (60V) |
|  | JUNCTION BOX |
|  | DISCONNECT |
|  | CEILING LIGHT - 2x4 (Existing re-installed) |
|  | SUSPENDED CEILING LIGHT - 2x2 |
|  | CEILING LIGHT - 2x2x4 w/CM BATT |
|  | WALL MOUNT LIGHT |
|  | WAFFLE RECESS CEILING LIGHT |
|  | SINGLE POLE SWITCH (Existing) |
|  | MOTION SENSORED SWITCH |
|  | DENOTES WEATHERPROOF |
|  | DENOTES GROUND FAULT INTERRUPTER |
|  | SMOKE DETECTOR (Existing re-installed) |
|  | CARBON MONOXIDE DETECTOR |
|  | AUDIO VISUAL DEVICE |
|  | PULL STATION (Existing re-installed) |
|  | BLANK JUNCTION BOX-EXISTING |
|  | ILLUMINATED EXIT SIGN-DIRECTION |
|  | WALL PACK EMERGENCY LIGHT-BATTERY |
|  | WALL PACK EMERGENCY LIGHT-REBOTE |
|  | FIRE EXTINGUISHER (Existing) |

ELECTRICAL SPECIFICATIONS

THE WORK SHALL INCLUDE ALL LABOR, MATERIALS, AND SERVICES REQUIRED TO COMPLETE THE ELECTRICAL INSTALLATION. THE OWNER SHALL PAY FOR ALL NECESSARY ELECTRICAL PERMITS WHICH THE ELECTRICAL CONTRACTOR SHALL SECURE.

PRIOR TO BIDDING, ELECTRICAL BIDDERS SHALL REVIEW ALL ARCHITECTURAL AND MECHANICAL PLANS, PRIOR TO BEGINNING WORK, THE SUCCESSFUL ELECTRICAL CONTRACTOR SHALL REVIEW APPROVED EQUIPMENT DRAWINGS WITH ALL OTHER MECHANICAL TRADES AND COORDINATE ALL INSTALLATION REQUIREMENTS.

ALL ELECTRICAL WORK SHALL BE INSTALLED IN ACCORDANCE WITH NFPA 70, NATIONAL ELECTRICAL CODE, 2020.

GROUNDING SHALL BE PROVIDED IN ACCORDANCE WITH THE REQUIREMENTS OF THE NATIONAL ELECTRICAL CODE, THE UTILITY COMPANY, AND ALL AUTHORITIES HAVING JURISDICTION. VOLTAGE DROP SHALL NOT EXCEED THAT OUTLINED IN THE NATIONAL ELECTRICAL CODE. EQUIPMENT GROUND CONDUCTORS SHALL BE SIZED IN ACCORDANCE WITH THE NATIONAL ELECTRICAL CODE.

ALL PANELS AND JUNCTION POINTS SHALL BE PERMANENTLY LABELED

NUMBERING OF CIRCUITS OR DRAWING IS FOR CONVENIENCE ONLY AND BEARS NO RELATION TO USE OF PARTICULAR CIRCUIT BREAKERS IN PANELBOARDS. LOADS SHALL BE BALANCED AND BREAKERS SHALL BE INSTALLED IN LOGICAL, OPERATING SEQUENCE.

FURNISH AND INSTALL PULL BOXES, HANG HOLES, JUNCTION BOXES, ETC. REQUIRED TO PROPERLY ACCESS ALL ELECTRICAL CONNECTIONS. 13. MINIMUM WIRE SHALL BE "THIN" 12 COPPER AND 1/4" INCH MINIMUM CONDUIT CONNECTIONS. 14. "NUT" OR "W" IS ACCEPTABLE WHERE APPROVED BY THE NATIONAL ELECTRICAL CODE AND LOCAL GOVERNING AUTHORITIES FOR INTERIOR WIRING. WHERE BRANCH WIRING IS EXTERIOR, SEA-LITE MAY BE USED.

ALL OUTSIDE WIRING SHALL BE RUN IN SCHEDULE 80 PVC CONDUIT EXCEPT AS NOTED

ALL CONDUIT ENTERING THE BUILDING UNDERGROUND SHALL BE SLEEVED AND CAULKED TO PREVENT ANY GASES FROM ENTERING THE BUILDING.

ALL ELECTRICAL DEVICES SHALL BE APPROVED BY A RECOGNIZED TESTING LABORATORY AND SHALL BEAR LABEL OF THE SAME.

ALL EXTERIOR RECEPTACLES SHALL BE WEATHERPROOF AND SHALL HAVE GROUND FAULT PROTECTION RACEWAYS SEALS SHALL BE PROVIDED AT ALL EXTERIOR EQUIPMENT PER NEC 300.5(g) FPN PROVIDE CLEARANCES FOR ALL ELECTRICAL EQUIPMENT & DEVICES AS PER NEC 110. 19.

HOLBERG LLC
H I T E C T

178 SOUTH LAKESIDE DRIVE EAST * MEDFORD, NEW JERSEY 08055
TELE: (609) 923-3423 Email: RLHrktect@gmail.com

COPYRIGHT © 2025
RANDALL HOLBERG LLC
ARCHITECT
ALL RIGHTS RESERVED.


PROPOSED FOYER RENOVATION & ACCESSIBILITY UPGRADES FOR CROSSBRIDGE COMMUNITY CHURCH 11 GRISCOM ROAD * WEST DEPTFORD, NJ 08096 B-356A L-1&1A			
ELECTRICAL POWER & LIGHTING PLANS			
Drawn By:	RLH	Date:	05/23/2025
		Scale:	1/8" = 1'-0"
Checked By:	RLH	Revised:	05/27/2025
		Project No.:	23-37

E-1.0


Drawing No

RLH NJ REG. 10848


- FIRE PROTECTION SYMBOLS.
- Smoke Detector (Existing re-installed)
 - Smoke Detector (New)
 - HORN/STROBE (Replaces existing bells)
 - STROBE ALARM (New)
 - PULL STATION (Existing re-installed)
 - PULL STATION (New)

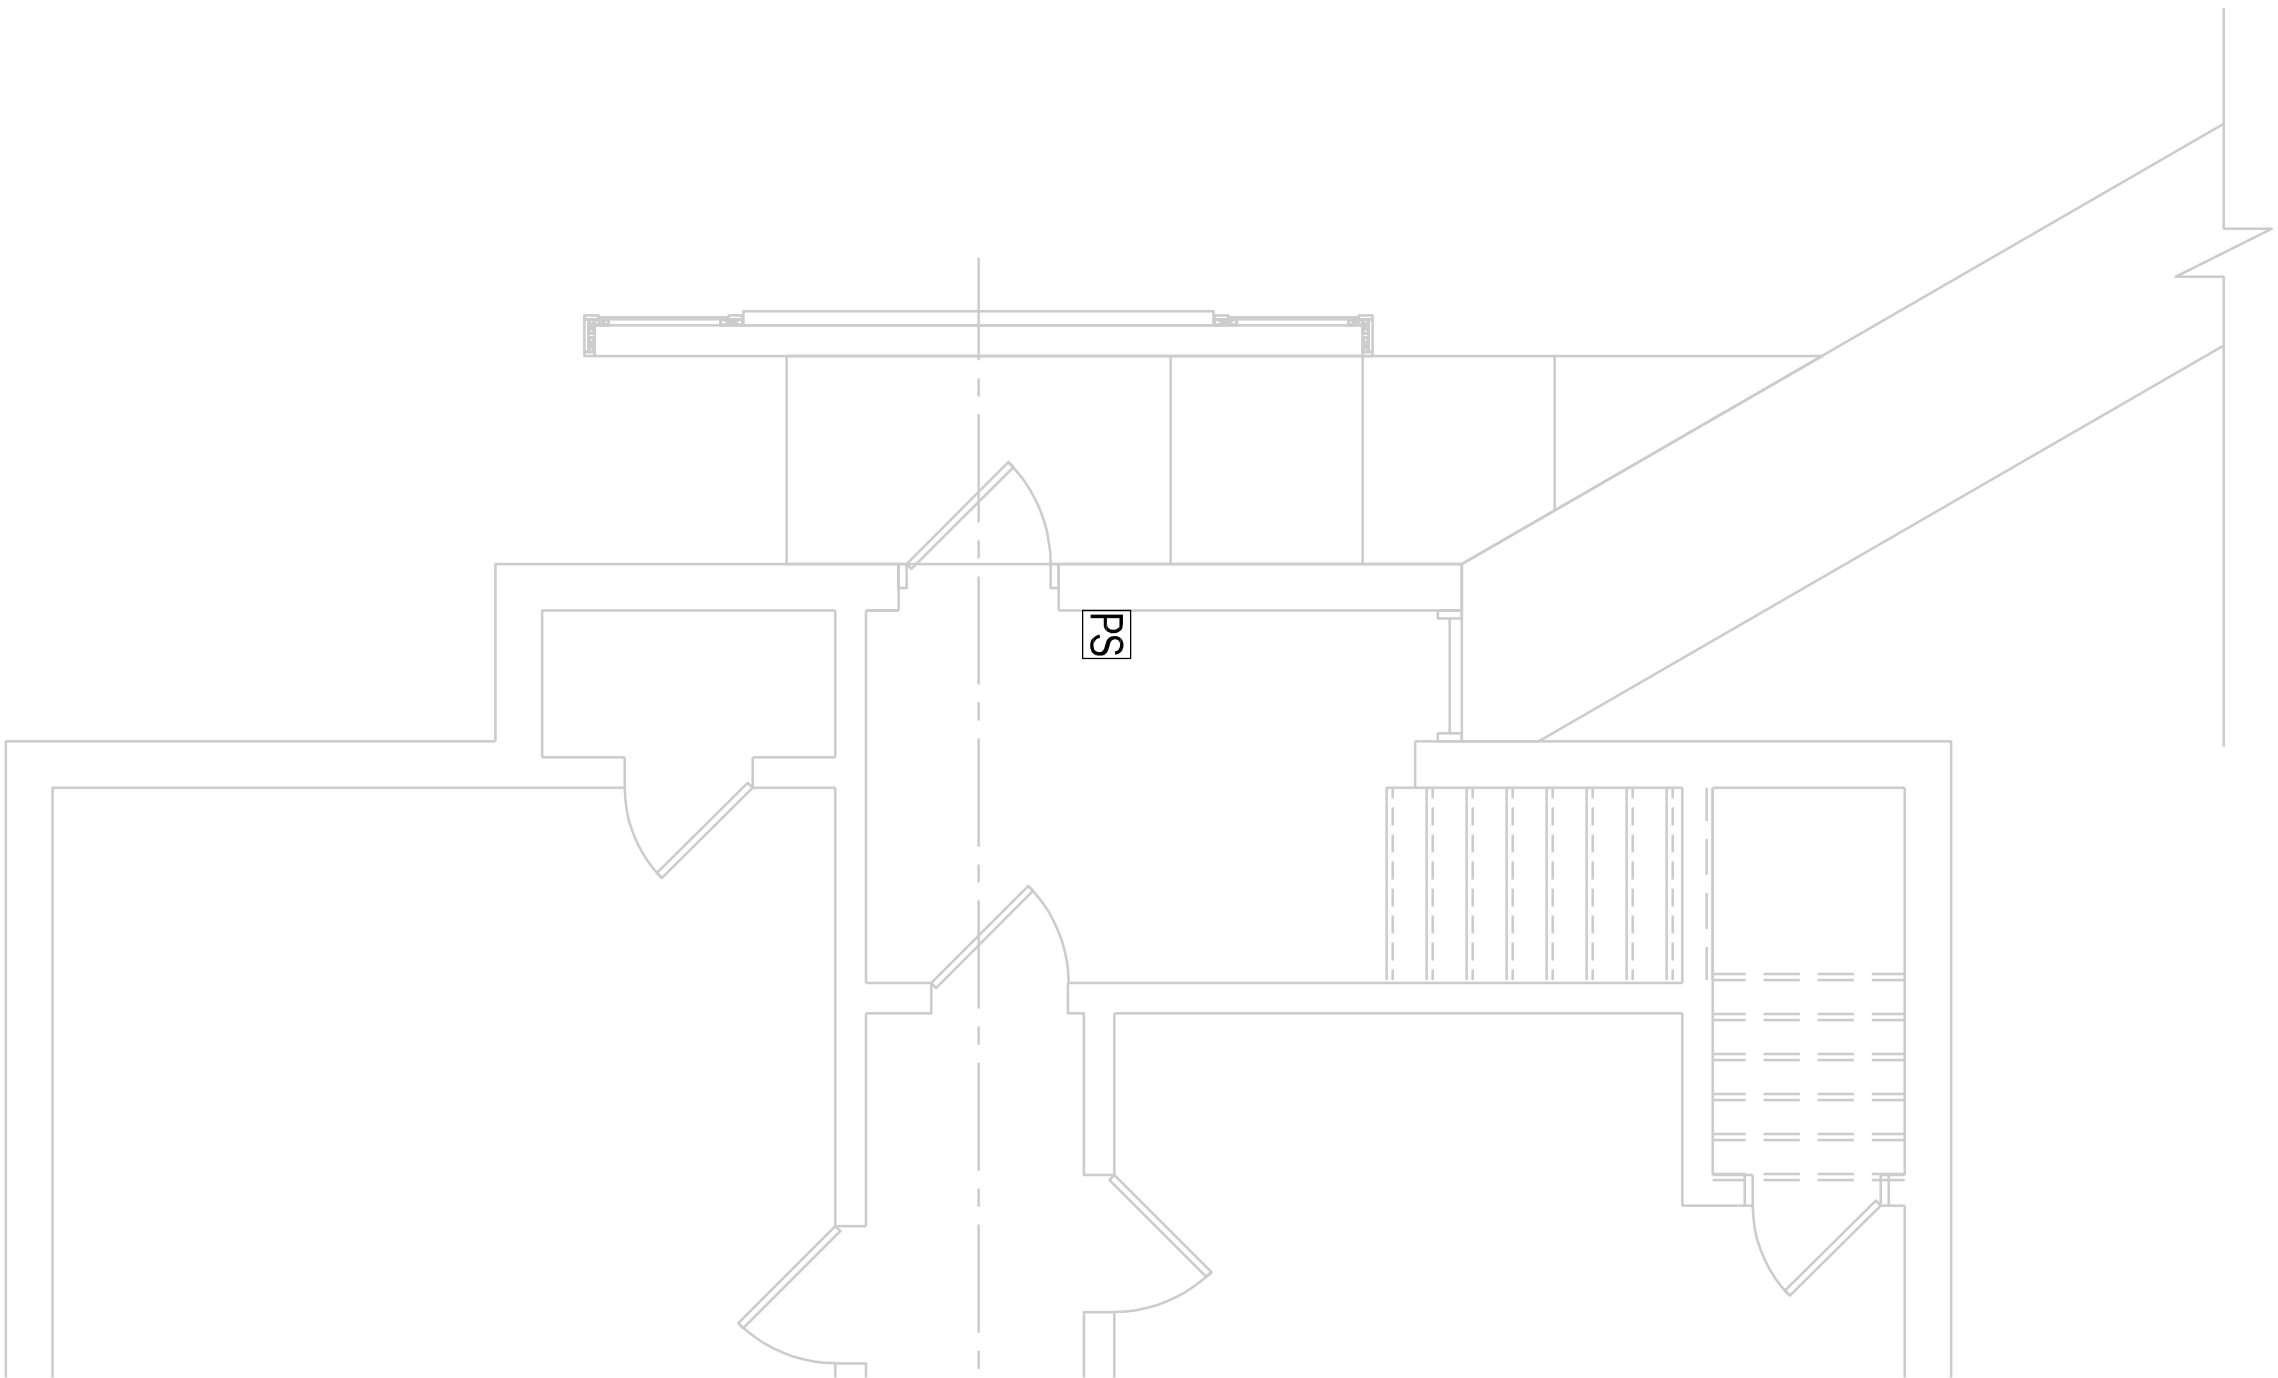


3 FIRE PROTECTION PLAN-BASEMENT
FP-1.0 1/4" = 1'-0"

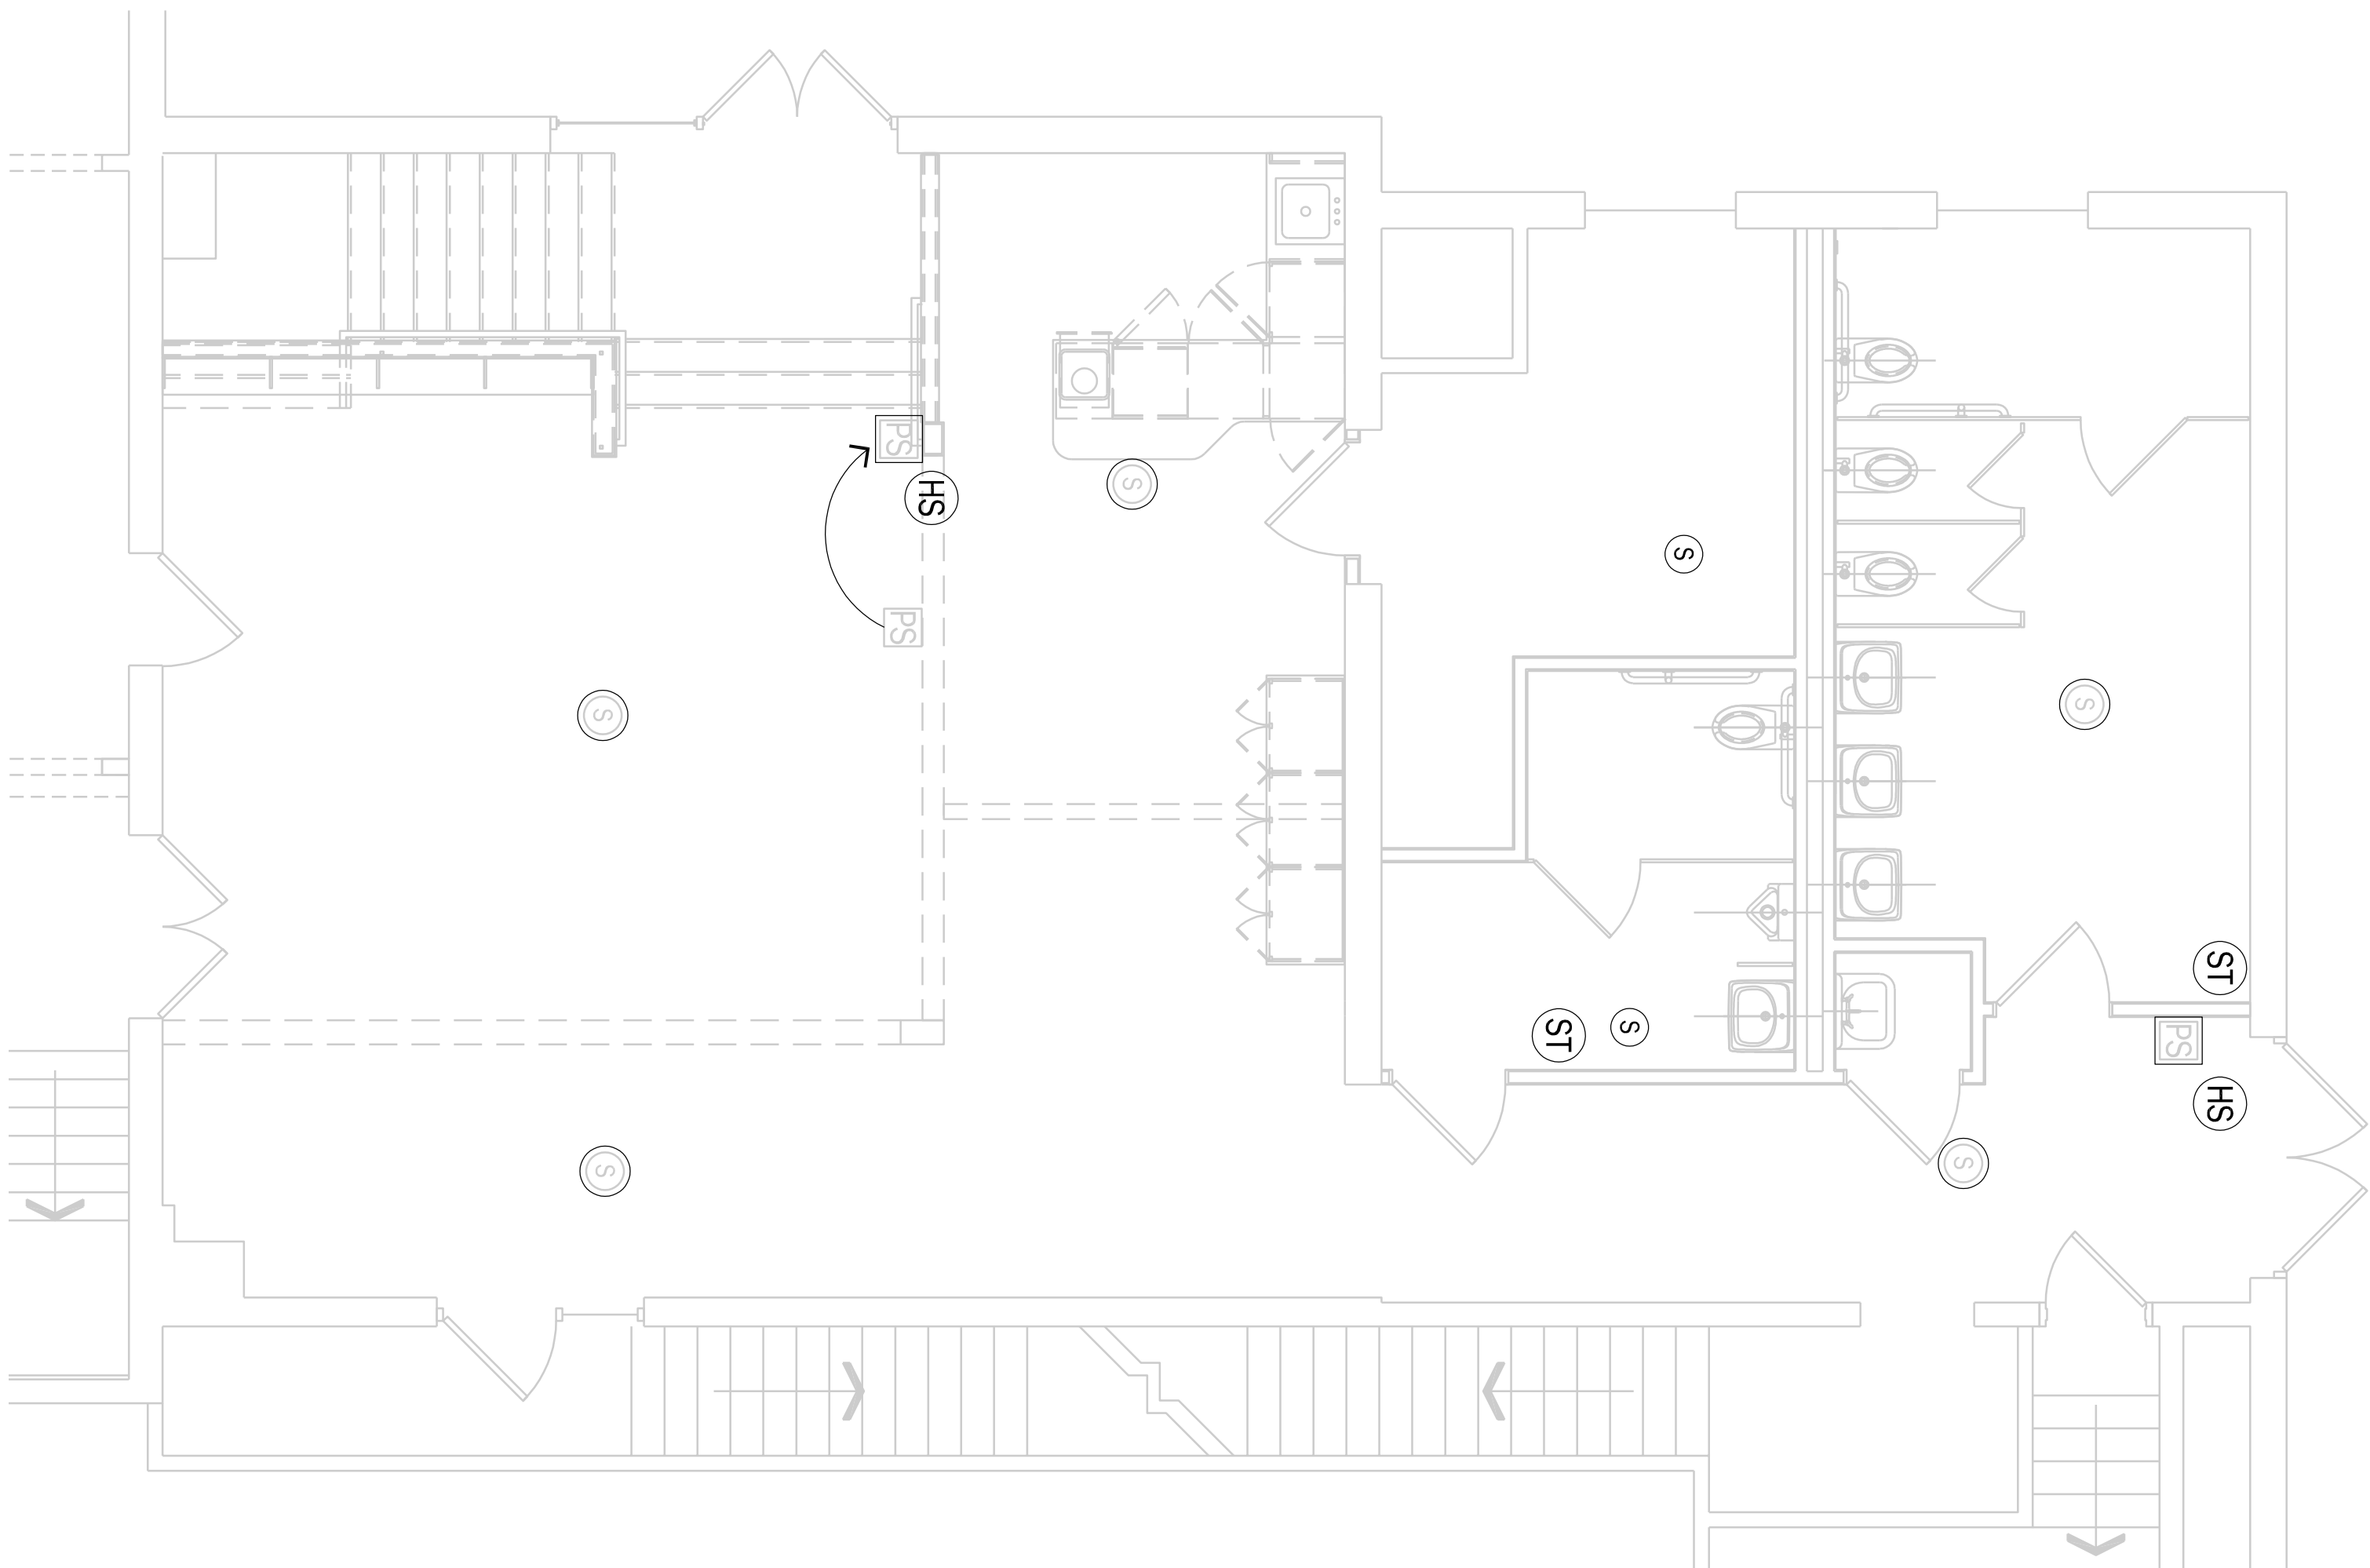

2 FIRE PROTECTION PLAN-FOYER & BATHROOMS
FP-1.0 1/4" = 1'-0"

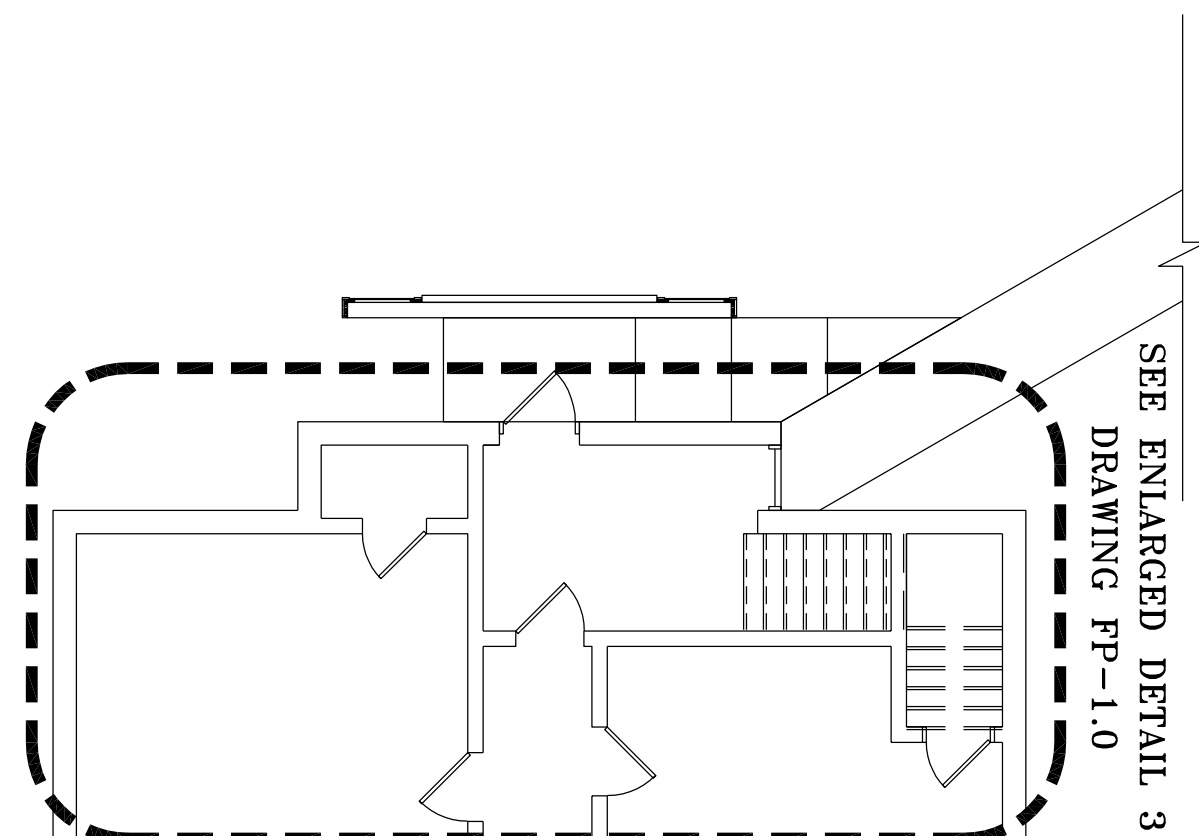

SEE ENLARGED DETAIL 3
DRAWING FP-1.0

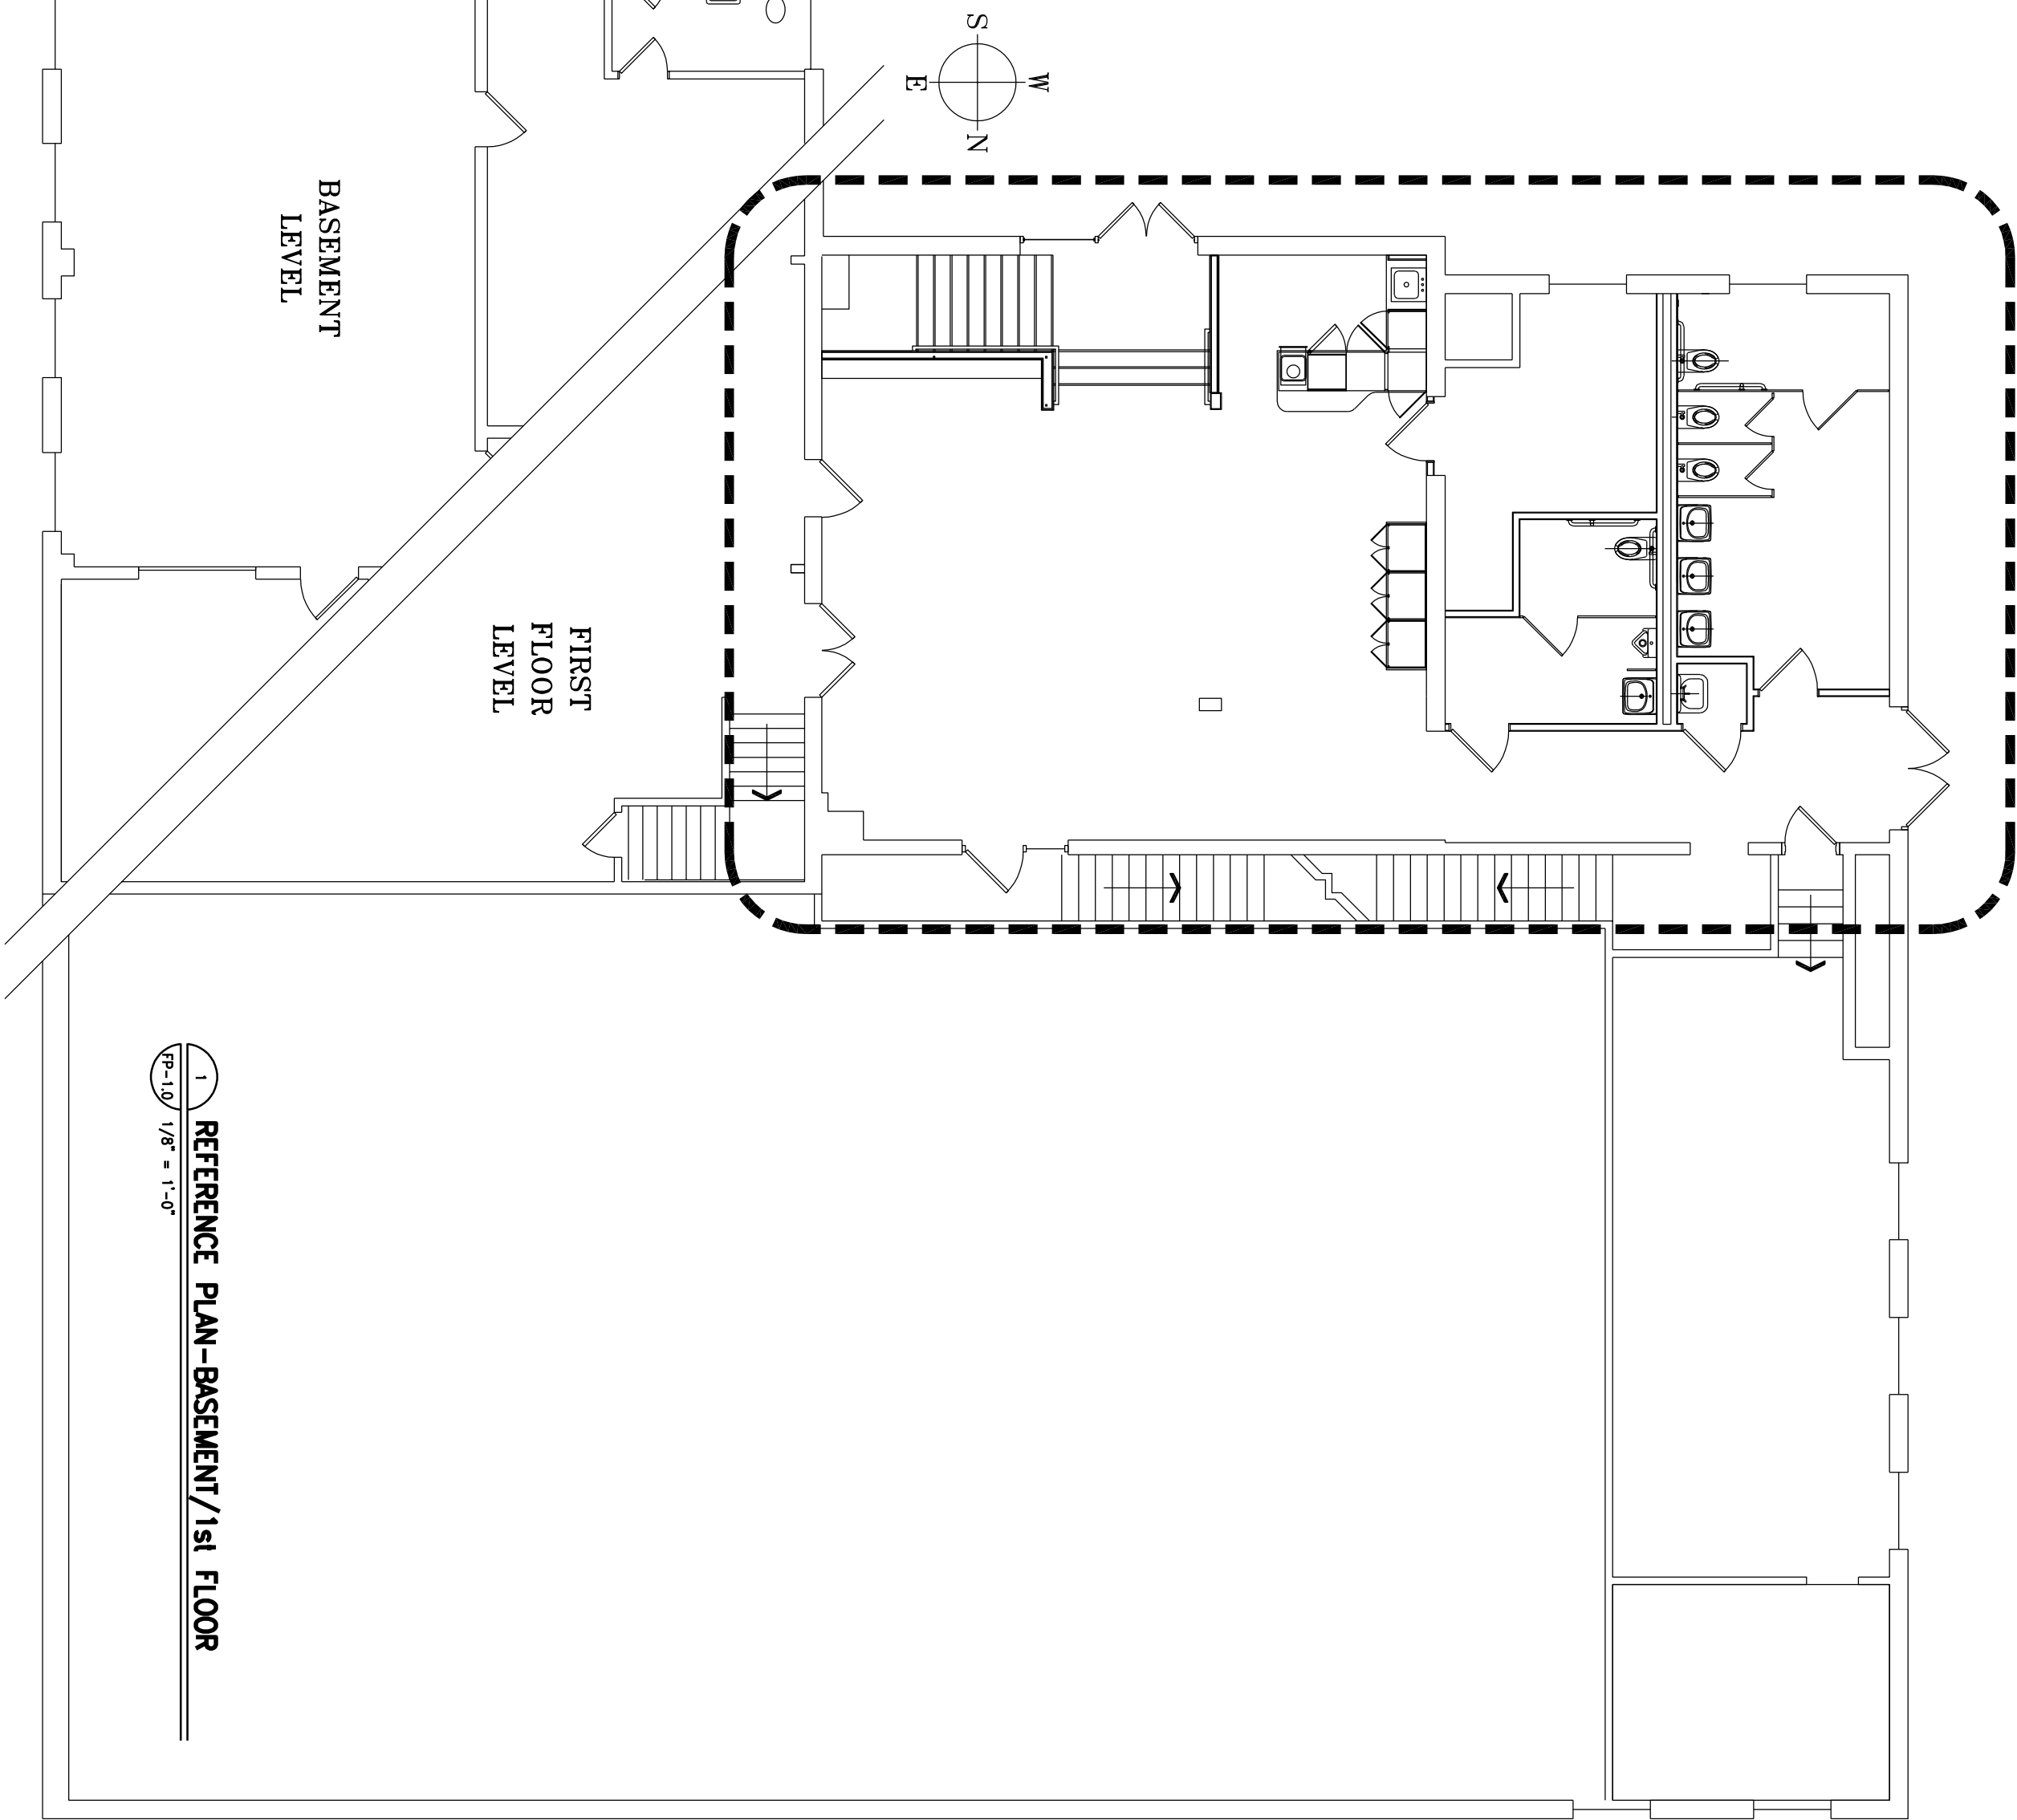

SEE ENLARGED DETAIL 2
DRAWING FP-1.0

1 REFERENCE PLAN-BASEMENT/1st FLOOR
FP-1.0 1/8" = 1'-0"

PROPOSED FOYER RENOVATION & ACCESSIBILITY UPGRADES FOR
CROSSBRIDGE COMMUNITY CHURCH
11 GRISCOM ROAD * WEST DEPTFORD, NJ 08096 B-356A L-1&1A

FIRE PROTECTION PLANS

Drawn By:	RLH	Date:	05/23/2025	Scale:	1/8"=1'-0"
Checked By:	RLH	Revised:	07/07/2025	Project No.:	23-37

COPYRIGHT © 2025
RANDALL HOLBERG LLC
ARCHITECT
ALL RIGHTS RESERVED.

RANDALL HOLBERG LLC
ARCHITECT

178 SOUTH LAKESIDE DRIVE EAST • MEDFORD, NEW JERSEY 08055
TELE: (609) 923-3423 Email: RLHrktext@gmail.com

RLH NJ REG. 10848

FP-1.0

Drawing No.

1. CONTRACTOR SHALL BE RESPONSIBLE FOR PROVIDING ALL NECESSARY FITTINGS AS REQUIRED BY THE NATIONAL STANDARD PLUMBING CODE 2021 AND ALL APPLICABLE CODES AND REGULATIONS.
2. CONTRACTOR SHALL VERIFY AND CORRECT AS REQUIRED TO MEET ALL CODES AND REGULATIONS ANY POSSIBLE DISCREPANCIES BETWEEN TYPE AND SIZE OF CONNECTION SPECIFIED IN PLUMBING FIXTURE SCHEDULE AND FIXTURES ACTUALLY INSTALLED ON THE PROJECT.
3. ALL SANITARY STORM AND WATER SUPPLY LINES SHALL BE MARKED WITH THE SEAL OF APPROVAL OF THE NATIONAL SANITATION FOUNDATION.
4. ALL SANITARY AND STORM PIPING SHALL HAVE A MINIMUM $\frac{1}{8}$ " PER FOOT SLOPE FOR PIPE UP TO 24" PER FOOT SLOPE PIPE SIZE 3" TO 6" AND $\frac{1}{8}$ " PER FOOT SLOPE FOR PIPING 8" OR LARGER.
5. CONTRACTOR SHALL VERIFY INVERT ELEVATIONS OF SEWERS TO WHICH NEW SEWER LINES ARE TO BE CONNECTED BEFORE INSTALLATION OF NEW SEWER LINE.
6. WHERE SANITARY SEWERS LINES CROSS UNDERGROUND WATER SUPPLY LINES WITH LESS THAN 6" MINIMUM VERTICAL CLEARANCE, THE SANITARY SEWER SHALL BE CONSTRUCTED OF DUCTILE IRON (DI) TO 6" EACH SIDE OF WATER MAIN OR THE WATER LINES SHOULD BE CONSTRUCTED OF DUCTILE IRON (DI) TO 6" EACH SIDE OF SANITARY SEWER.
7. INVERT PIPING SHOWN ON FLOOR PLANS IS ONLY INDICATIVE OF GENERAL ROUTING EXCEPT FOR LOCATIONS.
8. VALVES AND FITTINGS SHALL BE OF THE SAME SIZE AS THE LINE ON WHICH THEY ARE INSTALLED.
9. CONTRACTOR SHALL COORDINATE ALL WORK WITH OTHER TRADES.
10. CONTRACTOR SHALL BE RESPONSIBLE FOR MAINTAINING FIRE RATING AND WEATHERPROOFING INTEGRITY OF ALL PILING PENETRATIONS.
11. CONTRACTOR SHALL BE RESPONSIBLE FOR PROVIDING ALL NECESSARY SUPPORTING DEVICES FOR ALL FIXTURES INCLUDED IN CONTRACT, OR HEREIN SPECIFIED OR OTHERWISE.
12. CONTRACTOR SHALL BE RESPONSIBLE FOR PROVIDING ALL NECESSARY SUPPORTING DEVICES FOR ALL WATER DRAINAGE SYSTEMS, INCLUDING DOWNSPOUTS OR DRAINAGE OF CURBS.
13. INSTALL WATER DRAINAGE SYSTEMS WITH THE FOLLOWING REQUIREMENTS OR EXCEPT AS NOTED: A. ALL WATER DRAINAGE SYSTEMS SHALL BE CONSTRUCTED OF SCHEDULE 40 BLACK STEEL PIPE PER PLUMBING AND PLUMBING INSULATION STANDARD D.P.I., WH-201, ACCEPTABLE MANUFACTURERS: SOUTHERN, ZURN, JOHNSON AND JAY R. SMITH, AND CHANGERS SHALL NOT BE CONSIDERED TIGHT TO WATER HANGER AREAS; ALL SHALL BE PLACED ON THE INTERIOR SIDE OF THE INSULATION OF THE WALL, SO THAT THE WALL INSULATION CAN BE PLACED ON THE EXTERIOR SIDE OF THE PIPING.
14. ALL PILING PENETRATING A LOAD BEARING WALL OR FOOTING MUST BE STEELED AND BRACED TO THE EXISTING STRUCTURE.
15. ALL PILING PENETRATING A ROOF SHALL BE A MINIMUM OF 10'-0" FROM ANY OUTSIDE AIR INTAKES.
16. ALL PILING THROUGH ROOF SHALL BE A MINIMUM OF 10'-0" FROM ANY OUTSIDE AIR INTAKES.
17. CONTRACTOR SHALL INSTALL DIELECTRIC UNIONS AT CONNECTIONS OF DISSIMILAR METALS.
18. ALLOW THE PLUMBING SLOPE OF THE WATER CLOSETS IN THE ACCESSIBLE TOILET ROOMS TO BE IN ACCORDANCE WITH THE NATIONAL STANDARD PLUMBING CODE.
19. ALL PILING WATERWAYS AND INSULATION REQUIREMENTS SHALL BE IN ACCORDANCE WITH THE NATIONAL STANDARD PLUMBING CODE.
20. USE $\frac{1}{4}$ " TURN VALVES AT ALL PLUMBING FIXTURES AND FACET SUPPLY WATER LINE.
21. INSTALL CLEAN OUTS AT CHANGE OF DIRECTION AND AT THE END OF THE WATER LINE FOR EVERY CONDENSABLE DRAIN, SANITARY DRAIN AND STORM DRAIN IN ACCORDANCE WITH THE NATIONAL STANDARD PLUMBING CODE.
22. SUPPORT HUNG FIXTURES SHOULD BE INSTALLED WITH FLOOR MOUNTED WALL HANGER SUPPORT.
23. COORDINATE WITH ARCHITECTURAL FOR PLUMBING FIXTURES EXACT LOCATIONS.
24. PROVIDE WITH ALL NECESSARY AND OPTIONAL, HARDWARE, FITTINGS, ESCUTCHEONS, ETC. TO ALL PLUMBING AND HOT WATER RETURN PIPING AND PIPES SHALL BE INSULATED WITH 1" OF INSULATION HAVING CONDUCTIVITY NOT EXCEEDING 0.27 BTU PER $in^2 \cdot h \cdot ^\circ F$ PER INTERNATIONAL ENERGY CODE TABLE 607.2.1.



TOILET	AMERICAN STANDARD AQUAL FLOWSE ENLARGED FLUSH/STRETCH TOILET 2257/201/2833.001
TOILET	ELECTRONIC SENSOR-OPERATED TOILET FLUSH VALVE 1.78 GPF 6062/121002 HARD WHEED AC POWERED
TOILET	AMERICAN STANDARD OPERATED TOILET FLUSH VALVE 1.78 GPF 6062/121002 HARD WHEED AC POWERED
URINAL	AMERICAN STANDARD WASHCROW FLOWSE UNVEFSEA URINAL 6590.001
URINAL	ELECTRONIC SENSOR-OPERATED URINAL FLUSH VALVE 1.0 GPF 6062.101 HARD WHEED AC POWERED
SINK	AMERICAN STANDARD CERAMIC WALL HUNG SINK 0556-421-020
SINK	ELECTRONIC INTEGRATED FACET WALL HUNG SINK 7057.205
SINK	6033.001/020 WHEED VALVE POWERED
SINK	AMERICAN STANDARD JACNETELL SERVICE SINK
SINK	FACET 8702 WHEED WALL MOUNT URINAL FACET W/VACUUM BREAKER AND STOP IN SHANK 8341.017/070
SINK	25L 1.2/27.0 GPM SILENT RIMMING 20 GAUGE STAINLESS STEEL 3 HOLE FACET CENTER
KITCHEN SINK	DEAN PULLEY WITH SOUND DEBENDING FACET PRISTER 6134-1444 SINK HANDLE PULL-DOWN, 3-HOLE, 1.5 GPM, CHROME FINISH, W/CHOICE, DEBENDING BRASS P/204 1-1/2"-P/48 KUT-