

LATRINE ALTERATIONS FOR:

MT HOLLY ARMORY

1670 NJ-38
MT HOLLY, NEW JERSEY 08060
DMA PROJECT NO. MH008

PROJECT INFORMATION

OWNER IN FEE:
DEPARTMENT OF MILITARY AFFAIRS
101 EGGERTS CROSSING ROAD
LAWRENCEVILLE, NJ 08648
TEL: (609) 530-6784
EMAIL: Arturo.Domingo@dma.nj.gov

CONTACT INFO:
ARTURO DOMINGO
101 EGGERTS CROSSING ROAD
LAWRENCEVILLE, NJ 08648
TEL: (609) 530-6784
EMAIL: Arturo.Domingo@dma.nj.gov

GOVERNING CODE:
NEW JERSEY UNIFORM CONSTRUCTION CODE -
REHABILITATION SUB-CODE AND
INTERNATIONAL BUILDING CODE 2021 NEW JERSEY EDITION
WHEN REFERENCED

CATEGORY:
RENOVATIONS 5:23-6.5, ALTERATIONS 5:23-6.6

SUMMARY:
ALTERATIONS TO THE EXISTING MEN'S AND WOMEN'S
LATRINES. SHOWERS AND LOCKERS ARE TO BE ADDED TO BOTH
LATRINES, INCLUDING ONE ACCESSIBLE SHOWER PER LATRINE. A
SEPARATE NEW ACCESSIBLE UNISEX TOILET ROOM WILL BE
PROVIDED. ALL NEW FLOORING, CEILING AND PLUMBING FIXTURES
WILL BE PROVIDED. ALL NEW LIGHTING WILL BE PROVIDED. AN
ENERGY RECOVERY UNIT WILL BE ADDED AND LOCATED ON
GRADE ADJACENT TO THE LATRINES. HEAT PUMPS WILL BE ADDED
TO EACH OF THE LATRINES.

SQUARE FOOTAGE:

AREA OF WORK \$75 S.F.

DESCRIPTION OF BUILDING USE

STATE SPECIFIC USE: NATIONAL GUARD READINESS CENTER
USE GROUP, NEW: BUSINESS (CO CHANGE)
CHANGE IN USE GROUP, PRESENT: BUSINESS
MIXED USE - SECONDARY USES: N/A
CONSTRUCTION CLASSIFICATION, PRESENT: IIIB SPRINKLERED
CONSTRUCTION CLASSIFICATION, NEW: IIIB SPRINKLERED (NO CHANGE)

BUILDING/SITE CHARACTERISTICS

NUMBER OF STORIES 1 EXISTING
HEIGHT OF STRUCTURE 22' +/-
AREA - LARGEST FLOOR 14,828 S.F. +/-
NEW BUILDING AREA 0 S.F.
VOLUME OF NEW STRUCTURE 0 CU. FT.
MAX LIVE LOAD 150 PSF
TOTAL LAND DISTURBED 0 S.F.
FLOOD HAZARD ZONE ZONE X
BASE FLOOD ELEVATION N/A
WETLANDS NO
STRUCTURAL DESIGN CRITERIA ASCE 7-16
WIND DESIGN SPEED 129 MPH

ENVIRONMENTAL:

TTI ENVIRONMENTAL
1253 NORTH CHURCH ROAD
MOORESTOWN, NJ 08057
T: (856) 840-8800
Email: scottm@ttienv.com


STRUCTURAL ENGINEERS:

KSI PROFESSIONAL ENGINEERS
P.O. BOX 628
FARMINGDALE, NJ 07727
T: (732) 938-2666
F: (732) 938-2661
Email: pcronin@ksi-pe.com



MECH/ELEC/PLUMBING ENGINEERS:

KSI CONSULTING ENGINEERS
P.O. BOX 628
FARMINGDALE, NJ 07727
T: (732) 938-2666
F: (732) 938-2661
Email: achristie@ksi-pe.com

PROJECT LOCATION

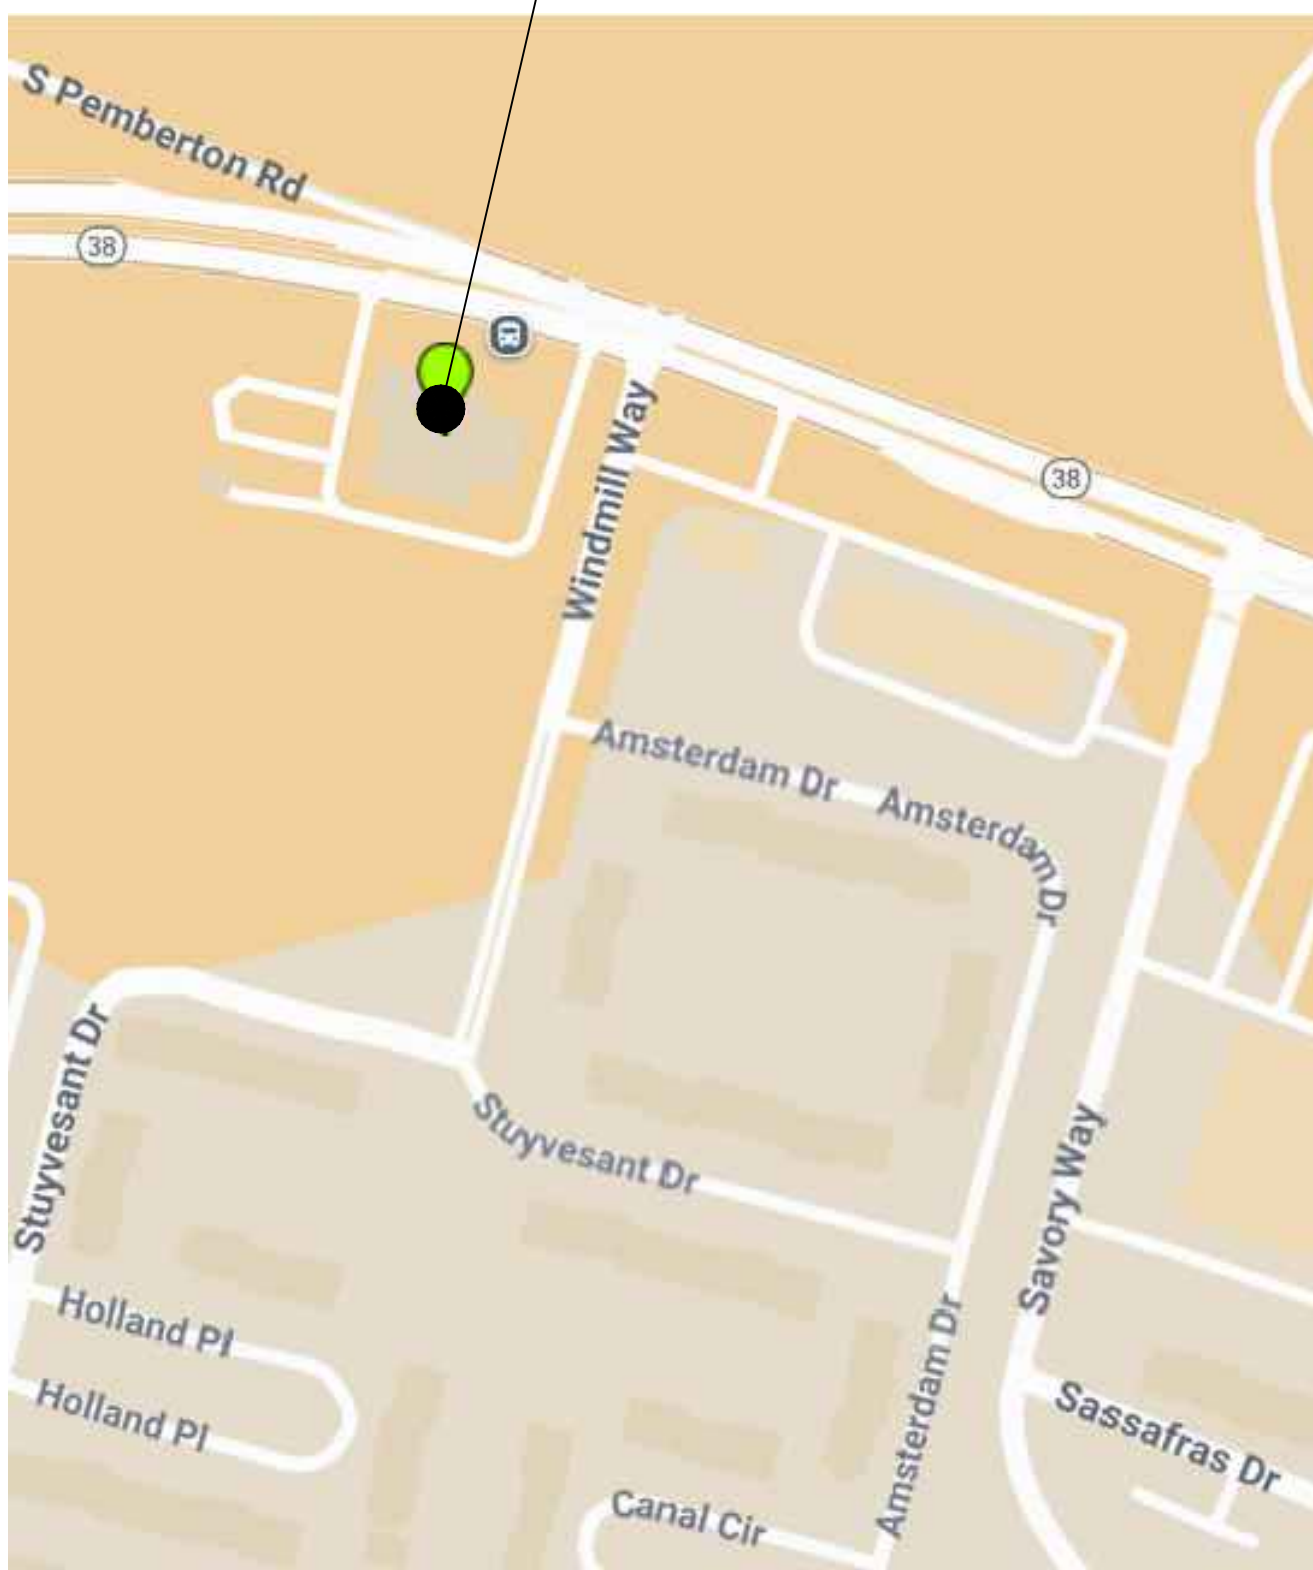

2 LOCATION MAP
N.T.S.

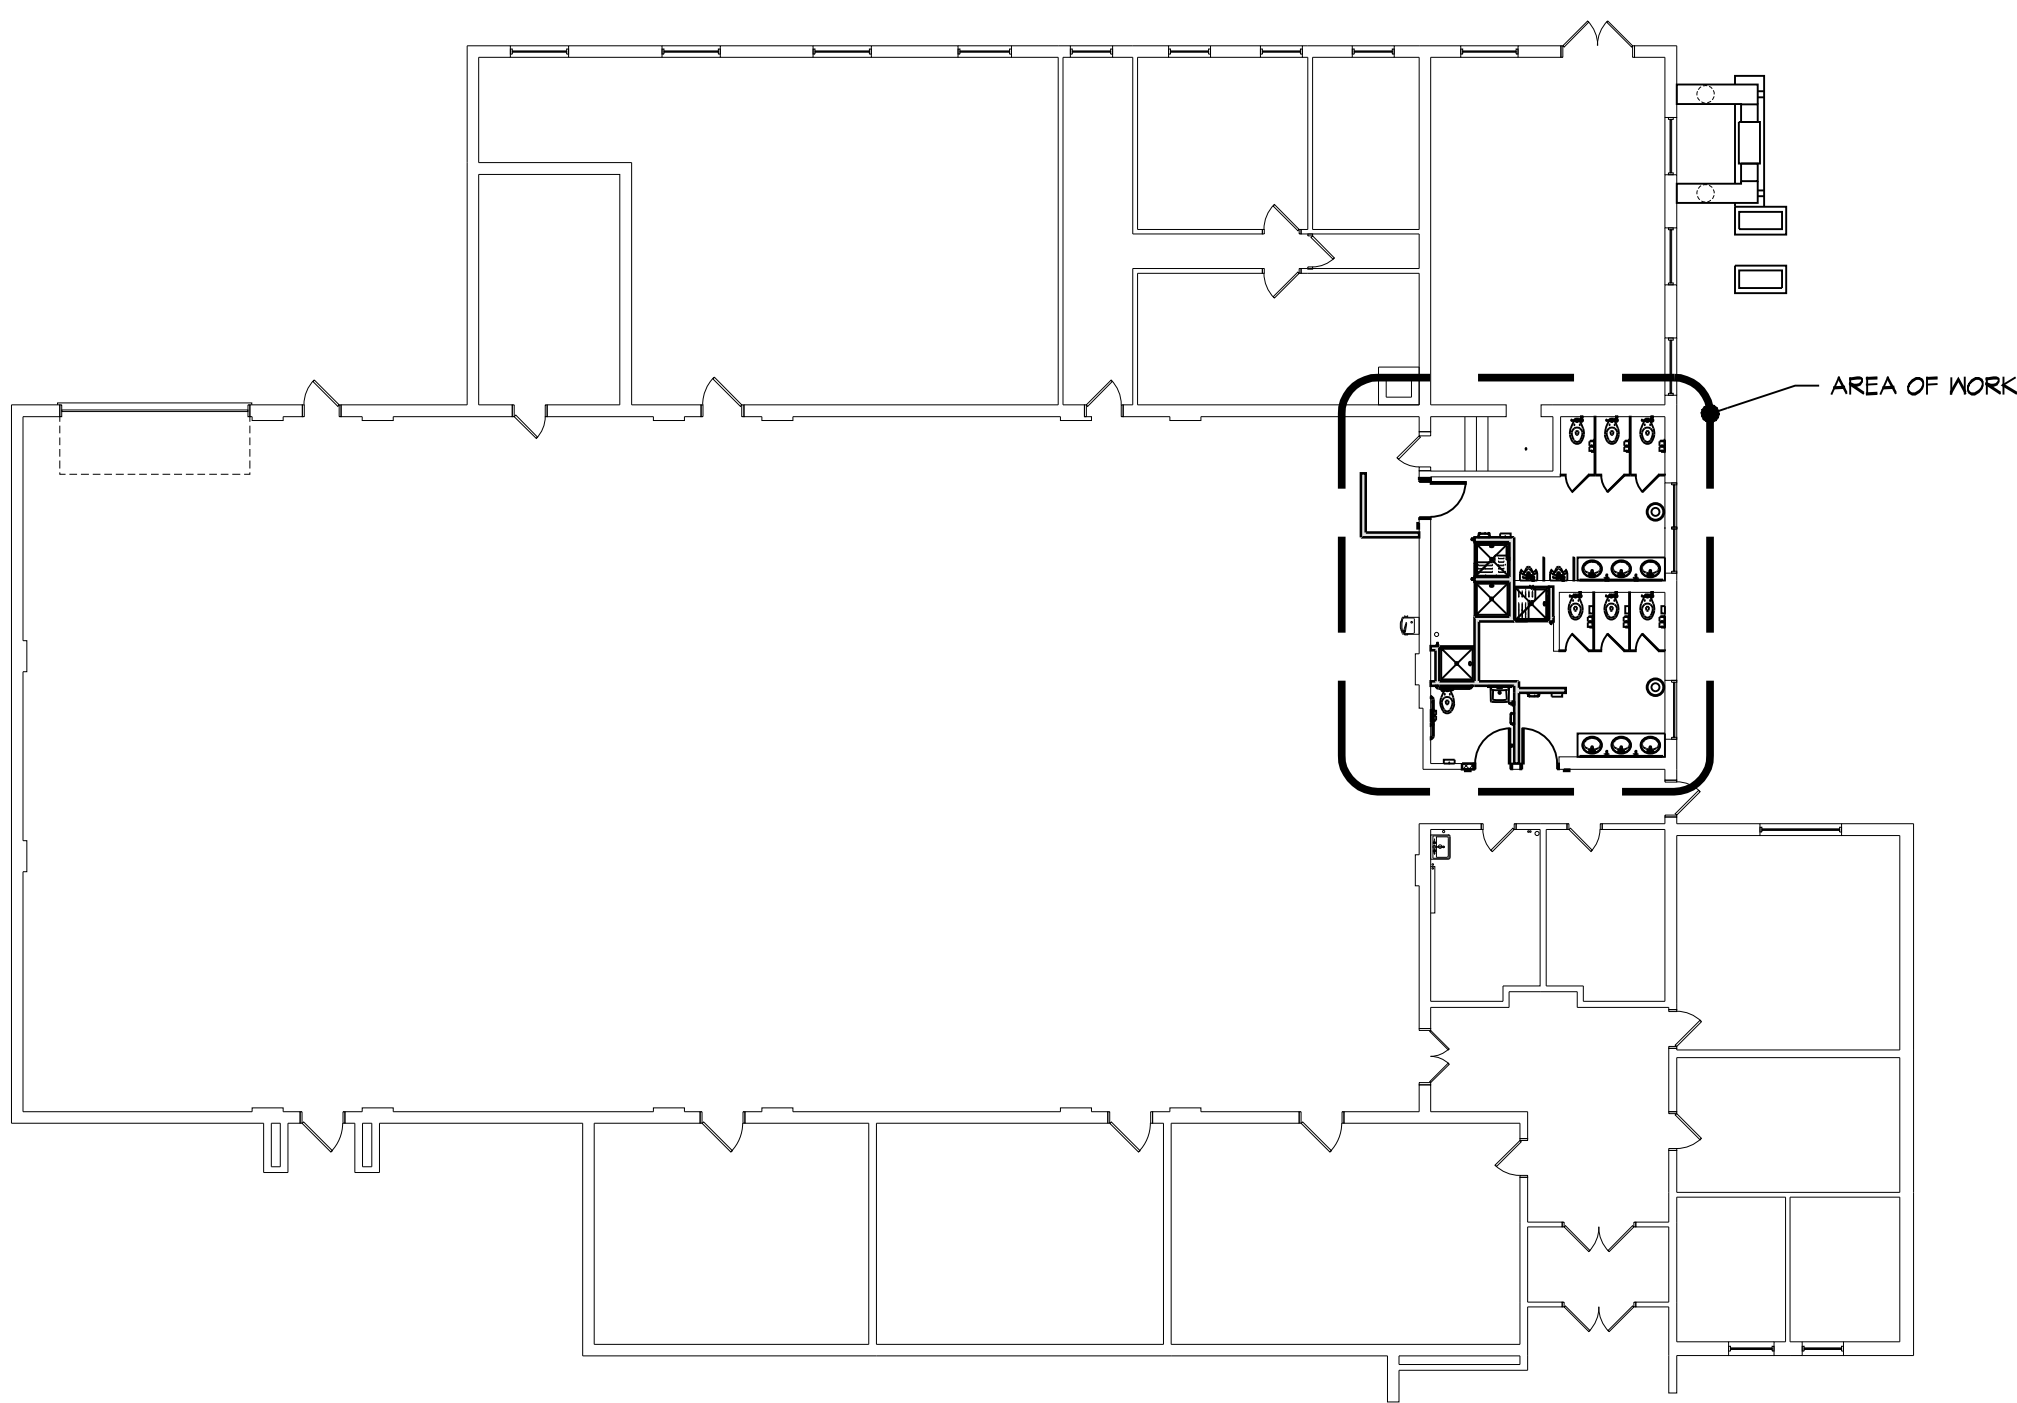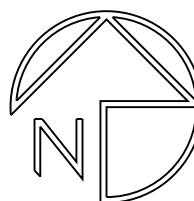


1 KEY MAP
N.T.S.

INDEX

DWG. NO.	DWG. TITLE
CS	GENERAL COVER SHEET
G-1.0	GENERAL NOTES, ABBREVIATIONS, MATERIALS, SYMBOLS & TYPICAL ACCESSIBILITY DETAILS
S-1.1	GENERAL NOTES, FLOOR PLAN & DETAILS ARCHITECTURAL
A-1.1	DEMOLITION PLAN, FLOOR PLAN & REFLECTED CEILING PL
A-1.2	FINISH/ FIXTURE PLAN & INTERIOR ELEVATIONS
A-4.0	TYPICAL PARTITION TYPES & DETAILS
A-4.2	DETAILS MECHANICAL
M-0.1	MECHANICAL GENERAL INFORMATION
M-1.1	MECHANICAL DEMOLITION & NEW WORK PART PLANS
M-2.1	MECHANICAL DETAILS
M-3.1	MECHANICAL SCHEDULES AND CONTROLS AND PIPING DIAGRAMS
E-0.1	ELECTRICAL GENERAL INFORMATION
E-1.1	ELECTRICAL DEMOLITION & NEW WORK PART PLANS
P-0.1	PLUMBING GENERAL INFORMATION
P-1.1	PLUMBING DEMOLITION & NEW WORK PART PLANS
F-1.1	FIRE PROTECTION FIRE PROTECTION NEW WORK PART PLANS




Department of Community Affairs
Construction Project Review
Project No: 9050-26
Part: 001 - Recording
Released: 5/22/2025
N.J.S.A. 52:27D-119 ET SEQ., AS AMENDED

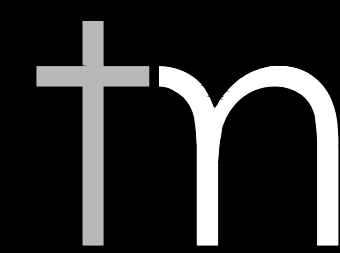

TOKARSKI + MILLEMAN
ARCHITECTS, LLC

1729 ROUTE 35
WALL, NEW JERSEY 07719
phone 732.262.0046
facsimile 732.262.0045
Email info@tm-architects.com

Michael J. Millemann, AIA

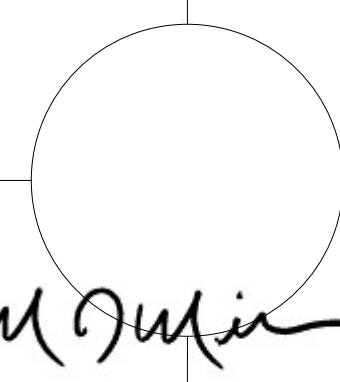

N.J. LICENSE # A1 14550
N.Y. LICENSE # 028885

CERTIFICATE OF AUTHORIZATION
No. AC33200

LATRINE ALTERATIONS FOR:
MT HOLLY ARMORY
1670 NJ-38
MT HOLLY, NEW JERSEY 08060
DMA PROJECT NO. MH008

REV.: DATE: DESCRIPTION:


COVER SHEET

PROJECT NO.: 2551 DRAWN BY: DD

DATE ISSUED: 3/30/2026

SHEET NO.:

CS

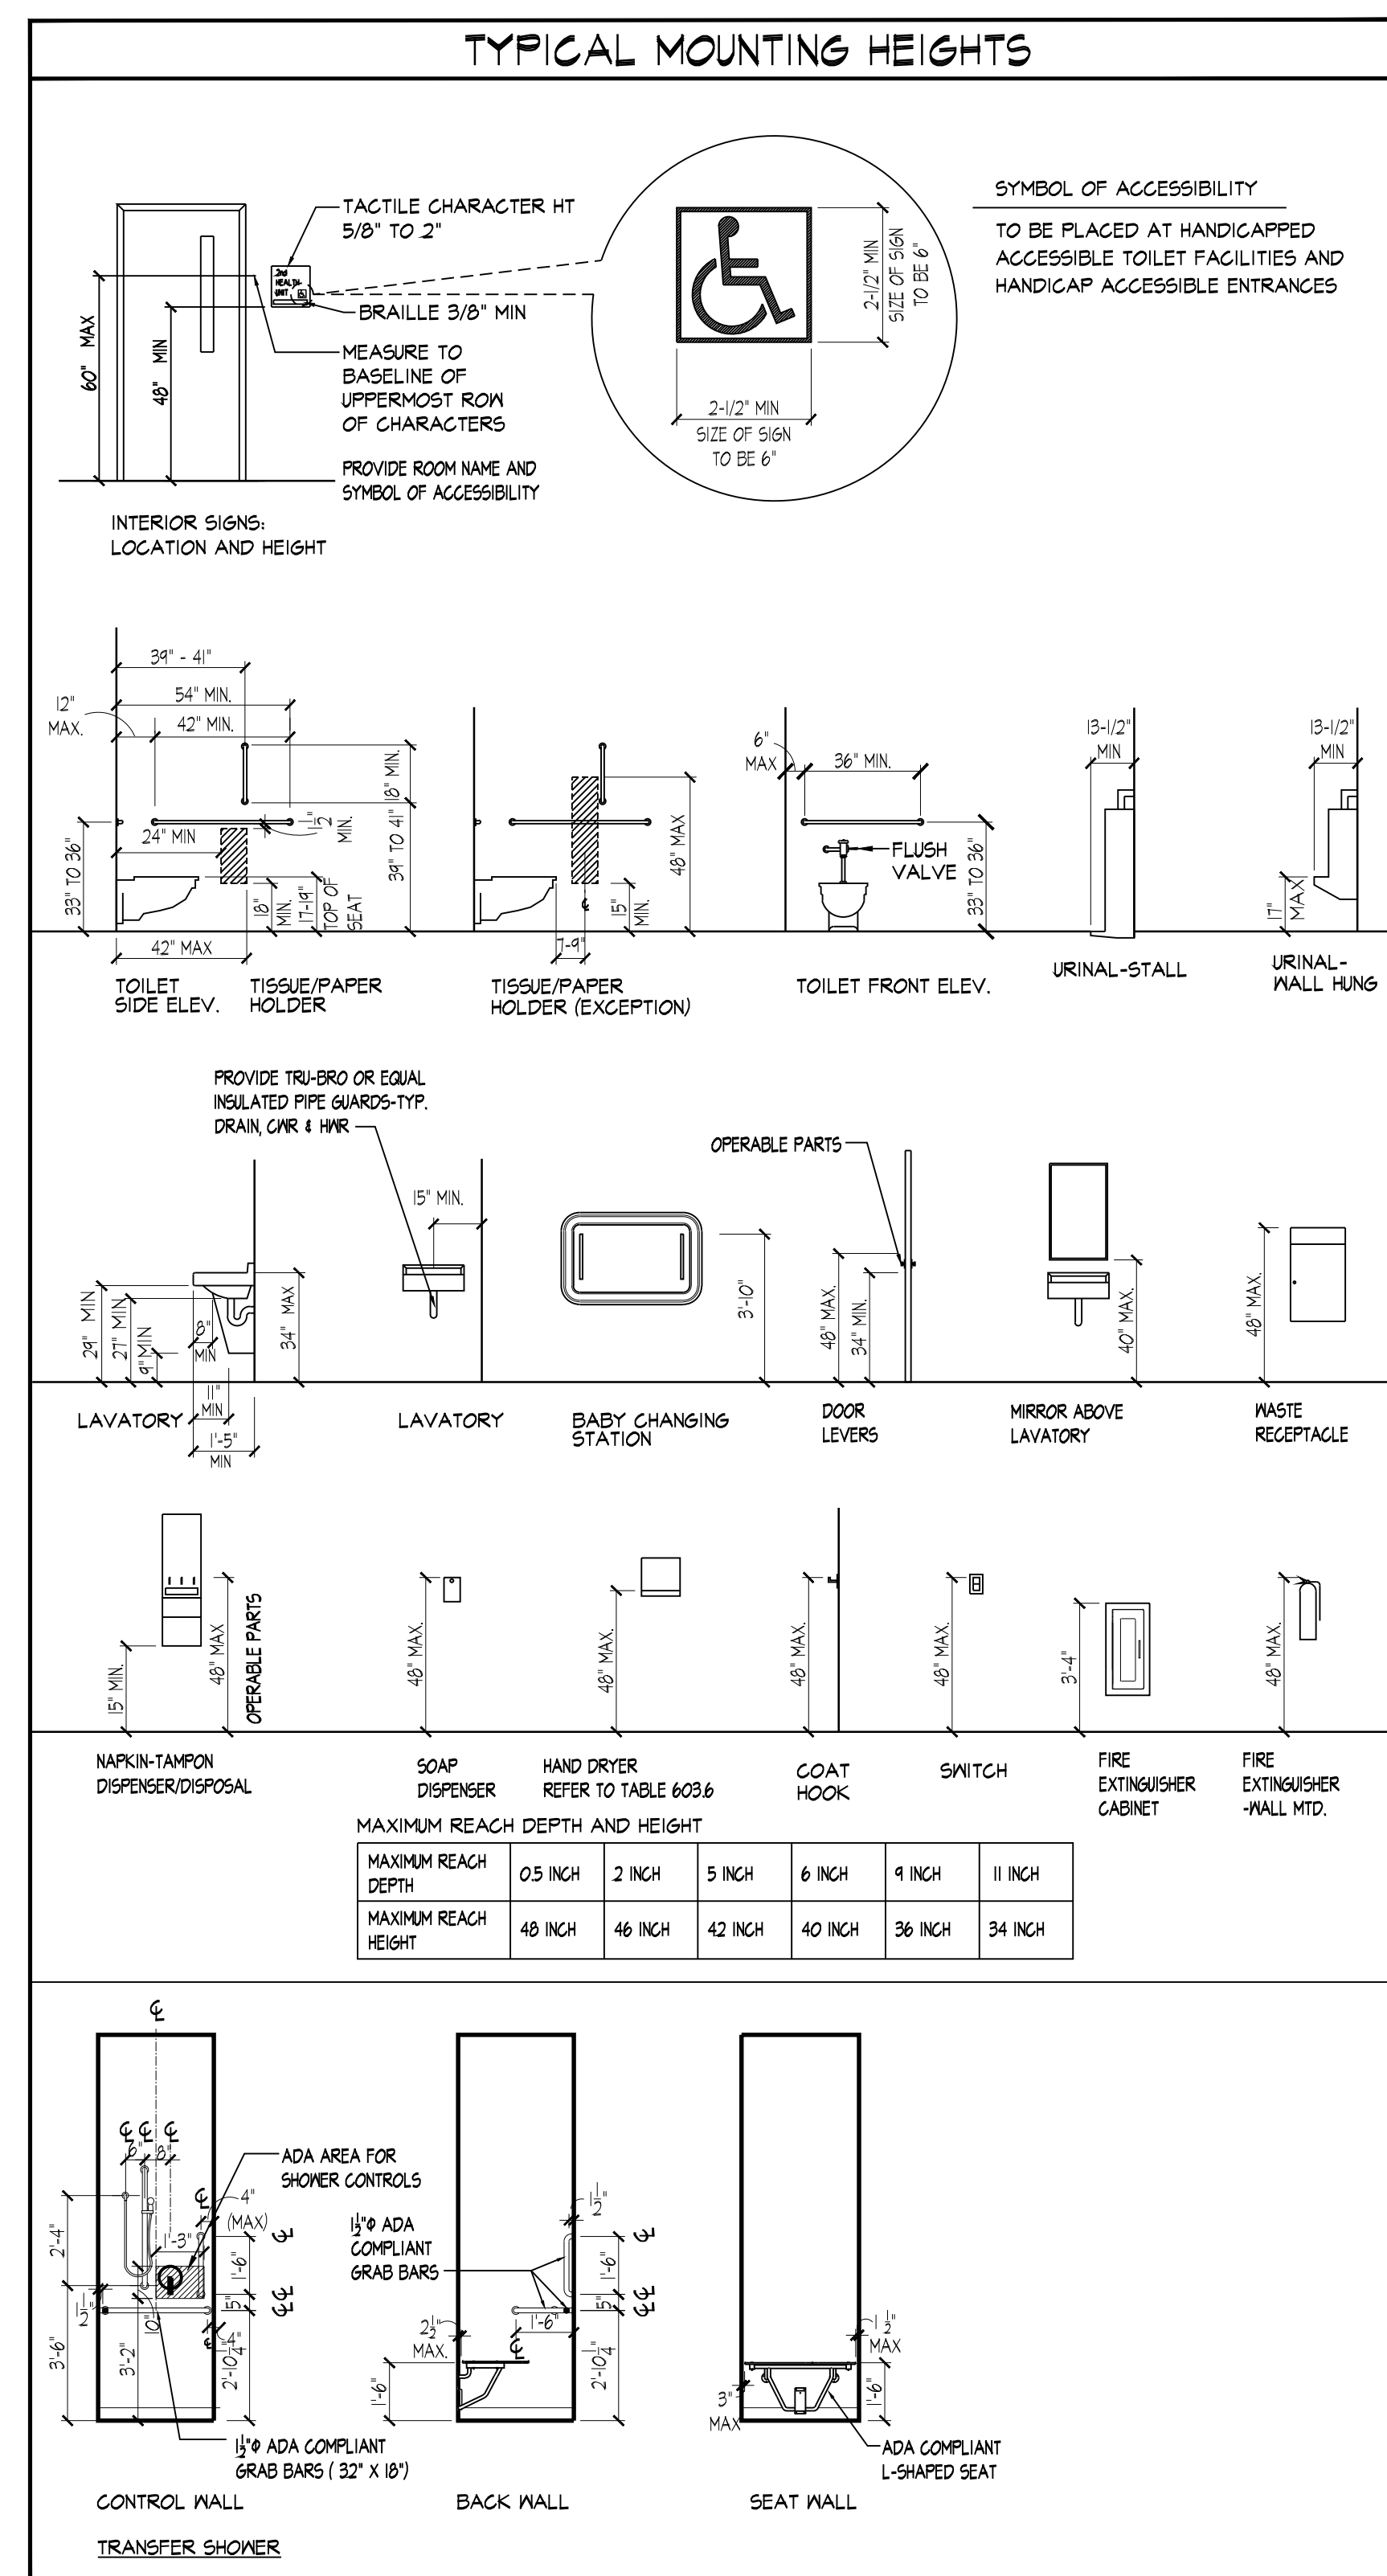

- 
Department of Community Affairs
Construction Project Review
Project No: 9050-28
Part. Ref. Interior/Bldg.
building review
Raffaele Persico
Released: 5/22/2026
I.S.A. 52:27D-119 ET SEQ., AS AMENDED



TOKARSKI + MILLEMAN
ARCHITECTS, LLC

1729 ROUTE 35
WALL, NEW JERSEY 07719

phone 732.262.0046
facsimile 732.262.0045
Email info@tm-architects.com

Michael J. Millemann, AIA
N.J. LICENSE # AI 14550
N.Y. LICENSE # 028885

CERTIFICATE OF AUTHORIZATION
No. AC33200

LATRINE ALTERATIONS FOR:
MT HOLLY ARMORY
1670 NJ-38
MT HOLLY, NEW JERSEY 08060
DMA PROJECT NO. MH008

REV.:	DATE:	DESCRIPTION:



GENERAL NOTES, ABBREVIATIONS, MATERIALS, SYMBOLS & TYPICAL ACCESSIBILITY DETAILS

PROJECT NO.: 2557 DRAWN BY: DD

DATE ISSUED: 3/30/2026


G-1.0

3/24/2026 9:53:24 AM

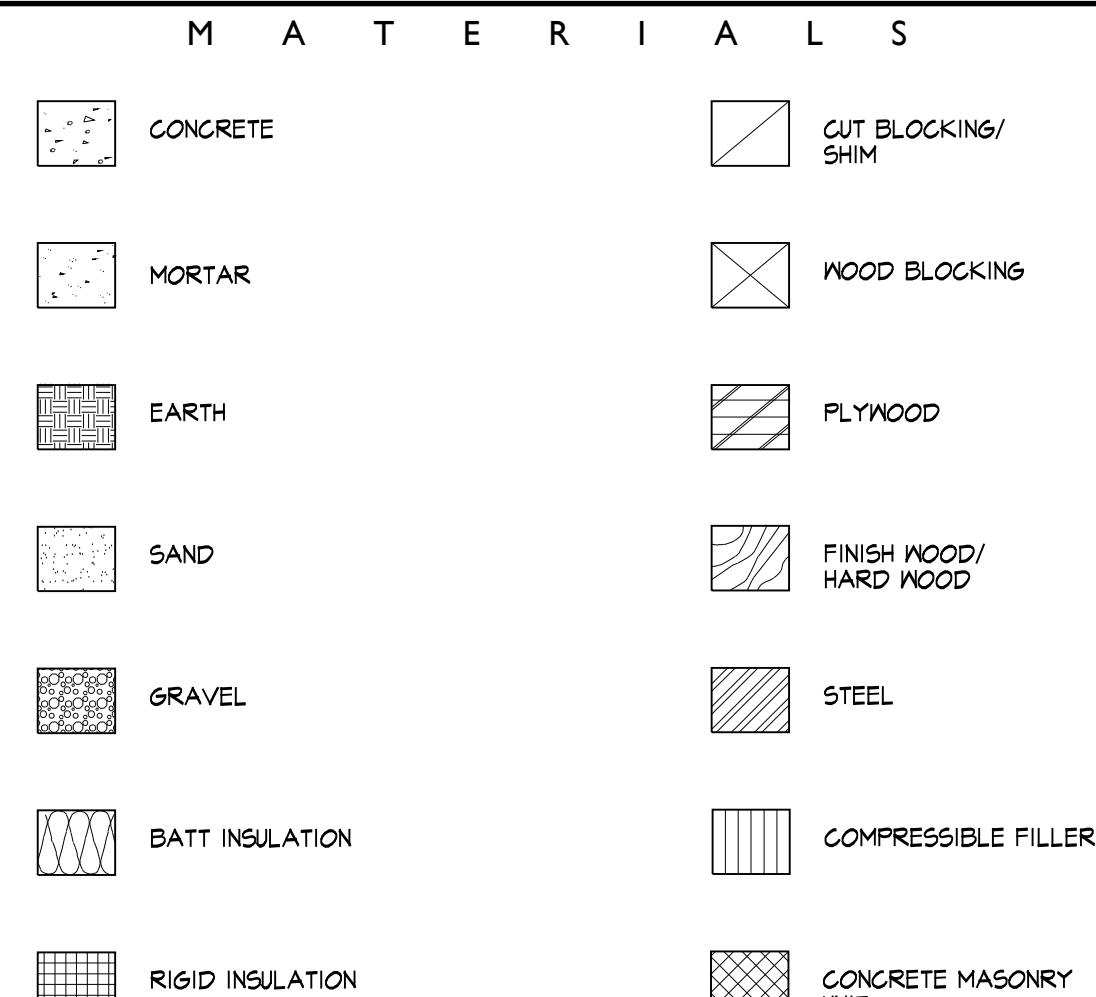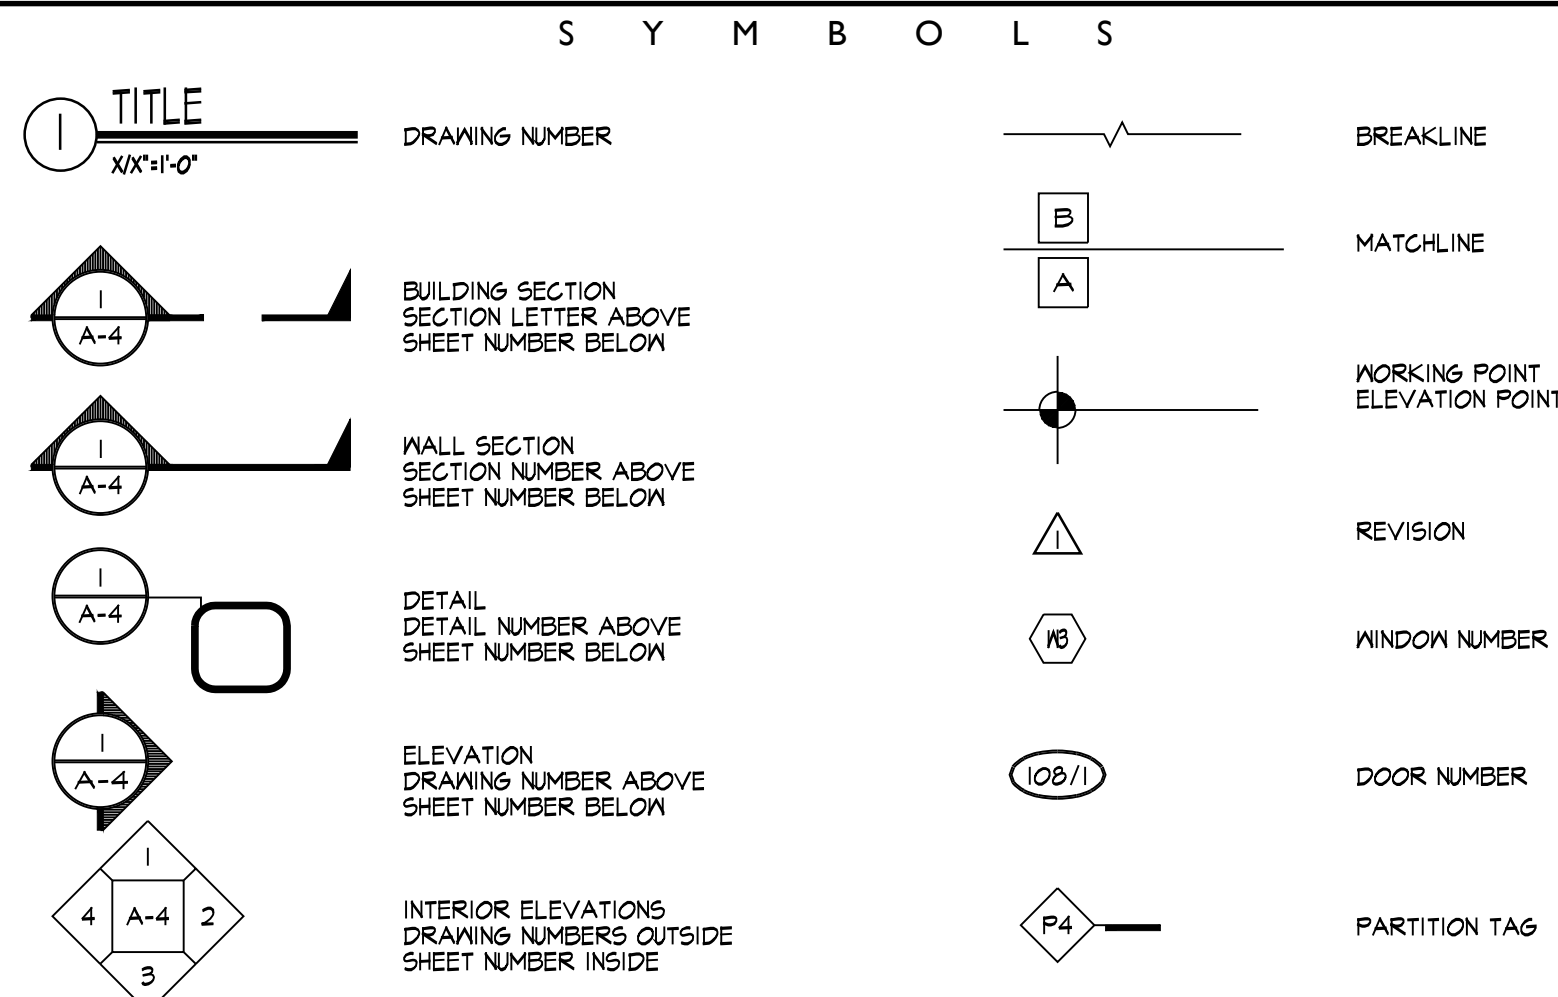

0	AND	CMU	CONCRETE MASONRY UNIT	E.S.	EACH SIDE	I.D.	INNER DIAMETER	O.D.	OUTSIDE DIAMETER	SM	SIMILAR
ADD.	ADD	C.O.	CLEAN OUT	E.X.	EXISTING	I.N. (")	INCH	O.F.D	OVERFLOW DRAIN	SPEC.	SPECIFICATION
ADJ.	ADJ.	COL.	COLUMN	E.F.	EXPANSION	INSUL.	INSULATION	OP.	OPPOSITE	SQ.	SQUARE
A.F.F.	ADDS	COMP.	COMPACTED	E.X.T.	EXTERIOR	I.N.T.	INTERIOR	PL.	PLUMBING CONTRACTOR	S.T.G.	STANDARD TRANSMISSION CLASS
AOR	ABOVE FINISH FLOOR	CONC.	CONCRETE	F.F.	FIELD CHECK	J.T.	JOINT	P.L.	POINT LOAD	SUSP.	SUSPENDED
ALT.	ALTERNATE	CONSTR.	CONSTRUCTION	F.D.	FLOOR DRAIN	J.S.T.S.	JOISTS	P.L.M.	PLUMBING	SYM.	SYMMETRICAL
APPROX.	APPROXIMATELY	CONT.	CONTINUOUS	F.F.D.	FLOOR FLOOR ELEVATION	K.D.N	KILN DRIED	P.L.Y.W.D	PLYWOOD	TREAD	TREAD
A.R.	ARCHITECT OF RECORD	C.R.S.	COURSES	F.F.N.	FINISH	K.D.N.	KNOCK DOWN	P.O.L.I.S.H.	POLISHED	T & G	TONGUE AND GROOVE
ARCH.	ARCHITECTURAL	C.T.S.	CERAMIC TILE	F.F.X.	FIXTURE	L.A.M.	LAMINATE	P.T.D.	PAINTED	TAN.	TANGENT
B.D.	BOARD	F.L.	FLOOR	F.L.	FLOOR JOIST	L.A.	LEFT HAND	P.V.C.	POLYVINYL CHLORIDE	THICK.	THICKNESS
B.D.S.	BUILDING	C.M.P.	CLEAR WHITE PINE	F.L.U.R.	FLOURESCENT	L.T.	LIGHT	R.	RISER	THRU.	THROUGH
BLK.	BLOCK	DET.	DETAIL	F.L.R.	FLOOR	L.V.T	LUXURY TILE	R.C.	ROOFING CONTRACTOR	TYP.	TYPICAL
BLKS	BLOCKING	D.F.E	DESIGN FLOOR ELEVATION	F.L.R.G.	FLOORING	MAT.	MATERIAL	R.A.D.	RADIUS	UTIL.	UTILITY
B.O.	B.O.	D.B.A.	DRAIN	F.D.	FINISH OPENING	M.A.X.	MAXIMUM	R.O.F	ROOF RAIN	UNLESS NOTED OTHERWISE	UNLESS NOTED OTHERWISE
B.O.	BOTTOM OF	D.I.F.F.	DIFFUSER	F.R.	FIRE RATED	M.C.	MASONRY CONTRACTOR	R.E.F.	REFERENCE	V.C.T.	VERIFY COMPOSITION TILE
B.R.K.	BROCK	D.I.M	DIMENSION	F.R.P.T	FIRE RETARDANT	M.E.C.H.	MECHANICAL	R.E.F.R.	REFRIGERATOR	V.I.F.	VERIFY IN FIELD
B.S.D.	BOTH SIDES	D.N.	DOWN	P.	PRESSURE TREATED	M.E.M.	MEMBRANE	R.E.F.L.E.C.T.	REFLECTED	N.E.S.T	NEST
B.S.D.	BASEBOARD	D.L.	DOWN LEADER	F.T.	FEET	M.I.N.	MINIMUM	R.E.I.N.F.	REINFORCED	N.F.	NIDE FLANGE
B.T.M.	BOTTOM	D.R.	DOOR	G.	GAUGE	M.I.S.C.	MISCELLANEOUS	R.E.Q.	REQUIRED	N.V.	NTH
B.T.M.	BETWEEN	D.R.W.S.	DRAWING	G.A.	GALVANIZED	R.H.	RIGHT HAND	R.M.S.	MASONRY OPENINGS	N.W.	WITHOUT
B.U.R.	BUILT UP ROOF	E.	EAST	G.L.	GLASS	R.O.	ROOF	R.O.G.	ROUGH OPENING	N.P.	NOOD
CAB.	CABINET	E.C.	ELECTRICAL CONTRACTOR	G.R.	GRASS	M.T.L.	METAL	R.R.	ROUGH RAFTER	N.P.	NAPO
C.C.	CENTER TO CENTER	E.L.E.V.	ELEVATION	S.P.R. B.D.	SYPHON BOARD	N.	NORTH	R.T.	ROOF TRUSS	N.P.	NAPO
C.	CENTER LINE	ELEC.	ELECTRICAL	H.D.W.	HARDWARE	N.I.C.	NOT IN CONTRACT	R.T.D.	RATED	N.P.	NAPO
C.J.	CEILING JOIST	ENCL.	ENCLOSURE	HORIZ.	HORIZONTAL	N.O. #	NUMBER	S.	SOUTH	N.P.	NAPO
C.L.	CLOSE	E.N.G.	ENGINEER OF RECORD	H.T.	HEIGHT	N.T. TO S.	NOT TO SCALE	SECT.	SECTION	N.W.F.	NEELED WIRE FABRIC
C.L.	CEILING	E.O.	EQUAL	H.V.A.C.	HEATING, VENTILATION	O.A.	OVERALL	S.H.T.	SHEET		
C.L.R.	CLEAR	EQUIP.	EQUIPMENT		AIR-CONDITIONING	O.C.	ON CENTER	SH.W.	SHOWER		

HARDWARE SETS					
SET: 1.0 DESCRIPTION: FOR GANG TOILET DOOR					
4	HINSE	TA2714 (NRP @ OUT-SWING W/ LOCK)	U526D	MK	
3	DOOR STOP	401; 404; 441CU; RIXSON 10 SERIES	U526D	RO	
	SILENCER		608	RO	
	PUSH PLATE	8300 4" X 16" CFC	630	IVE	
	PULL PLATE	8302 6" X 16" CFT 6	630	IVE	
	SURFACE CLOSER	4050A RWPA	681	LGN	
	WOP PLATE	8400 6" X 1" LDW B-C5	630	IVE	
	KICK PLATE	8400 10" X 2" LDW B-C5	630	IVE	
SET: 2.0 DESCRIPTION: 56L W/ PRIVACY LOCK; CLOSER					
4	HINSE	TA2714 (NRP @ OUT-SWING W/ LOCK)	U526D	MK	
1	PRIVACY LOCK	AU 3402LN	626	YA	
	SURFACE CLOSER	4050A RWPA	681	LGN	
	KICK PLATE	8400 10" X 2" LDW B-C5	630	IVE	
	WOP PLATE	8400 6" X 1" LDW B-C5	630	IVE	
	DOOR STOP	401; 404; 441CU; RIXSON 10 SERIES	U526D	RO	
3	SILENCER		608	RO	
MK=McKINNEY YA=TALE NO=TALE RO=ROCKWOOD PE=PEMCO IVE=IVES					

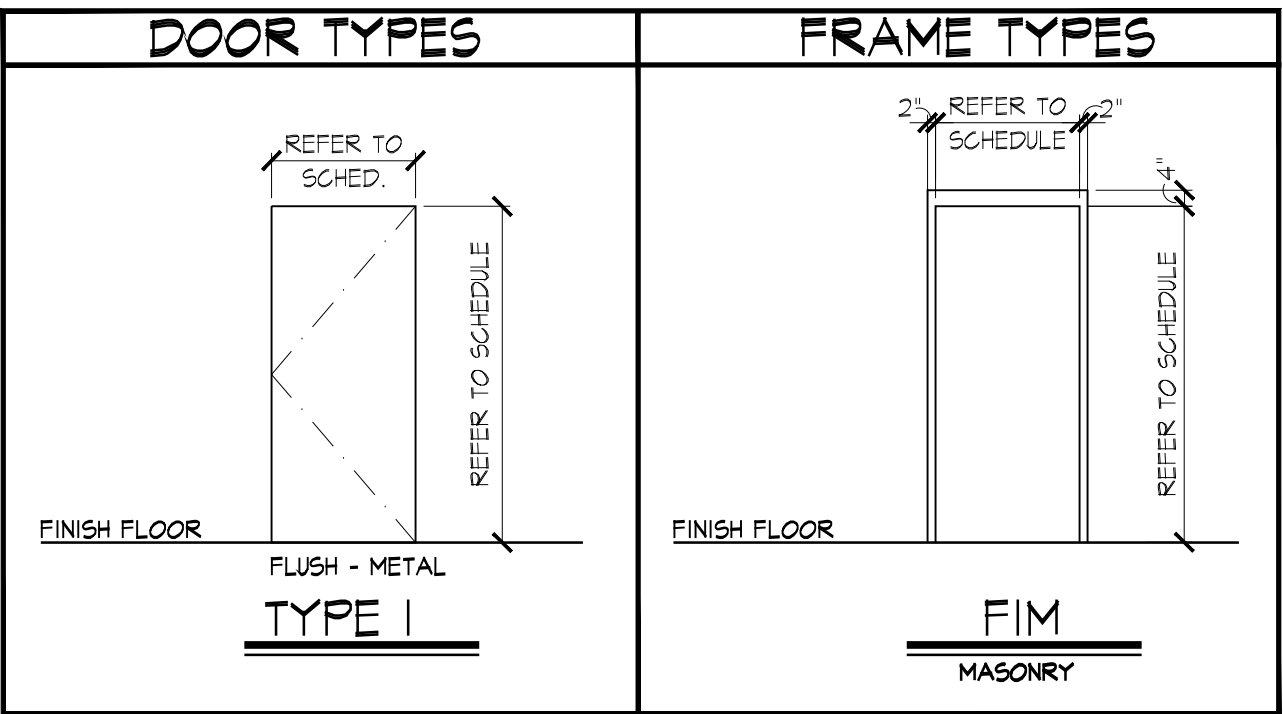

DOOR SCHEDULE											
MARK	DOOR			FRAME		DETAILS				FIRE RATING	HWN. SET
	WIDTH	HEIGHT	TYPE	MAT.	TYPE	HEAD	JAMB	SILL			
100/1	3'-0"	7'-0"	1	HM	FIM	10/A-4.2	6/A-4.2	-	-	1.0	-
100/2	3'-0"	7'-0"	1	HM	FIM	10/A-4.2	6/A-4.2	-	-	2.0	-
100/3	3'-0"	7'-0"	1	HM	FIM	10/A-4.2	6/A-4.2	-	-	1.0	-
DOOR SCHEDULE NOTES											
1. PROVIDE LEVER HANDLE HARDWARE AND CLOSERS AT ALL DOORS - FINISH TO BE BRUSHED CHROME, COMMERCIAL GRADE. COORDINATE LOCKING REQUIREMENTS WITH OWNER. ALL LOCKS NEW TO BE KEYED TO OWNERS MASTER KEY SYSTEM. ALL LEVER HARDWARE TO MEET ADA REQUIREMENTS.											
2. G.C. TO CONFIRM ALL DOOR DIMENSIONS AND QUANTITIES											
3. HOLLOW METAL FRAMES TO BE 16 GAUGE (PRIME AND PAINT)											
4. VERIFY ALL FRAME PROFILES AND WIDTHS WITH MANUFACTURER											
5. REFER TO DOOR SPECIFICATIONS FOR HARDWARE REQUIREMENTS AND SET SCHEDULE											
6. PROVIDE SILENCERS AT ALL HOLLOW METAL FRAMES											
7. PROVIDE FLOOR (440 HALF MOON BY ROCKWOOD OR EQUAL) OR WALL STOP (406 BY ROCKWOOD OR EQUAL) AT ALL INSTANCES WHERE DOOR DOES NOT CONTAIN A CLOSER, OR WHERE THE SWING IS ADJACENT (LESS THAN 4') TO PERPENDICULAR WALL.											
LEGEND											
HM	HOLLOW METAL										





CEILING LEGEND	
	2'-0"x2'-0" LED RECESSED LIGHT FIXTURE. REFER TO ELECTRICAL DWGS.
	2'-0"x4'-0" LED RECESSED LIGHT FIXTURE. REFER TO ELECTRICAL DWGS.
	1'-0"x4'-0" LED RECESSED LIGHT FIXTURE. REFER TO ELECTRICAL DWGS.
	LED HIGH OUTPUT DOWNLIGHT FIXTURE. REFER TO ELECTRICAL DWGS.
	RECESSED HIGH-HAT LIGHT FIXTURE. REFER TO ELECTRICAL DWGS.
	MECHANICAL RETURN DIFFUSER. REFER TO MECHANICAL DRAWINGS
	MECHANICAL SUPPLY DIFFUSER. REFER TO MECHANICAL DRAWINGS
	2x2 LAY-IN ELECTRIC CEILING HEATERS. REFER TO MECHANICAL DWGS.
	EXHAUST FAN. REFER TO MECHANICAL DRAWINGS
	SUSPENDED A.C.T. CEILING SYSTEM
	CEILING HEIGHT A.F.F.
	5/8" GYP. BD. SUSPENDED CEILING SYSTEM
	CEILING TYPE, RE. FINISHED SCHEDULE


REFLECTED CEILING NOTES	
1.	ALL DIMENSIONS ARE TO FACE OF FINISH UNLESS NOTED OTHERWISE
2.	ALL LIGHTS ARE TO BE CENTERED WITHIN ROOMS UNLESS NOTED OTHERWISE

GENERAL DEMO NOTES	
1.	VERIFY ALL EXISTING CONDITIONS IN FIELD PRIOR TO DEMOLITION.
2.	CONTRACTOR TO PROVIDE TEMPORARY SUPPORT FOR ALL STRUCTURAL BEARING MEMBERS PRIOR TO DEMOLITION.
3.	CONTRACTOR TO NOTIFY ARCHITECT IF EXISTING CONDITIONS VARY FROM DRAWINGS.
4.	PATCH AND REPAIR CONSTRUCTION ADJACENT TO DEMOLITION WITH MATERIALS AND FINISHES TO MATCH (AS REQUIRED).
5.	REFER TO MEP DRAWINGS FOR ADDITIONAL ITEMS TO BE DEMOLISHED.


KEYED DEMO NOTES	
1	REMOVE EXISTING DOOR IN ITS ENTIRETY. PATCH AND REPAIR ADJ. SURFACES AS REQ'D (TYP)
2	REMOVE EXISTING PLUMBING FIXTURES. CAP ABANDONED LINES. PATCH AND REPAIR ADJ. SURFACES AS REQ'D (TYP)
3	REMOVE EXISTING TOILET PARTITIONS IN THEIR ENTIRETY. PATCH AND REPAIR ADJ. SURFACES AS REQ'D (TYP)
4	REMOVE EXISTING FIN TUBE HEATER IN ITS ENTIRETY. PATCH AND REPAIR ADJ. SURFACES AS REQ'D (TYP)
5	REMOVE EXISTING WALL IN ITS ENTIRETY. PATCH AND REPAIR ADJ. SURFACES AS REQ'D (TYP)
6	REMOVE EXISTING WALL FOR INSTALLATION IF NEW DOOR. PATCH AND REPAIR ADJ. SURFACES AS REQ'D (TYP)
7	REMOVE EXISTING GRAB BARS IN THEIR ENTIRETY. PATCH AND REPAIR ADJ. SURFACES AS REQ'D (TYP)
8	REMOVE EXISTING GYPSUM BOARD CEILINGS IN THEIR ENTIRETY. PATCH AND REPAIR ADJ. SURFACES AS REQ'D (TYP)
9	REMOVE TOP LAYER OF EXISTING SLAB IN ORDER TO HAVE A FLUSH ADA SHOWER BASE THAT WILL PITCH TO THE NEW DRAIN. PATCH AND REPAIR ADJ. SURFACES AS REQ'D (TYP)

WALL LEGEND	
	EXISTING WALL TO REMAIN
	EXISTING WALL TO BE REMOVED
	NEW WALL
	EXISTING DOOR TO REMAIN
	EXISTING DOOR TO BE REMOVED
	NEW DOOR

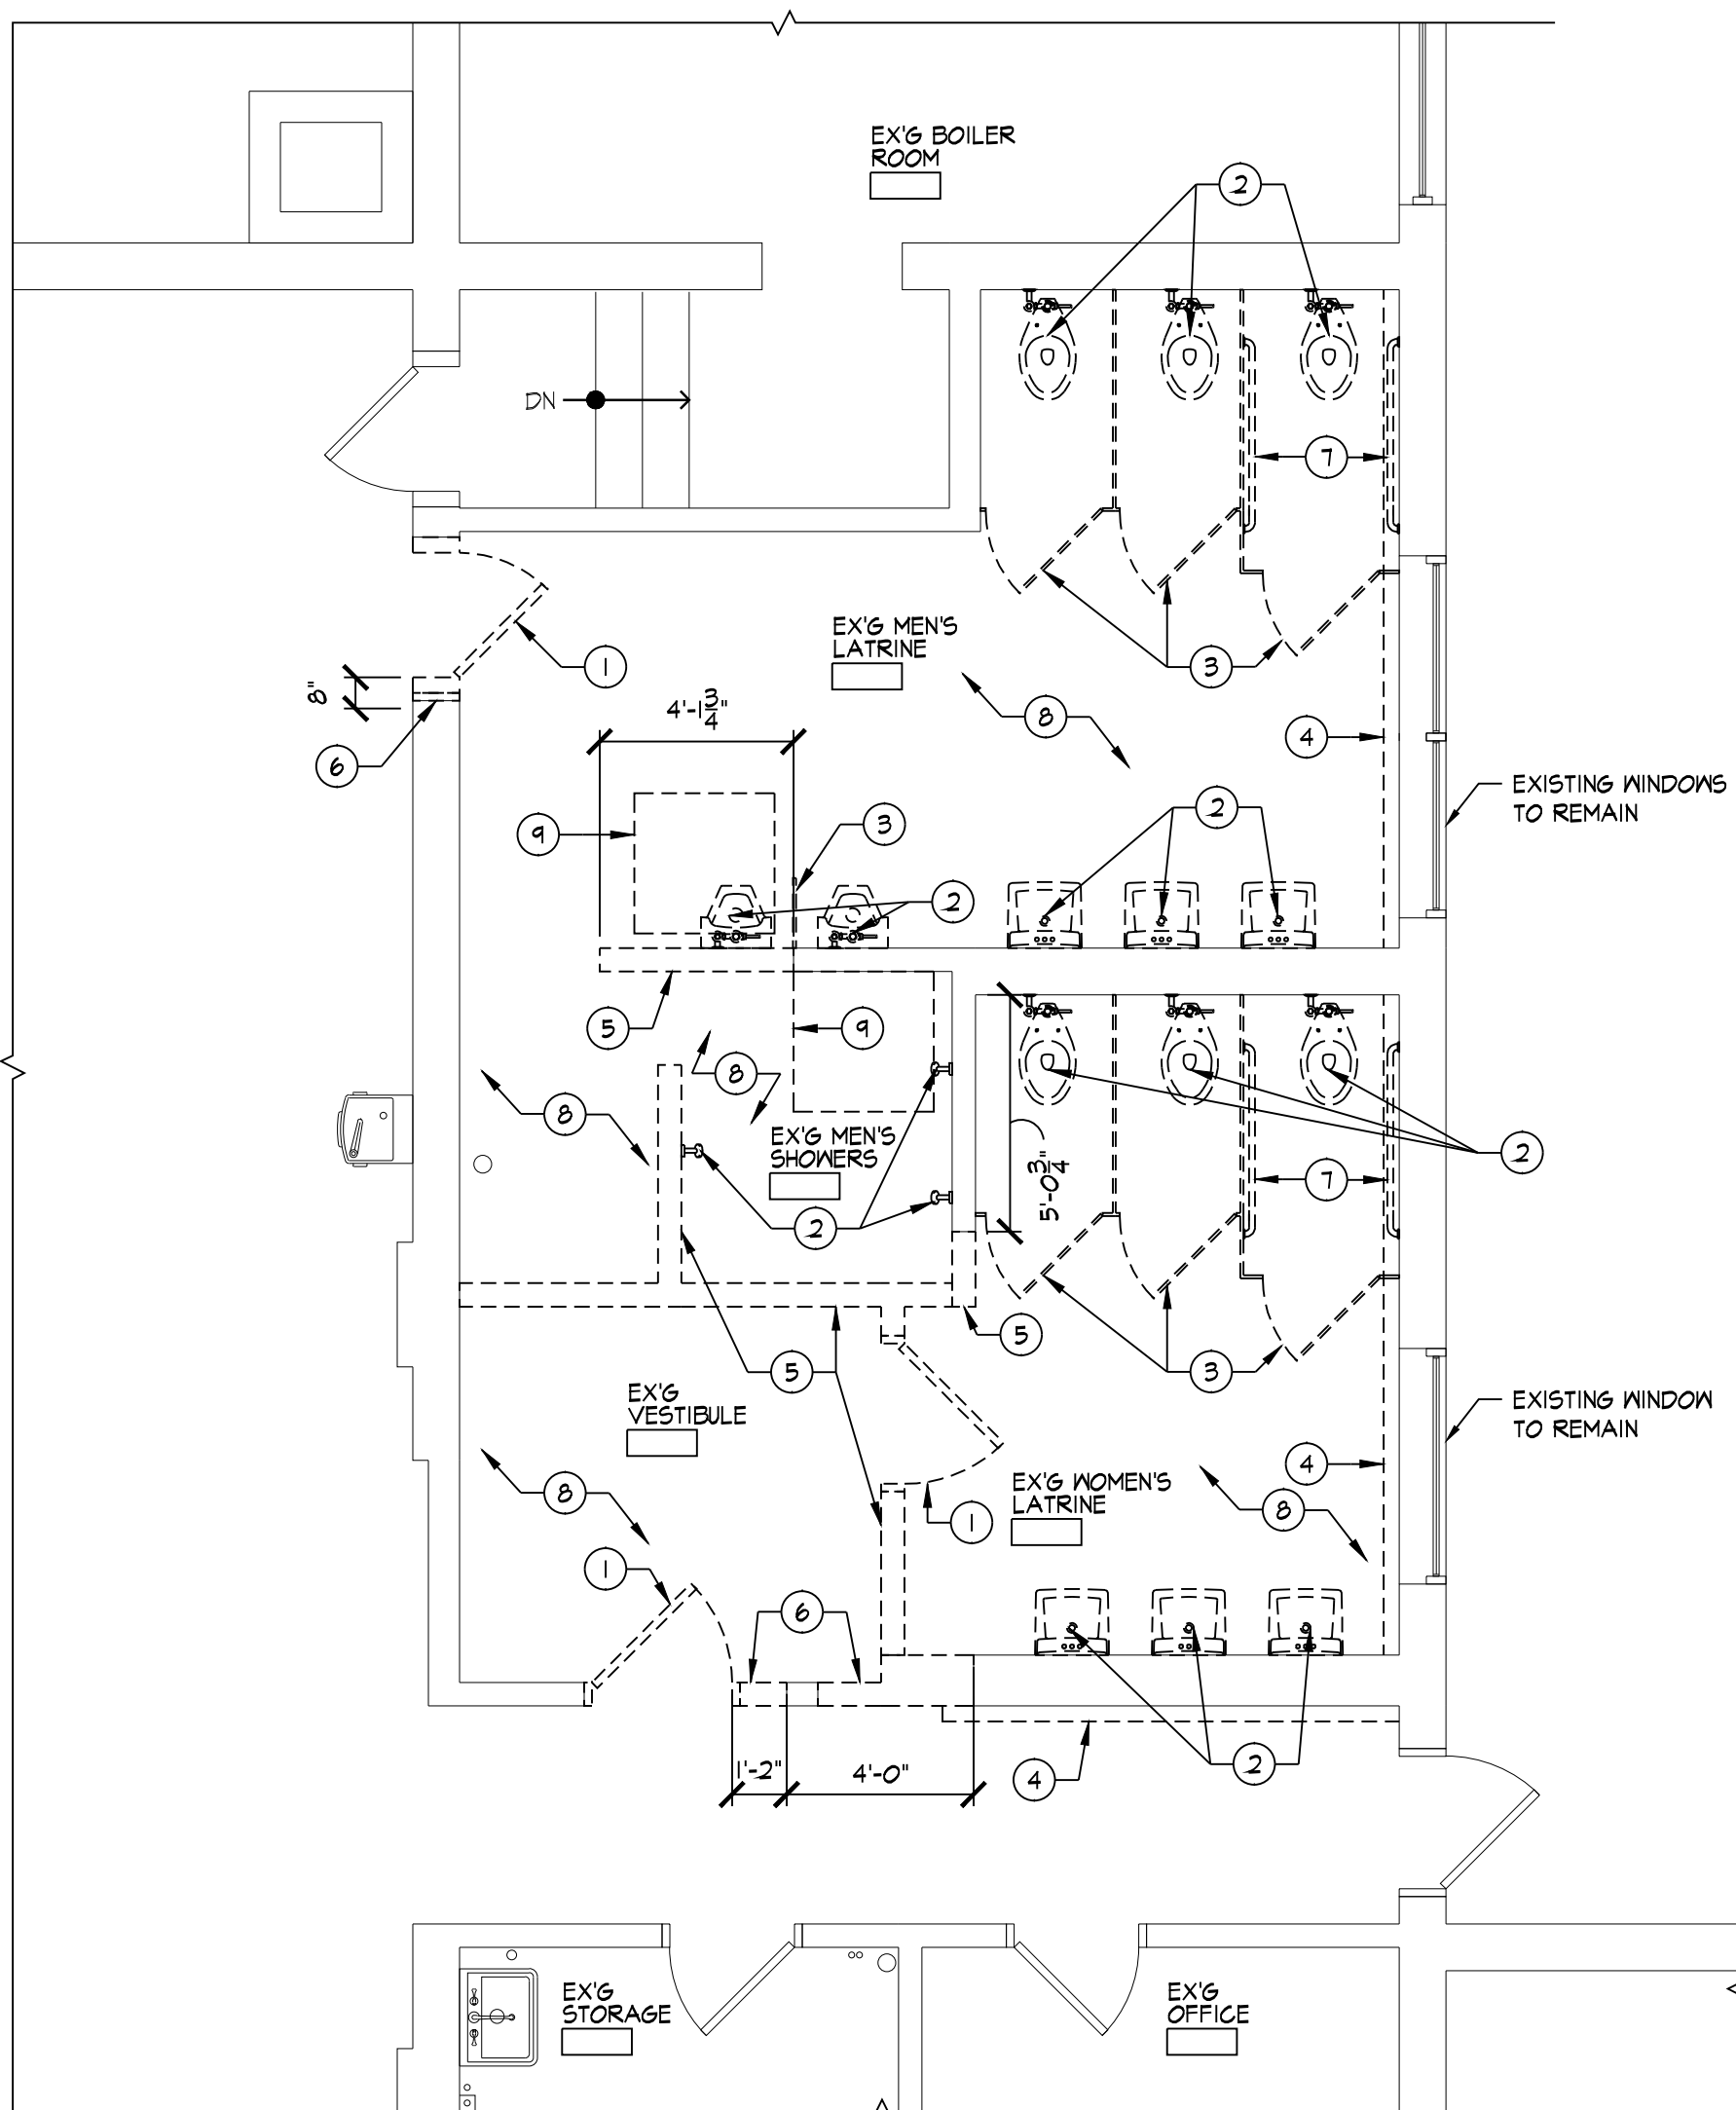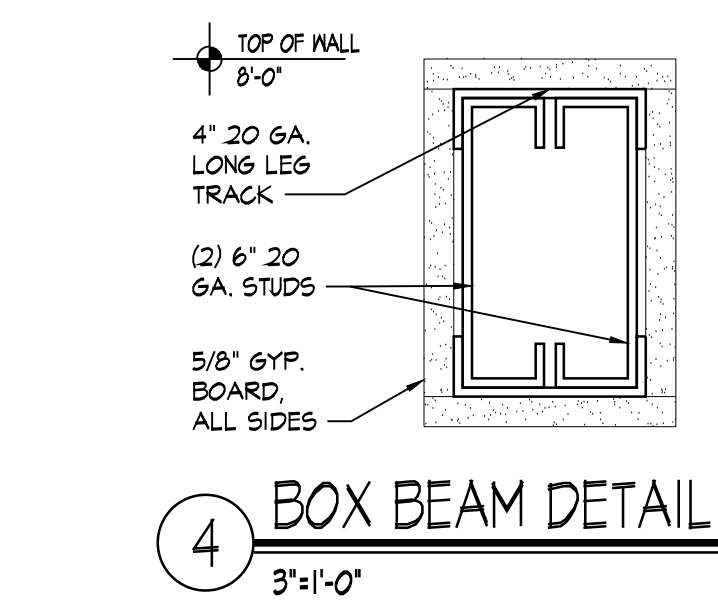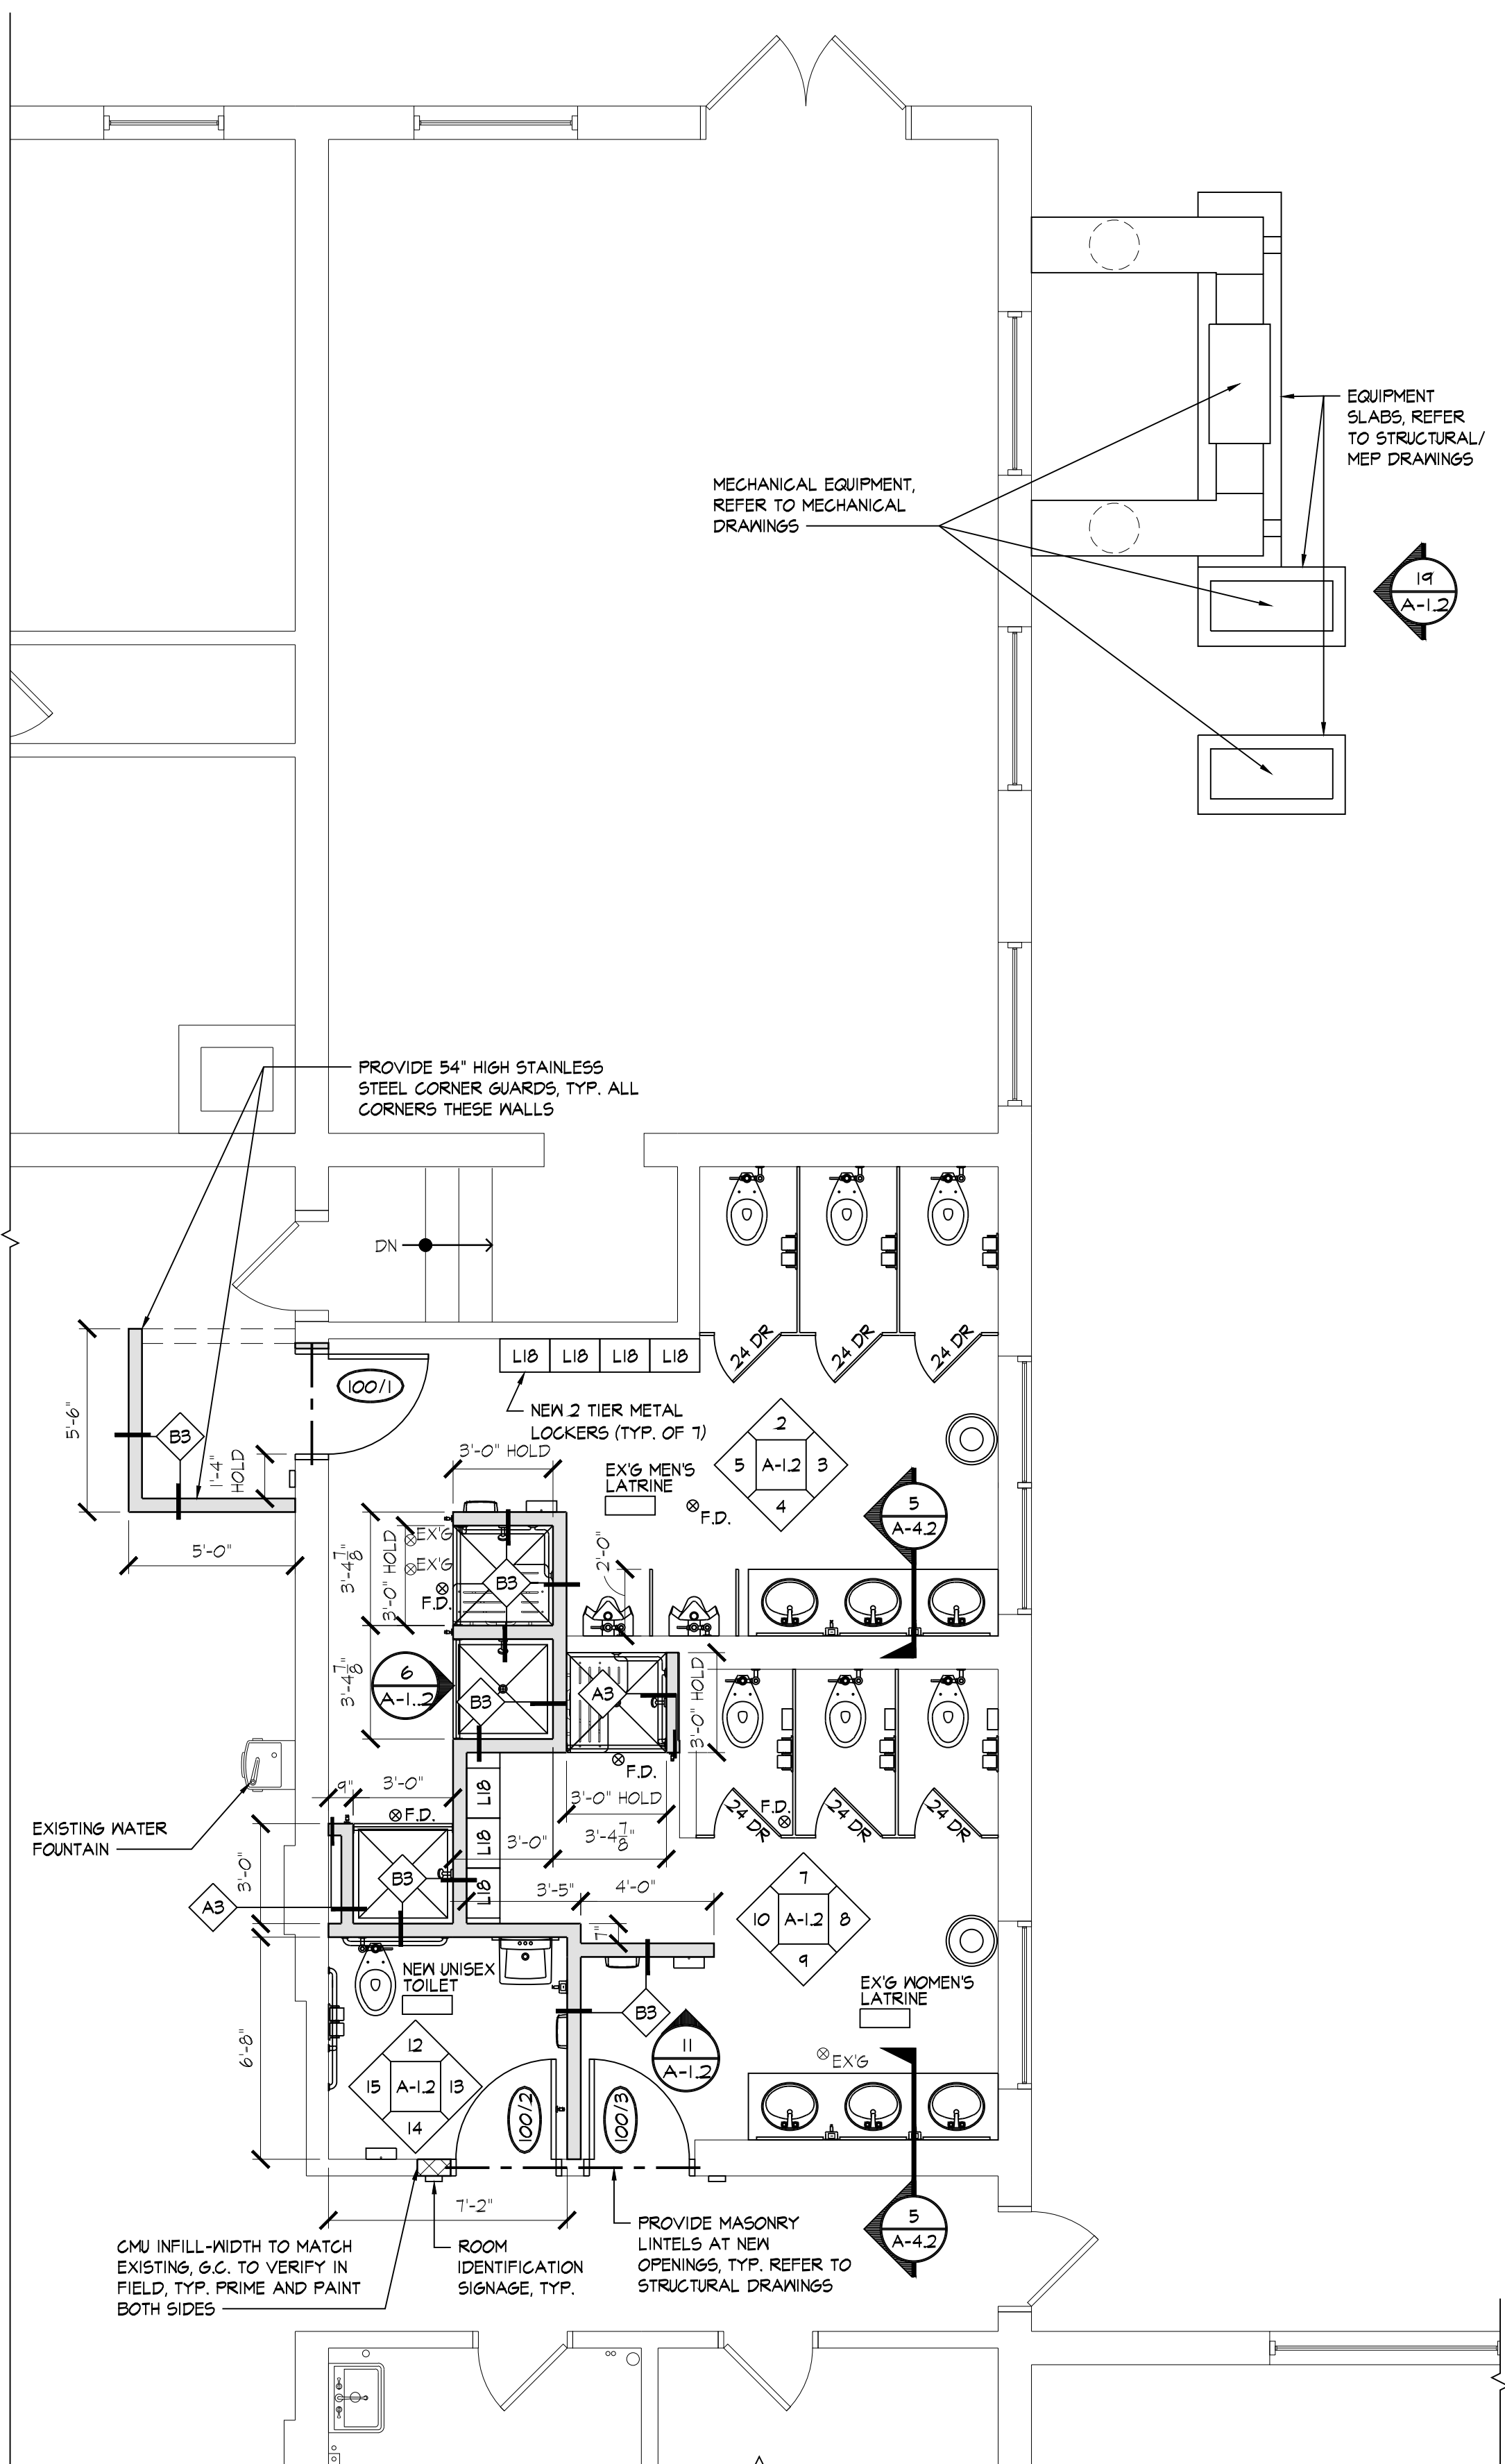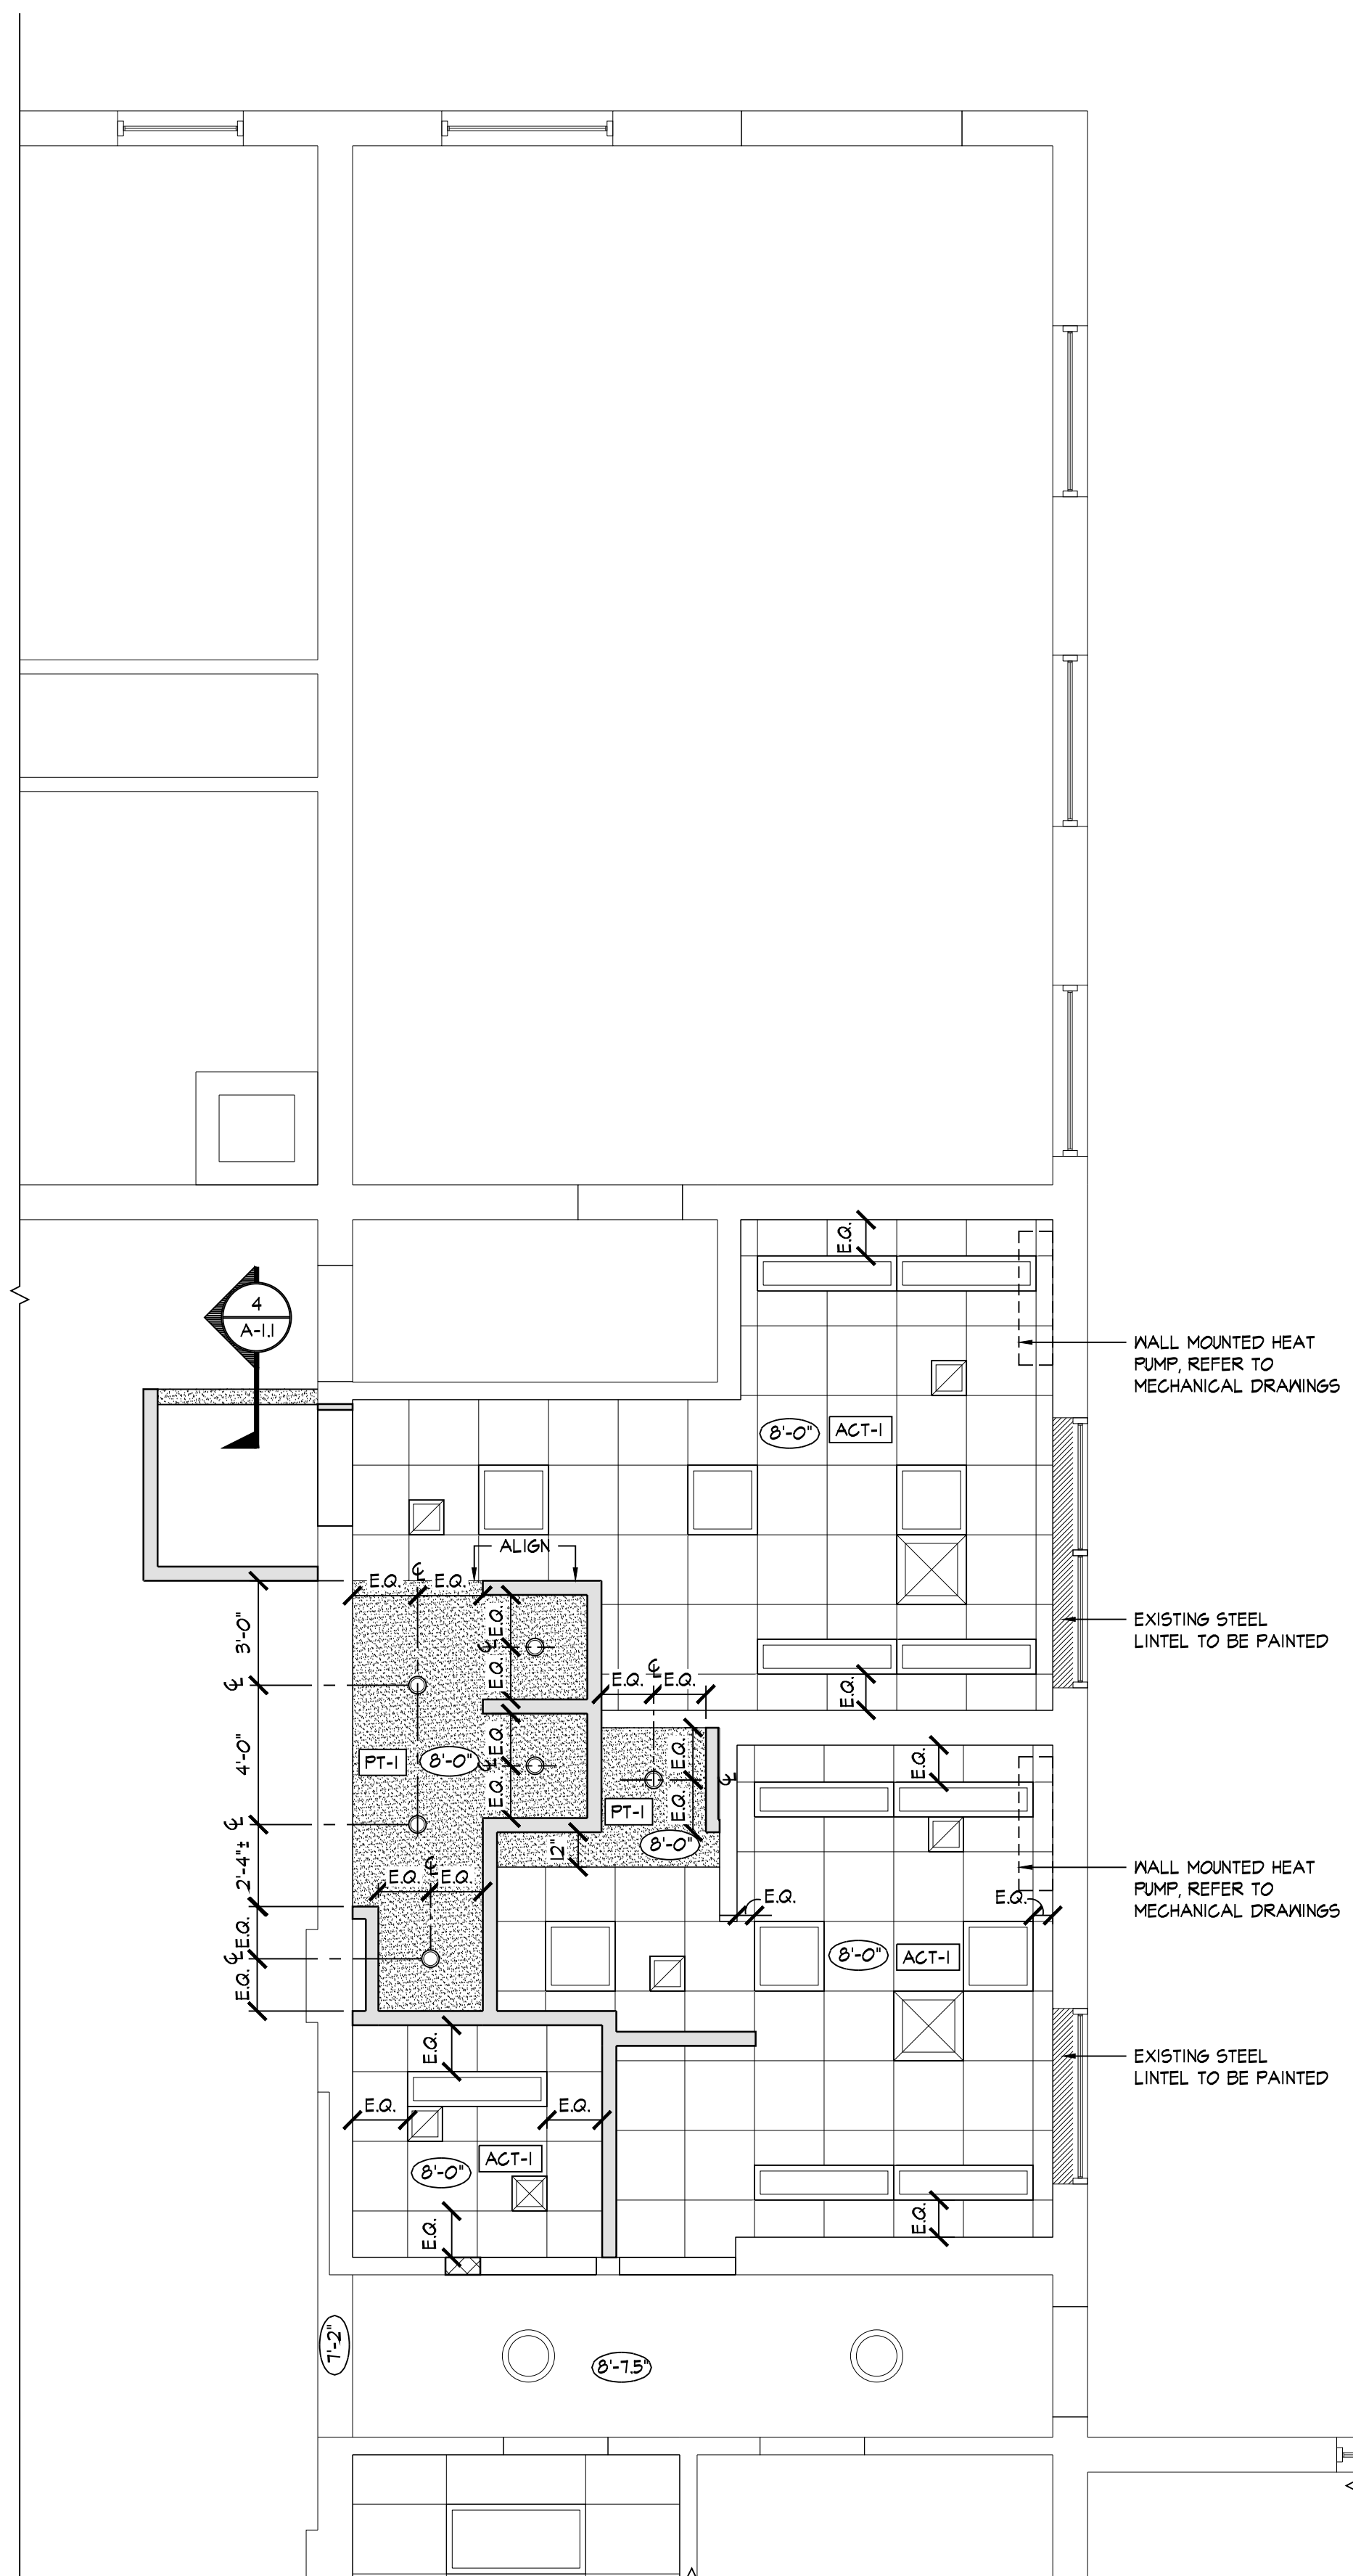


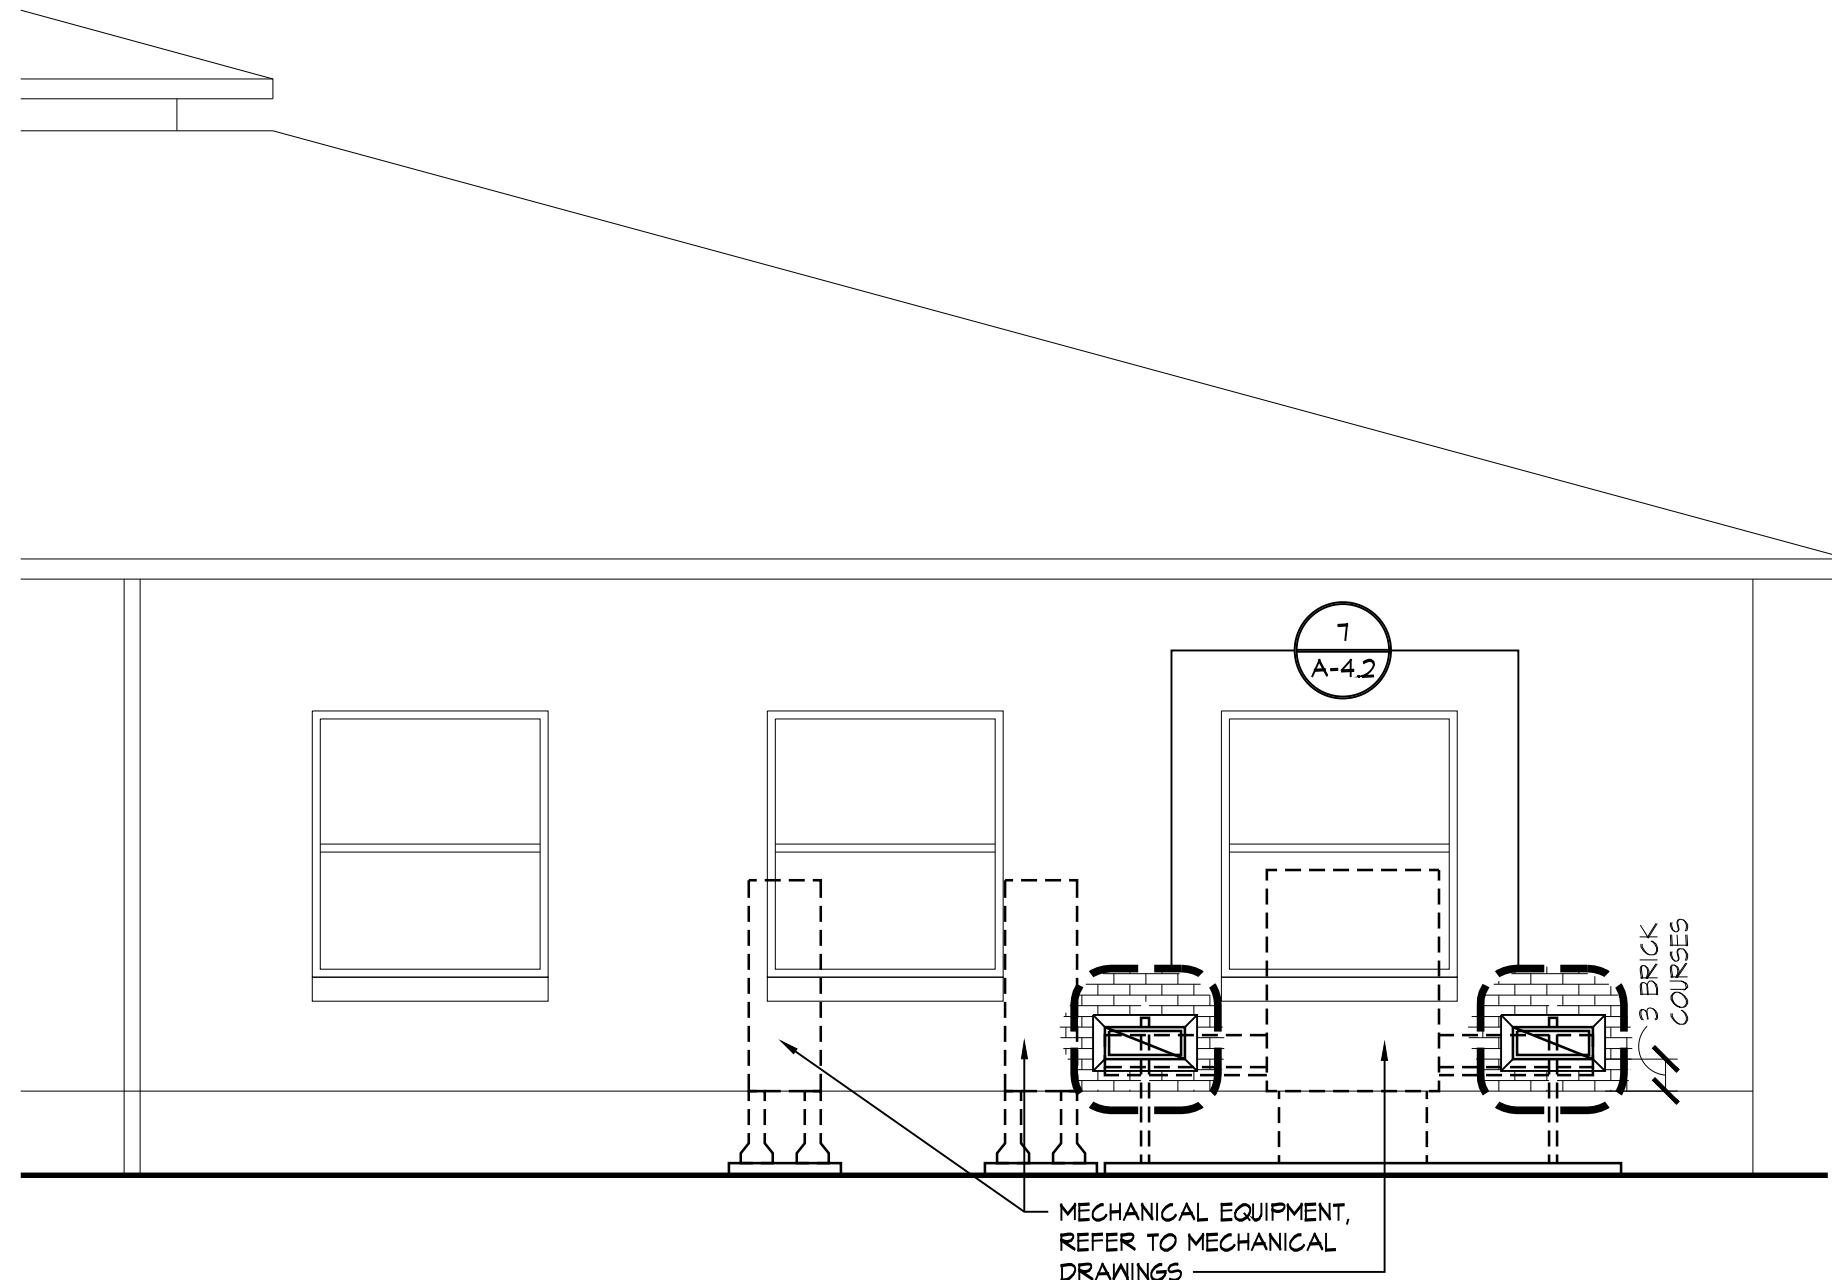


19 EXTERIOR ELEVATION
1/4"=1'-0"

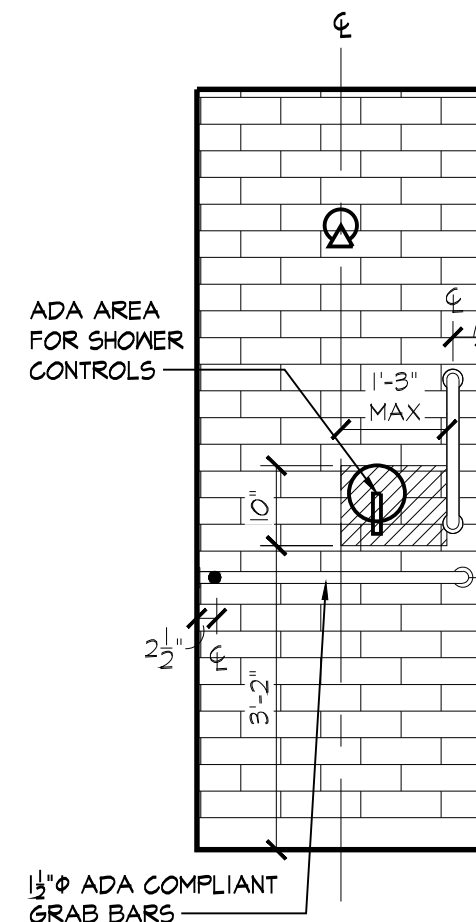


18 TYP. CONTROL WALL ELEV.
1/2"=1'-0"

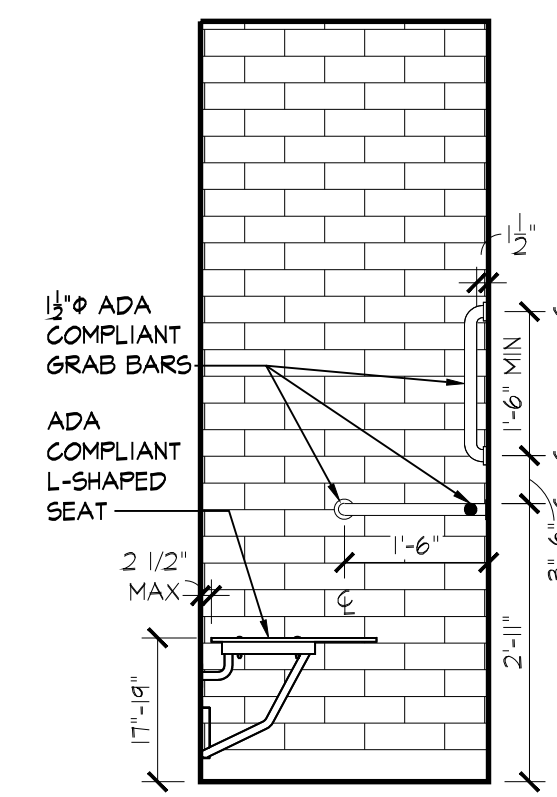


17 TYP. BACK WALL ELEV.
1/2"=1'-0"

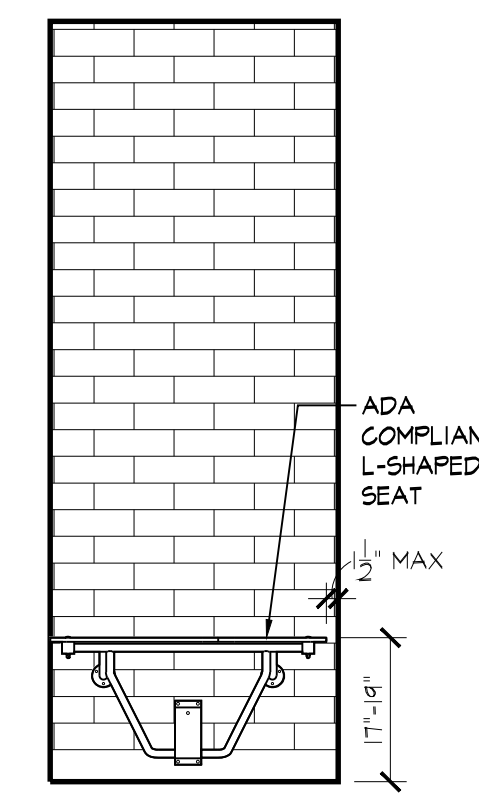


16 TYP. SEAT WALL ELEV.
1/2"=1'-0"

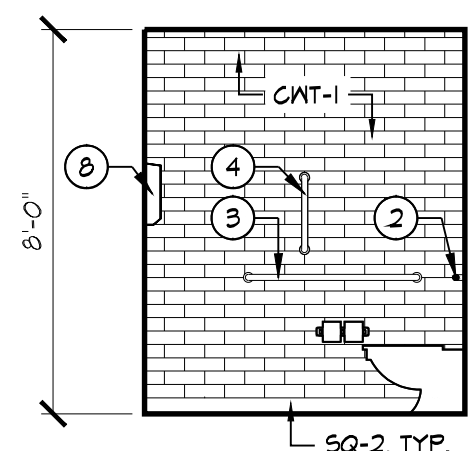


15 INTERIOR ELEVATION
1/4"=1'-0"

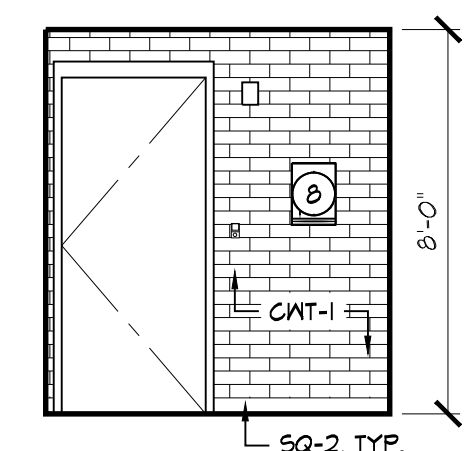


14 INTERIOR ELEVATION
1/4"=1'-0"

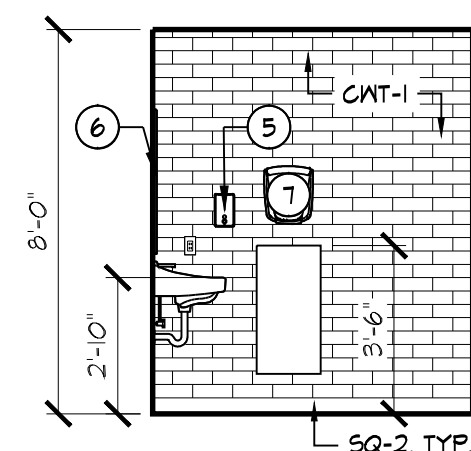


13 INTERIOR ELEVATION
1/4"=1'-0"

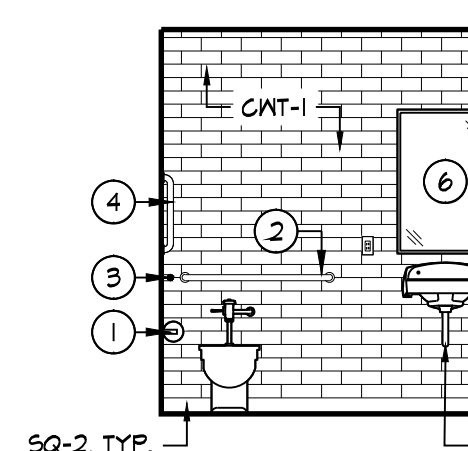


12 INTERIOR ELEVATION
1/4"=1'-0"

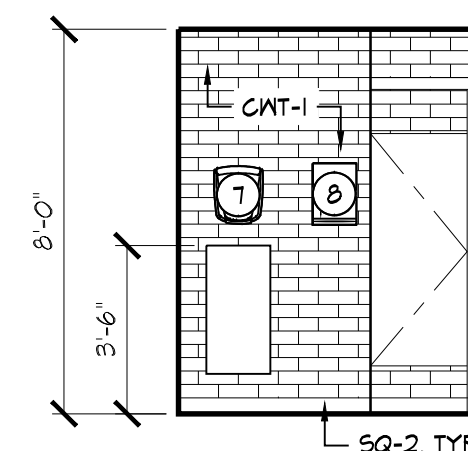


11 INTERIOR ELEVATION
1/4"=1'-0"

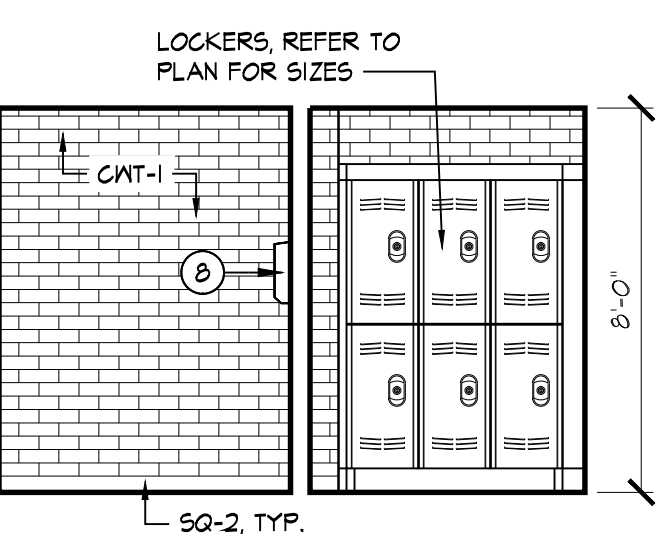


10 INTERIOR ELEVATION
1/4"=1'-0"

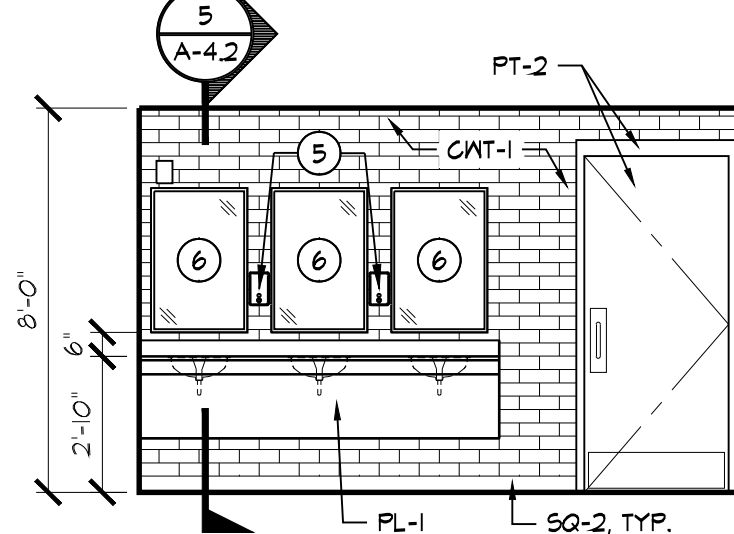


9 INTERIOR ELEVATION
1/4"=1'-0"

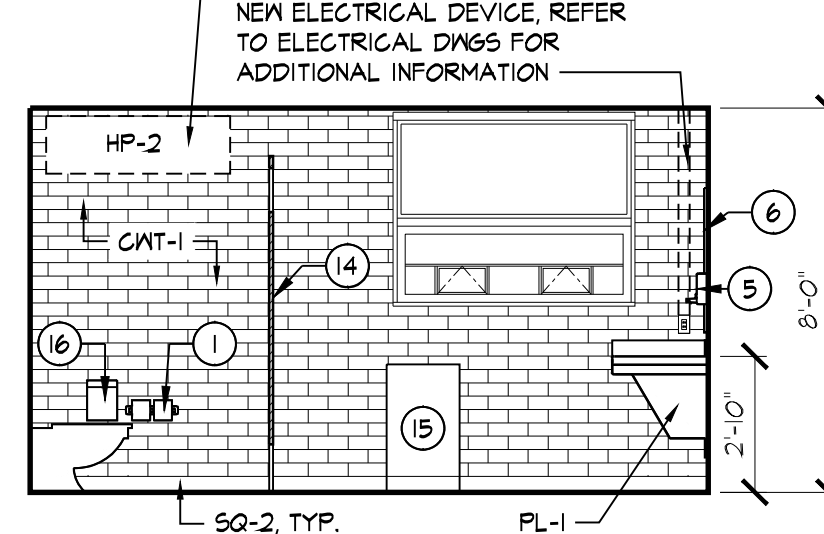


8 INTERIOR ELEVATION
1/4"=1'-0"

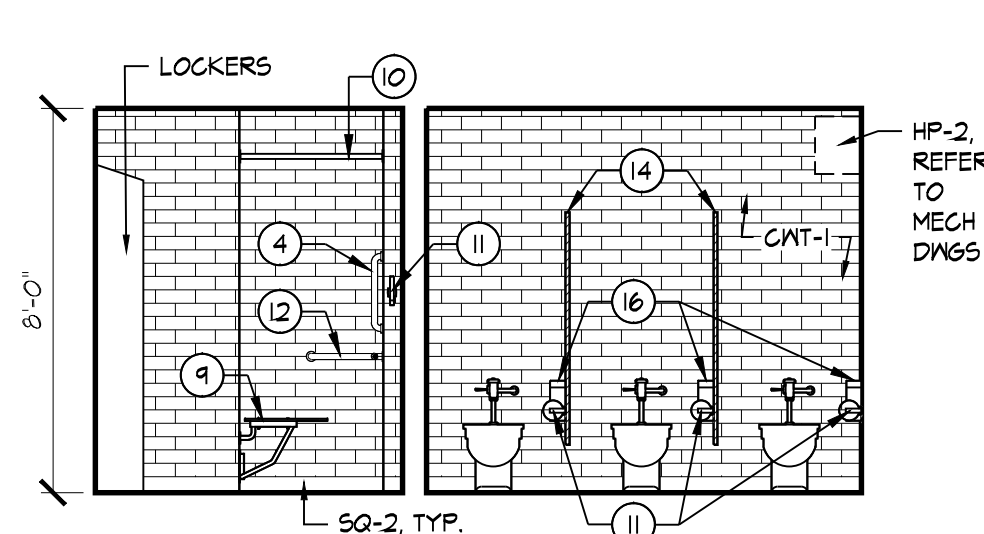


7 INTERIOR ELEVATION
1/4"=1'-0"

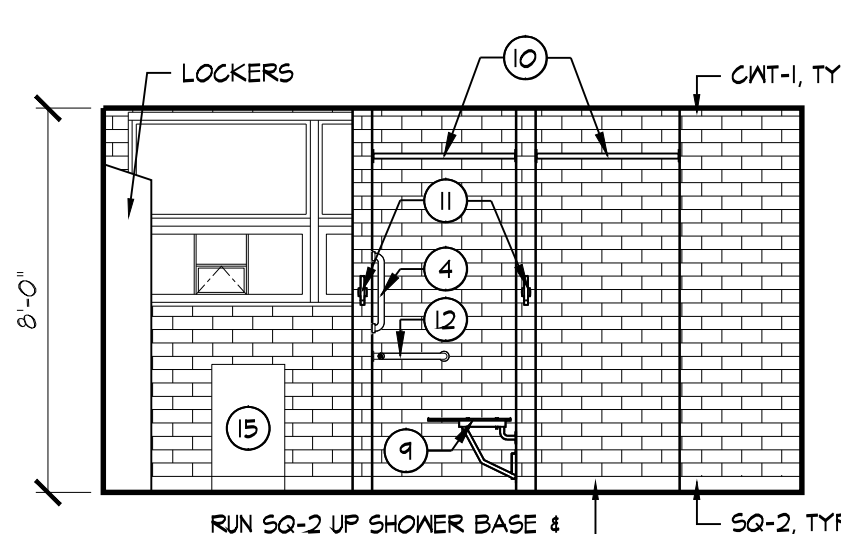


6 INTERIOR ELEVATION
1/4"=1'-0"

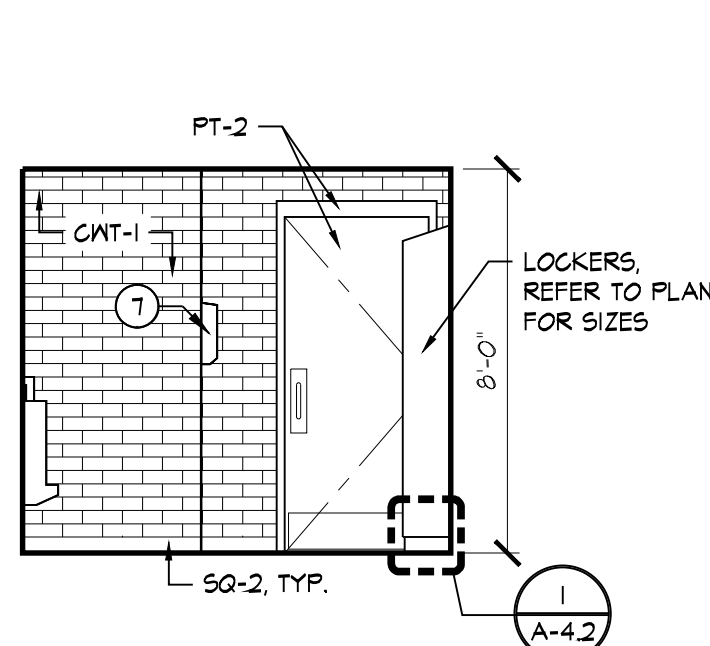


5 INTERIOR ELEVATION
1/4"=1'-0"

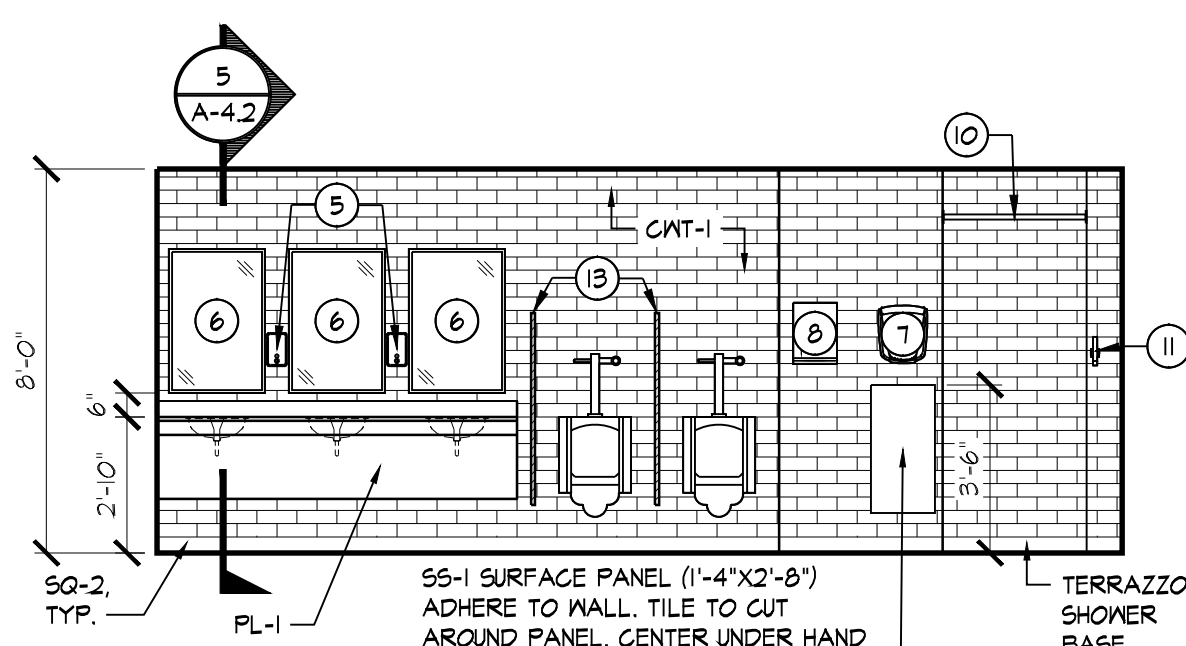


4 INTERIOR ELEVATION
1/4"=1'-0"

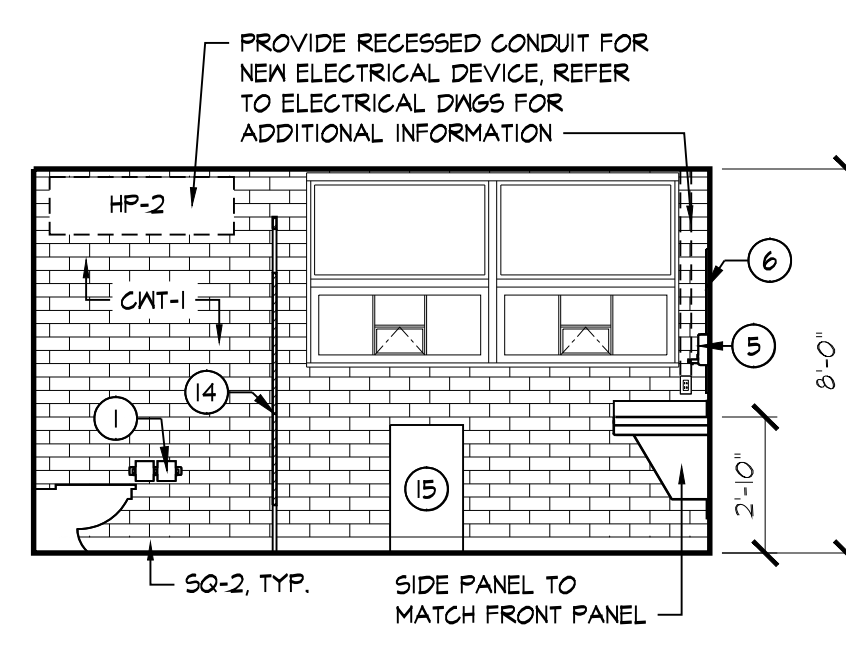

3 INTERIOR ELEVATION
1/4"=1'-0"

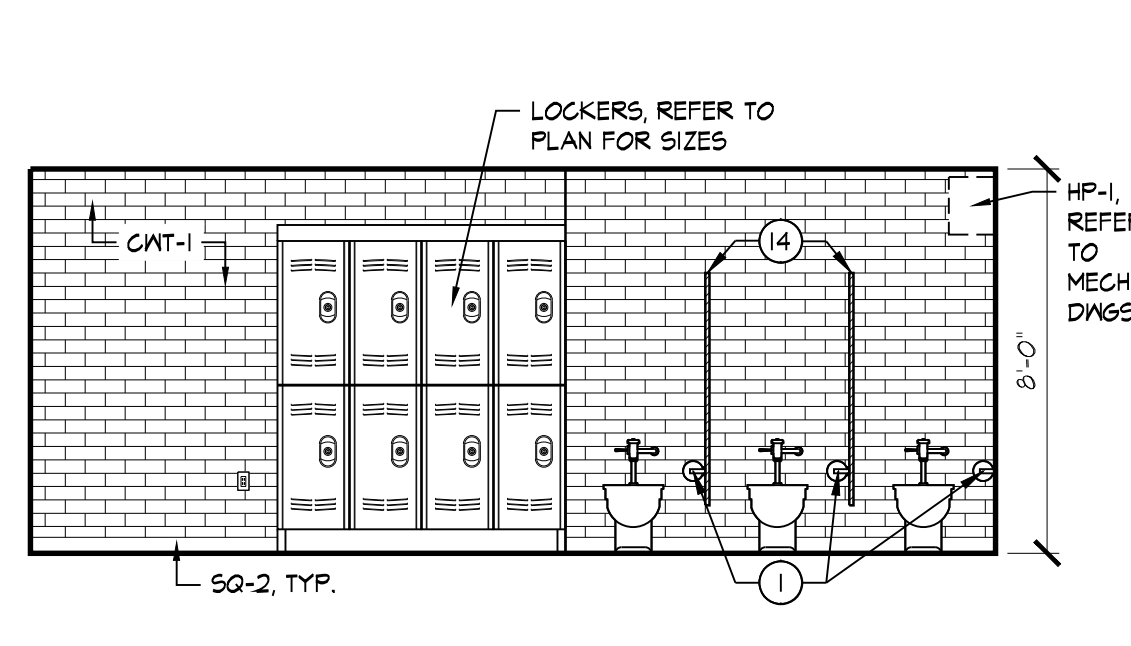

2 INTERIOR ELEVATION
1/4"=1'-0"

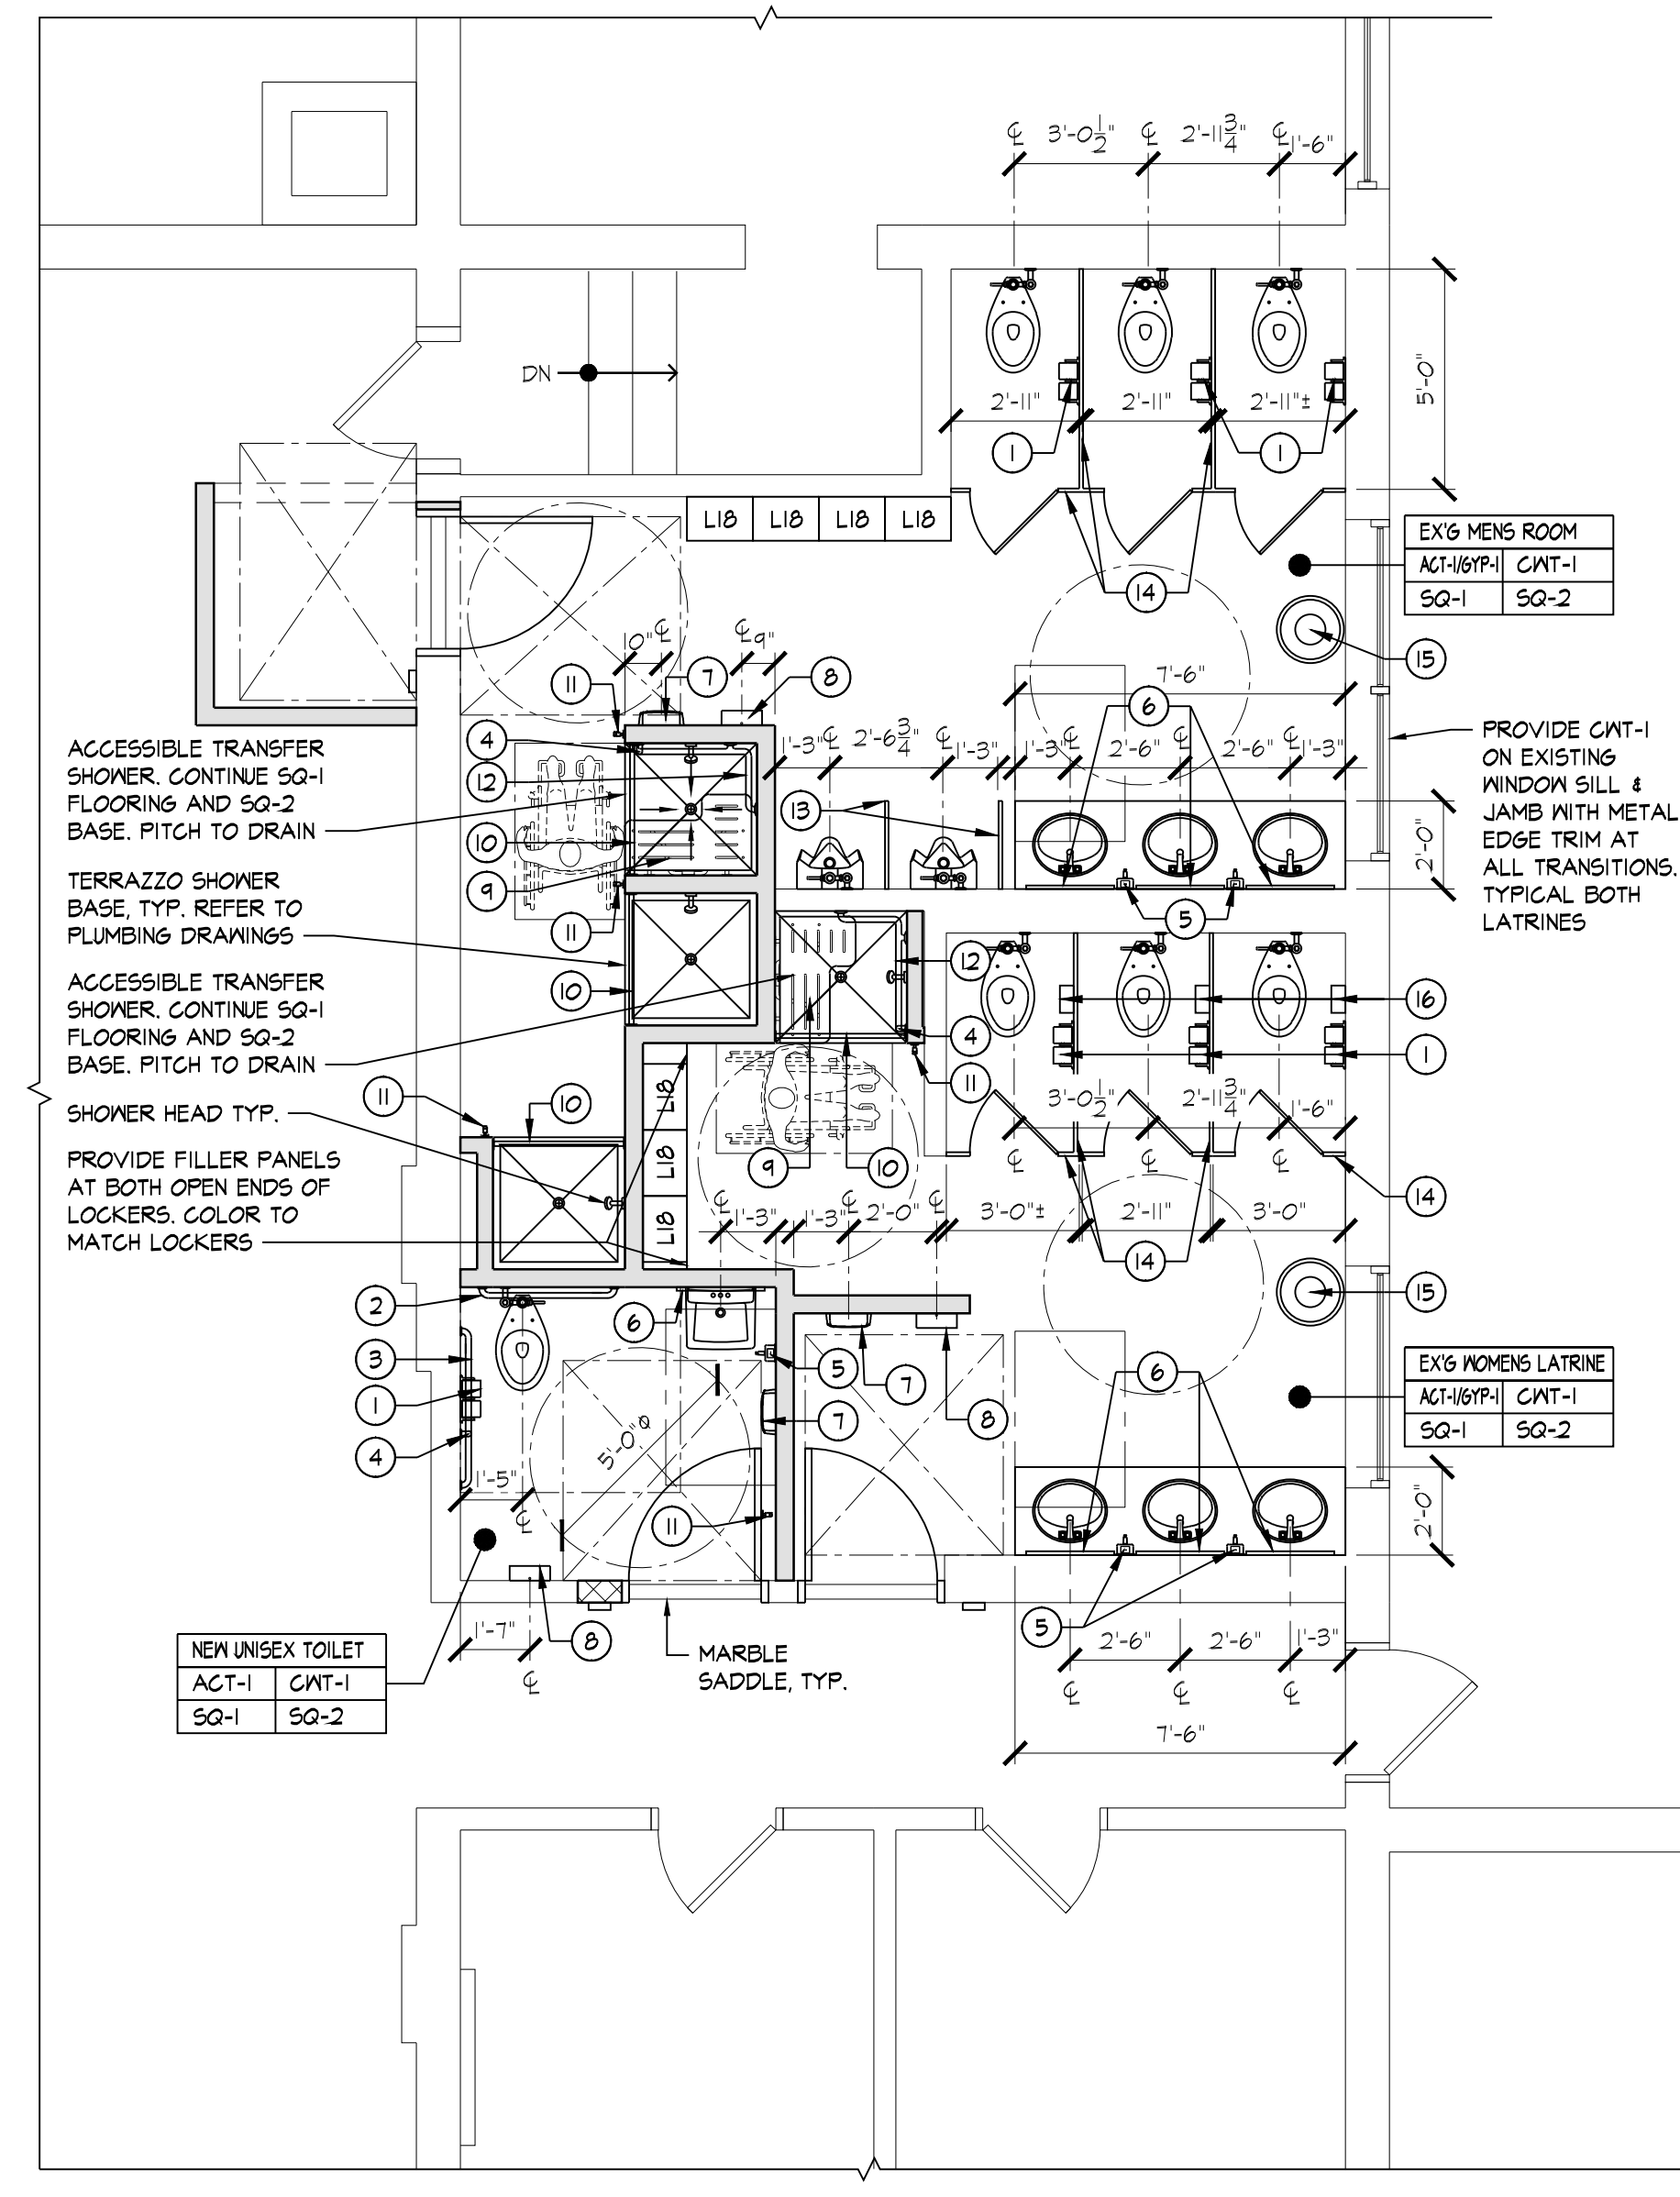

1 FINISH/FIXTURE PLAN
1/4"=1'-0"

GENERAL FINISH NOTES			
1.	REFER TO TRANSFER SHOWER WALL ELEVATION DETAILS FOR LOCATION OF ALL DEVICES, GRAB BARS, ETC.		
2.	ALL WALLS WITHIN BOTH LATRINES TO RECEIVE FULL HEIGHT CERAMIC WALL TILE (FROM SEAMLESS QUARTZ INTEGRAL BASE TO 4" ABOVE FINISHED CEILING).		
3.	ALL OUTSIDE CORNERS OF CERAMIC TILE WALLS TO RECEIVE ANODIZED ALUMINUM METAL EDGE TRIM, FULL HEIGHT.		
4.	ALL OUTSIDE CORNERS AT WINDOWS TO RECEIVE ANODIZED ALUMINUM METAL EDGE TRIM.		

FINISH SCHEDULE					
TYPE	DESCRIPTION	MANUFACTURER	STYLE / SERIES	PRODUCT / MODEL NO.	COLOR
SO-1	SEAMLESS QUARTZ FLOORING	REF. SPECIFICATIONS	REF. SPECIFICATIONS	REF. SPECIFICATIONS	GRAY
SO-2	SEAMLESS QUARTZ FLOORING	REF. SPECIFICATIONS	REF. SPECIFICATIONS	REF. SPECIFICATIONS	GRAY
ACT-1	ACOUSTICAL CEILING TILE	REF. SPECIFICATIONS	REF. SPECIFICATIONS	REF. SPECIFICATIONS	WHITE
GYP-1	GYP-SUM BOARD	REF. SPECIFICATIONS	REF. SPECIFICATIONS	REF. SPECIFICATIONS	-
PT-1	PAINT	REF. SPECIFICATIONS	REF. SPECIFICATIONS	REF. SPECIFICATIONS	WHITE
PT-2	PAINT	REF. SPECIFICATIONS	REF. SPECIFICATIONS	REF. SPECIFICATIONS	GRAY
CNT-1	CERAMIC WALL TILE	REF. SPECIFICATIONS	REF. SPECIFICATIONS	REF. SPECIFICATIONS	WHITE
SS-1	SOLID SURFACE	REF. SPECIFICATIONS	REF. SPECIFICATIONS	REF. SPECIFICATIONS	WHITE
QA-1	QUARTZ AGGLOMERATE	REF. SPECIFICATIONS	REF. SPECIFICATIONS	REF. SPECIFICATIONS	GRAY
PL-1	PLASTIC LAMINATE	REF. SPECIFICATIONS	REF. SPECIFICATIONS	REF. SPECIFICATIONS	WHITE

ROOM FINISH KEY	
FINISH KEY	ROOM #
CNTS	WALL
FLR	BASE

TOILET EQUIPMENT SCHEDULE				
MARK	DESCRIPTION	MODEL #	MANUFACTURER	REMARKS
1	TOILET PAPER DISPENSER	B-16867	BOBRICK OR APPROVED EQUAL	SUPPLIED AND INSTALLED BY G.C.
2	1/2" GRAB BAR - 36" L. - HORIZONTAL	B-6806X36	BOBRICK OR APPROVED EQUAL	SUPPLIED AND INSTALLED BY G.C.
3	1/2" GRAB BAR - 42" L. - HORIZONTAL	B-6806X42	BOBRICK OR APPROVED EQUAL	SUPPLIED AND INSTALLED BY G.C.
4	1/2" GRAB BAR - 18" L. - VERTICAL	B-6806X18	BOBRICK OR APPROVED EQUAL	SUPPLIED AND INSTALLED BY G.C.
5	SOAP DISPENSER	B-2111	BOBRICK OR APPROVED EQUAL	SUPPLIED AND INSTALLED BY G.C.
6	MIRROR	B-1658 2436	BOBRICK OR APPROVED EQUAL	S.S. FRAME, SUPPLIED AND INSTALLED BY G.C.
7	HIGH VELOCITY HAND DRYER	B-7128	BOBRICK OR APPROVED EQUAL	SUPPLIED AND INSTALLED BY G.C.
8	PAPER TOWEL DISPENSER	B-262	BOBRICK OR APPROVED EQUAL	SUPPLIED AND INSTALLED BY G.C.
9	SHOWER SEAT	B-5181	BOBRICK OR APPROVED EQUAL	SUPPLIED AND INSTALLED BY G.C.
10	SHOWER ROD AND CURTAIN	B-6107	BOBRICK OR APPROVED EQUAL	SUPPLIED AND INSTALLED BY G.C.
11	COAT HOOK	B-6827	BOBRICK OR APPROVED EQUAL	SUPPLIED AND INSTALLED BY G.C.
12	1/2" GRAB BAR - TWO WALL - HORIZONTAL	B-6861	BOBRICK OR APPROVED EQUAL	SUPPLIED AND INSTALLED BY G.C.
13	HDPE URINAL PRIVACY SCREEN	WALL MOUNTED	ASI ACCURATE PARTITIONS OR APPROVED EQUAL	SUPPLIED AND INSTALLED BY G.C.
14	HDPE TOILET PARTITIONS	OVERHEAD BRACED	ASI ACCURATE PARTITIONS OR APPROVED EQUAL	SUPPLIED AND INSTALLED BY G.C.
15	TRASH RECEPTACLE	B-2400	BOBRICK OR APPROVED EQUAL	SUPPLIED AND INSTALLED BY G.C.
16	SANITARY NAPKIN DISPENSER	B-2710	BOBRICK OR APPROVED EQUAL	SUPPLIED AND INSTALLED BY G.C.

EQUIPMENT NOTES	
1.	ALL EXPOSED PIPES UNDER SINKS IN HANDICAPPED ACCESSIBLE TOILET ROOMS TO BE PROTECTED WITH ADA COMPLIANT PIPE JACKETS
2.	PROVIDE ADA PULL, CLOSER, COAT HOOK AND LATCH AT ALL TOILET PARTITIONS
3.	PROVIDE SOLID BLOCKING IN WALL FOR ALL WALL MOUNTED EQUIPMENT
4.	ALL TOILET EQUIPMENT/PRODUCT DATA TO BE SUBMITTED TO ARCHITECT FOR REVIEW AND APPROVAL
5.	REFER TO G-10 FOR TYPICAL MOUNTING HEIGHTS.



Department of Community Affairs
Construction Project Review
Project No: 9050-26
Part: 001 - Recording
Building Review
Release Date: 5/22/2025
N.J.S.A. 52:27D-119 ET SEQ., AS AMENDED

tm
TOKARSKI + MILLEMAN
ARCHITECTS, LLC

1729 ROUTE 35
WALL, NEW JERSEY 07719
phone 732.262.0046
facsimile 732.262.0045
Email info@tm-architects.com

Michael J. Millemann, AIA
NJ LICENSE # A1 14550
N.Y. LICENSE # 02885

CERTIFICATE OF AUTHORIZATION
No. AC33200

LATRINE ALTERATIONS FOR:
MT HOLLY ARMORY
1670 NJ-38
MT HOLLY, NEW JERSEY 08060
DMA PROJECT NO. MH008

REV: DATE: DESCRIPTION:

FINISH/FIXTURE PLAN &
INTERIOR ELEVATIONS

PROJECT NO.: 2551 DRAWN BY: DD

DATE ISSUED: 3/30/2026

SHEET NO.:

A-1.2



Department of Community Affairs
Construction Project Review
Project No. 9050-26
Part 01 - Interior/Building
building review
Raffaele Persico
Released: 5/22/2025
N.J.S.A. 52:27-119 ET SEQ., AS AMENDED



TOKARSKI + MILLEMAN
ARCHITECTS, LLC

1729 ROUTE 35
WALL, NEW JERSEY 07719

phone 732.262.0046
facsimile 732.262.0045
Email info@tm-architects.com


Michael J. Millemann, AIA

Michael J. Millemann
N.J. LICENSE # A1 14550
N.Y. LICENSE # 028895

CERTIFICATE OF AUTHORIZATION
No. AC33200

LATRINE ALTERATIONS FOR:
MT HOLLY ARMORY
1670 NJ-38
MT HOLLY, NEW JERSEY 08060
DMA PROJECT NO. MH008

TYPICAL METAL STUD DETAILS

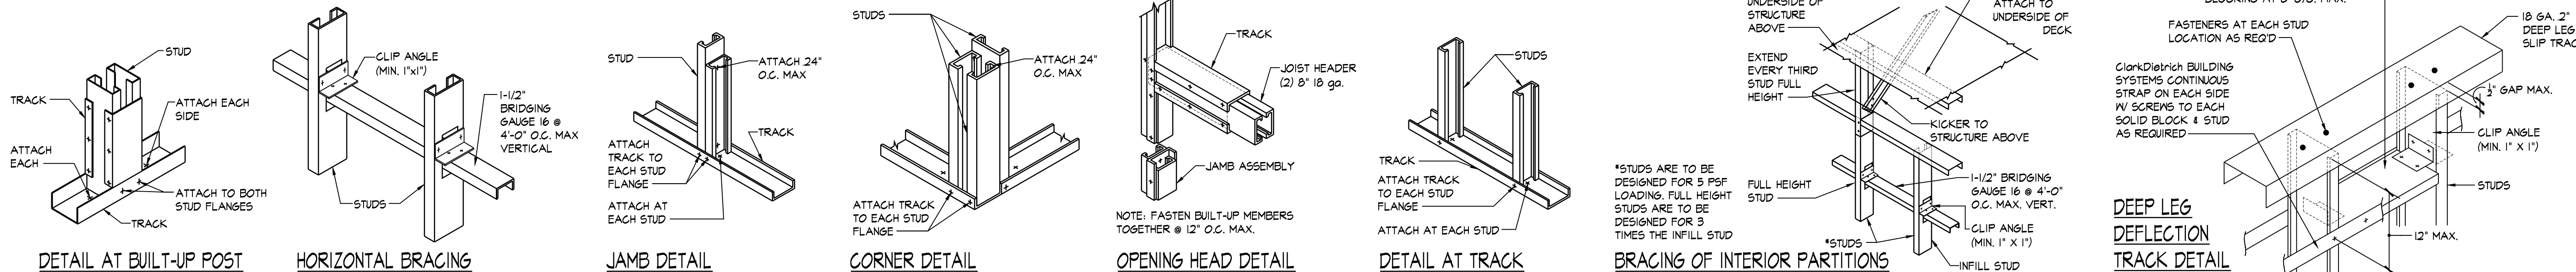

PARTITION TYPES

PARTITION TYPE D CMU PARTITION									
TOP ATTACHMENT	REFER TO HEAD OF WALL DETAILS FOR APPLICABLE CONDITION	UNDERSIDE OF STRUCTURE ABOVE	CEILING, RE: CEILING PLANS FOR MATERIAL AND FINISH	CONCRETE MASONRY UNIT	BASE AS SCHEDULED, TYP. BOTH SIDES	FLOOR ATTACHMENT			
PARTITION	UNIT	DETAIL	FIRE	STC	REMARKS				
TAG	SIZE	HEAD OF WALL	RATING	TEST	RATING				
D4	3 5/8	-	-	-					
D6	5 5/8	-	-	-					
D8	7 5/8	-	-	-					
D10	9 5/8	-	-	-					
D12	11 5/8	-	-	-					
D14	13 5/8	-	-	-					
			2HR	U405					

PARTITION TYPE C METAL STUD PARTITION									
TOP ATTACHMENT	REFER TO HEAD OF WALL DETAILS FOR APPLICABLE CONDITION	UNDERSIDE OF STRUCTURE ABOVE	GYPSUM BOARD BOTH SIDES	METAL STUD	SOUND ATTENUATION BLANKET - GENERAL PARTITION TYPE #18	CEILING, RE: CEILING PLANS FOR MATERIAL AND FINISH	PROVIDE SPAZZER 9200 CONT. BRIDGING & SPACEBAR OR U-CHANNEL & EASY-CLIP BRIDGING @ 60" O.C. VERT. FOR LATERAL SUPPORT (TYP)	BASE AS SCHEDULED, TYP. BOTH SIDES	ACOUSTICAL SEALANT BOTH SIDES (AT SOUND PARTITION)
FLOOR ATTACHMENT									
PARTITION	FRAMING	STUD	INSUL.	DETAIL	FIRE	STC	REMARKS		
TAG	SPACING	SIZE	SOUND ATT. THICK.	HEAD OF WALL	RATING	TEST	RATING		
C1	16	1 5/8	-	-	-	-			
C2	16	2 1/2	-	-	-	-			
C3	16	3 5/8	-	-	-	-			
C6	16	6	-	-	-	-			
C3X	16	3 5/8	3 1/2	-	2 HR	U411	50		

PARTITION TYPE B METAL STUD PARTITION									
TOP ATTACHMENT	REFER TO HEAD OF WALL DETAILS FOR APPLICABLE CONDITION	UNDERSIDE OF STRUCTURE ABOVE	GYPSUM BOARD BOTH SIDES	METAL STUD	SOUND ATTENUATION BLANKET, RE: GENERAL PARTITION TYPE #18	CEILING, RE: CEILING PLANS FOR MATERIAL AND FINISH	PROVIDE SPAZZER 9200 CONT. BRIDGING & SPACEBAR OR U-CHANNEL & EASY-CLIP BRIDGING @ 60" O.C. VERT. FOR LATERAL SUPPORT (TYP)	BASE AS SCHEDULED, TYP. BOTH SIDES	ACOUSTICAL SEALANT BOTH SIDES (AT SOUND PARTITION)
FLOOR ATTACHMENT									
PARTITION	FRAMING	STUD	INSUL.	DETAIL	FIRE	STC	REMARKS		
TAG	SPACING	SIZE	SOUND ATT. THICK.	HEAD OF WALL	RATING	TEST	RATING		
B1	16	1 5/8	-	-	-	-			
B2	16	2 1/2	-	-	-	-			
B3	16	3 5/8	-	-	-	-	10 MIL		
B6	16	6	-	-	-	-			
B2X	16	2 1/2	2 1/2	-	1 HR	U414	31		
B3X	16	3 5/8	3 1/2	-	1 HR	U465	43		
B6X	16	6	6	-	1 HR	U419	51		

PARTITION TYPE A FURRING METAL STUD PARTITION									
TOP ATTACHMENT	UNDERSIDE OF STRUCTURE ABOVE	CEILING, RE: CEILING PLANS FOR MATERIAL AND FINISH	METAL STUD	GYPSUM BOARD	BASE AS SCHEDULED, TYP. BOTH SIDES	FLOOR ATTACHMENT			
PARTITION	FRAMING	STUD	INSUL.	DETAIL	STC	REMARKS			
TAG	SPACING	SIZE	SOUND ATT. THICK.	HEAD OF WALL	RATING				
A0	16	7/8	-	-	-				
A1	16	1 5/8	-	-	-				
A2	16	2 1/2	-	-	-				
A3	16	3 5/8	-	-	-	10 MIL			
A6	16	6	-	-	-				

PARTITION TYPE F CHASE PARTITION									
TOP ATTACHMENT	REFER TO HEAD OF WALL DETAILS FOR APPLICABLE CONDITION	UNDERSIDE OF STRUCTURE ABOVE	METAL STUD	SOUND ATTENUATION BLANKET, GENERAL PARTITION TYPE #18	GYPSUM BOARD, BOTH SIDES	CEILING, RE: CEILING PLANS FOR MATERIAL AND FINISH	6" AT ACT. CEILING NON RATED LOCATION	RE: PLAN	PROVIDE SPAZZER 9200 CONT. BRIDGING & SPACEBAR OR U-CHANNEL & EASY-CLIP BRIDGING @ 60" O.C. VERT. FOR LATERAL SUPPORT (TYP)
FLOOR ATTACHMENT									
PARTITION	FRAMING	STUD	INSUL.	DETAIL	FIRE	STC	REMARKS		
TAG	SPACING	SIZE	SOUND ATT. THICK.	HEAD OF WALL	RATING	TEST	RATING		
F1	16	1 5/8	-	-	-	-			
F2	16	2 1/2	-	-	-	-			
F3	16	3 5/8	-	-	-	-			
F6	16	6	-	-	-	-			
F2X	16	2 1/2	3 1/2	-	1 HR	U408	51		

PARTITION TYPE E PARTIAL HEIGHT PARTITION									
TOP ATTACHMENT	STUDS - RE: PARTITION TYPE LOW WALL STUD REINFORCEMENT	PAINTED MAPLE SILL, EASE ALL EDGES	GYPSUM BOARD, BOTH SIDES	24" HIGH LOW WALL STUD REINFORCEMENT (BASIS OF DESIGN CLARK DETRIEUX PONY WALL (W24 HEAVY) @ 48" O.C. (OR APPROVED EQUAL))	BASE AS SCHEDULED, TYP. BOTH SIDES	FLOOR ATTACHMENT			
PARTITION	FRAMING	STUD	REMARKS						
TAG	SPACING	SIZE							
E3	16	3 5/8	-						
E6	16	6	-						

PARTITION TYPE G METAL STUD PARTITION									
TOP ATTACHMENT	UNDERSIDE OF STRUCTURE ABOVE	BRACE TO STRUCTURE 48" O.C. IN HTL. FRAMING AS NEEDED	METAL STUD	SOUND ATTENUATION BLANKET, RE: GENERAL PARTITION TYPE #18	CEILING, RE: CEILING PLANS FOR MATERIAL AND FINISH	PROVIDE SPAZZER 9200 CONT. BRIDGING & SPACEBAR OR U-CHANNEL & EASY-CLIP BRIDGING @ 60" O.C. VERT. FOR LATERAL SUPPORT (TYP)	GYPSUM BOARD BOTH SIDES	BASE AS SCHEDULED, TYP. BOTH SIDES	ACOUSTICAL SEALANT BOTH SIDES (AT SOUND PARTITION)
FLOOR ATTACHMENT									
PARTITION	FRAMING	STUD	INSUL.	STC	REMARKS				
TAG	SPACING	SIZE	SOUND ATT. THICK.						
G1	16	1 5/8	-	-					
G2	16	2 1/2	-	-					
G3	16	3 5/8	-	-					
G6	16	6	-	-					

PARTITION TYPE S SHAFTWALL PARTITION									
TOP ATTACHMENT	REFER TO HEAD OF WALL DETAILS FOR APPLICABLE CONDITION	UNDERSIDE OF STRUCTURE ABOVE	1" GYPSUM LINER PANEL	CH STUDS AT 24" O.C.	3" TYPE X GYPSUM BOARD	BASE AS SCHEDULED, TYP. BOTH SIDES	FLOOR ATTACHMENT		
PARTITION	FRAMING	STUD	INSUL.	DETAIL	FIRE	STC	REMARKS		
TAG	SPACING	SIZE	SOUND ATT. THICK.	HEAD OF WALL	RATING	TEST	RATING		
S2	24	2 1/2	-	-	1 HR	U415	33		
S4	24	4	-	-	1 HR	U415	34		

GENERAL PARTITION TYPE NOTES


- ALL PARTITION TYPES THIS SHEET MAY NOT BE USED. REFER TO PLANS FOR ALL APPLICABLE TYPES USED.
- PROVIDE 3/8" THICK TYPE 'X' GYPSUM WALL BOARD AT ALL LOCATIONS UNLESS OTHERWISE NOTED. (IN REMARKS ON PARTITION TYPE)
- ALL METAL STUD PARTITIONS TO EXTEND TO FLOOR/ ROOF DECK ABOVE, UNLESS OTHERWISE NOTED.
- METAL STUD MUST BE SIZED & SPACES SO AS NOT TO EXCEED DESIGN CRITERIA. MIN. STUD GAUGE = 25. PARTITIONS SHALL BE LIMITED IN 1/240 HEIGHT IN ACCORDANCE WITH NATH ASTM C754. REFER TO SPECIFICATIONS FOR ADDL. INFO.
- PROVIDE 3/8" TILE BACKER BOARD AT ALL CERAMIC TILE INSTALLATIONS AT TUB, SHOWER, KITCHENS AND PARTITIONS IN AREAS OF MOISTURE PRODUCING EQUIPMENT OR FIXTURES.
- PROVIDE FRAMING SPACES AT 12" O.C. MAX. AT ALL LOCATIONS WHERE PARTITIONS SUPPORT WALL CABINETS, AND 16" MAX. AT ALL CERAMIC TILE OR STONE VENEER WALLS.
- PROVIDE FIRE RATED SEALANT TO BOTH SIDES OF ENTIRE PERIMETER OF FIRE RATED WALLS AND AROUND ALL PENETRATIONS TO MEET APPLICABLE U.L. LISTING REQUIREMENTS OF WALL BEING PENETRATED.
- FASTENERS FOR ALL RUNNERS AND TRACKS SHALL BE AS PER MANUF. RECOMMENDATIONS BASED ON STUD SIZE, HEIGHT AND SPACING.
- BOTTOM EDGES OF WALLBOARD SHALL BE RAISED 1/4" ABOVE THE FLOOR.
- AT SOUND ATTENUATION WALLS, PROVIDE ACOUSTICAL CAULKING AROUND ALL PERIMETER EDGES AND PENETRATIONS. OFFSET ELECTRICAL DEVICES 16" MIN. (SEPARATE STUD CAVITIES)
- REFER TO FINISH SCHEDULE/PLANS FOR LOCATION AND TYPE OF FINISH MATERIALS FOR WALL TYPES INDICATING DIFFERENT FINISHES ON EACH SIDE OF WALL.
- REFER TO HEAD OF WALL DETAILS FOR ALL TOP OF PARTITION DETAILING.
- CONTRACTOR TO STAGGER ALL ELECTRICAL, COMMUNICATION, TELEPHONE AND OTHER SIMILAR OUTLET BOXES AT MIN. OF 12" O.C. IN FIRE RATED WALLS.
- PROVIDE IN-WALL BLOCKING FOR CABINETRY, TOILET ACCESSORIES, CLOSET SHELVING, MILLWORK, WALL STOPS, ARTWORK, WALL BUMPERS/GUARDS, DRAPEY LOCATIONS, STONEWORK, GRAB BARS, MODULAR OFFICE WALLS AND OTHER SIMILAR CONDITIONS.
- DEFLECTION TRACKS TO BE PROVIDED AT TOP RUNNERS OF ALL METAL STUD PARTITIONS THAT EXTEND TO UNDERSIDE OF STRUCTURAL DECK. TRACK MUST BE DESIGNED TO ALLOW UP TO 1/2" DEFLECTION UNLESS OTHERWISE NOTED.
- ALL SMOKE AND FIRE RATED PARTITIONS MUST BE IDENTIFIED W/ PAINTED STENCILS ABOVE CEILING.
- AT RATED ASSEMBLIES PROVIDE FIRE TREATED WOOD BLOCKING OR PLYWOOD INSIDE WALLS AND OTHER CONCEALED SPACES.
- CONTRACTOR TO VERIFY ALL DIMENSIONS IN FIELD AND NOTIFY ARCHITECT OF ANY DISCREPANCIES PRIOR TO PARTITION INSTALLATION.
- ALL EXPOSED TOP EDGES OF WALLS OR WHERE WALL ABUTS A DIFFERENT MATERIAL OR OTHER CONCRETE STRUCTURE TO HAVE A ZIP BEAD FINISH.
- IF SOUND ATTENUATION IS REQUIRED PER PARTITION TAG, PROVIDE ATTENUATION THICKNESS TO FILL STUD CAVITY.
- DEFAULT CONDITION IS TO EXTEND GYPSUM BOARD 6" ABOVE FINISHED CEILING BUT DEFER TO THE REMARKS FOR EXTENTS OF GYPSUM FOR OTHER CONDITIONS.
- TYPICAL METAL STUD DETAILS, TOP OF THIS SHEET, SHALL BE REFERENCED WHEN APPLICABLE. NOT ALL DETAILS ARE USED. CONTRACTOR TO APPLY DETAILS WHEN REQUIRED.

PARTITION TAG LEGEND


FRAMING SIZE	TYPE IDENTIFICATION	
A, B, C, D, E, F & G	X X X X	
FIRE RATING IF APPLICABLE		SPECIAL CONDITIONS
X = 1 HOUR		R+ STUD DOES NOT EXTEND TO DECK ABOVE
Y = 2 HOURS		N+ TERMINATE GYPSUM BD. 6" ABOVE CLG
Z = 3 HOURS		S+ SOUND ATTENUATION
		L+ LOAD BEARING

DIAGRAMS AND NOTES

- PARTITION TYPES ARE INDICATED IN SQUARE BOX SYMBOLS LINKED TO THE WALL THEY DESCRIBE.
- THE PARTITION TYPE EXTENDS THE ENTIRE LENGTH OF THE WALL WHERE IT IS SHOWN, ACROSS DOORS, WINDOWS AND MINOR PROJECTIONS OR RECESSES (E.G. AT WATER FOUNTAINS). THE PARTITION TYPE ENDS AT THE INTERSECTION WITH ANOTHER SPACE, DEFINED BY AN INSIDE OR OUTSIDE CORNER, INCLUDING INTERVENING CORRIDORS, UNLESS OTHERWISE SPECIFICALLY NOTED ON THE DRAWINGS. SEE EXAMPLES BELOW.
- THE INDICATED PARTITION TYPES INCLUDE ALL SIDES OF MINOR PROJECTIONS OR ALCOVES, SUCH AS RECESSED DOORS, HEADS OVER DOORS AND WINDOWS. SEE EXAMPLES BELOW.

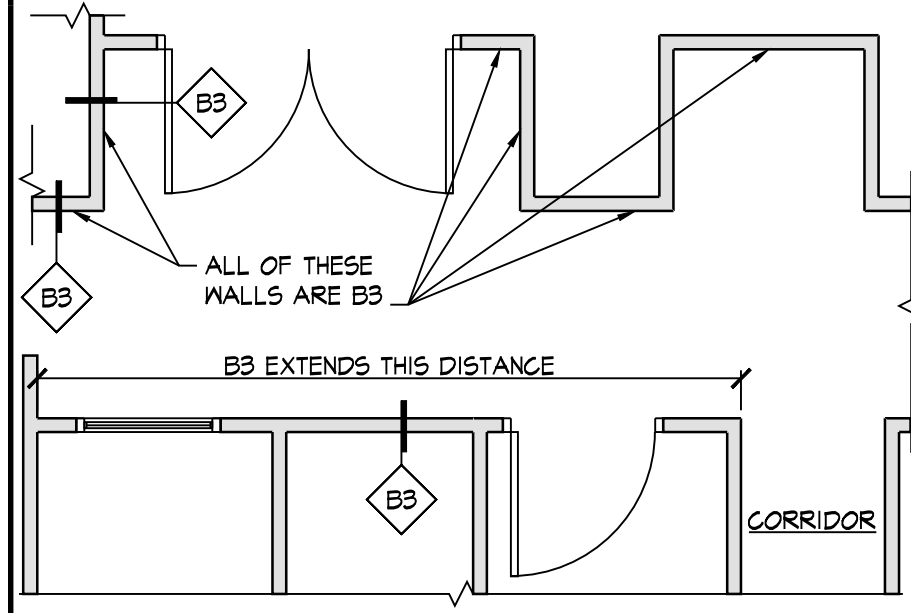

TYPICAL DOOR DETAIL

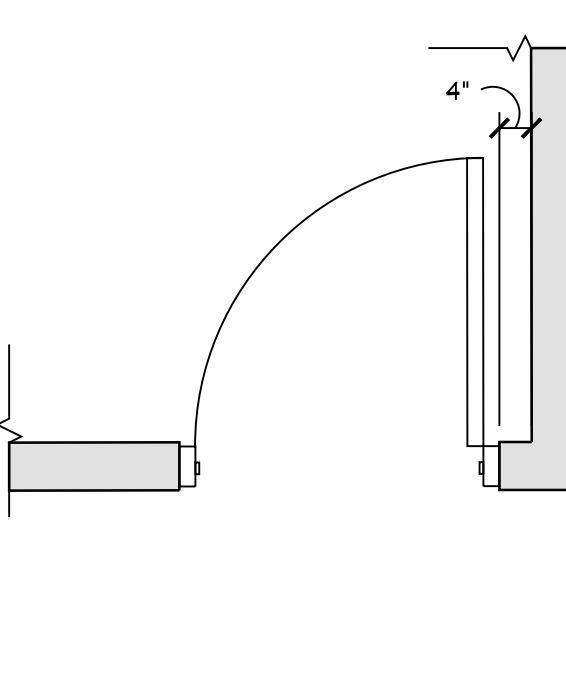

REV: DATE: DESCRIPTION:

TYPICAL PARTITION TYPES & DETAILS

PROJECT NO.: 2551 DRAWN BY: DD

DATE ISSUED: 3/30/2026

SHEET NO.:

A-4.0



tm

TOKARSKI + MILLEMAN
ARCHITECTS, LLC

1729 ROUTE 35
WALL, NEW JERSEY 07719
phone 732.262.0046
facsimile 732.262.0045
Email info@tm-architects.com

Michael J. Millemann, AIA

N.J. LICENSE # A114550
N.Y. LICENSE # 028885

CERTIFICATE OF AUTHORIZATION
No. AC33200

LATRINE ALTERATIONS FOR:
MT HOLLY ARMORY
1670 NJ-38
MT HOLLY, NEW JERSEY 08060
DMA PROJECT NO. MH008

REV: DATE: DESCRIPTION:


DETAILS

PROJECT NO.: 2551 DRAWN BY: DD

DATE ISSUED: 3/30/2026


SHEET NO.:

A-4.2

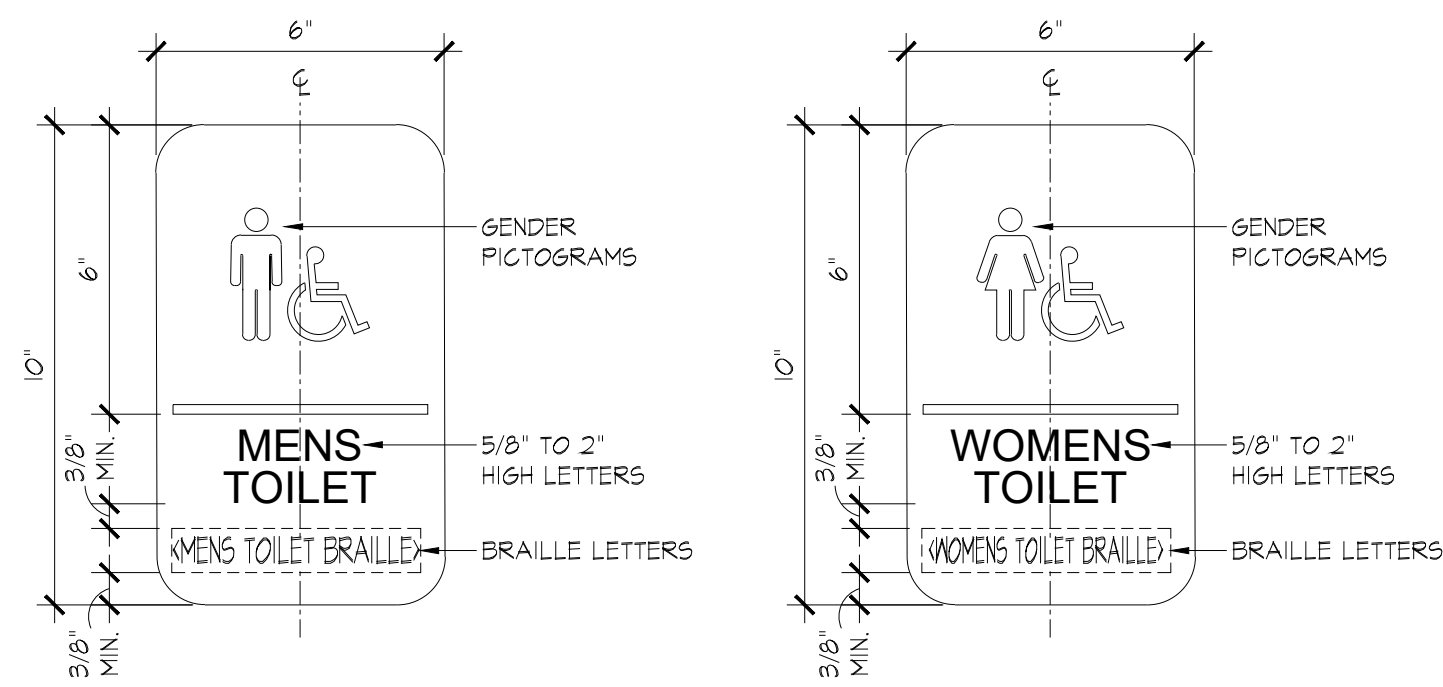


ACCESSIBLE TOILET ROOM PLAQUE
SIGNAGE NOTES:
SIGN TEXT BRAILLE AND PICTOGRAM CHARACTERISTICS ARE DESCRIBED IN ANSI/ICC A117.1-2017
SIGNAGE TO BE MOUNTED ON THE LATCH SIDE OF SINGLE DOORS, UNLESS OTHERWISE NOTED
REFER TO TYPICAL MOUNTING HEIGHTS DIAGRAM FOR ADDITIONAL INFORMATION


9 TYPICAL SIGNAGE DETAIL
3'-11'-0"

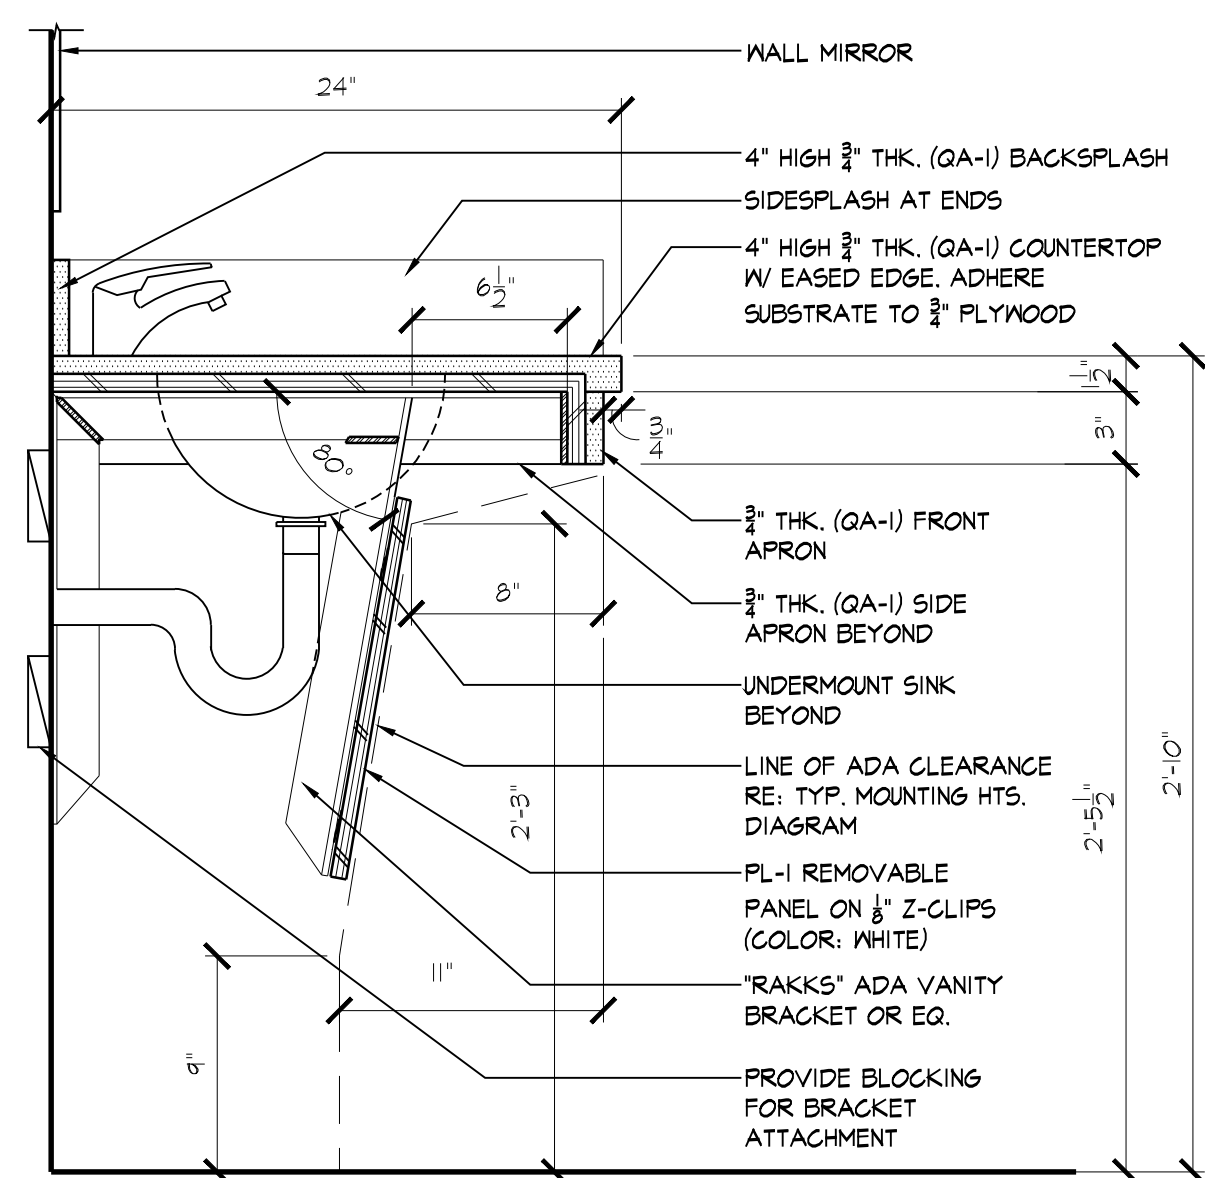


5 STANDARD COUNTER DETAIL
1'-1/2"-1'-0"

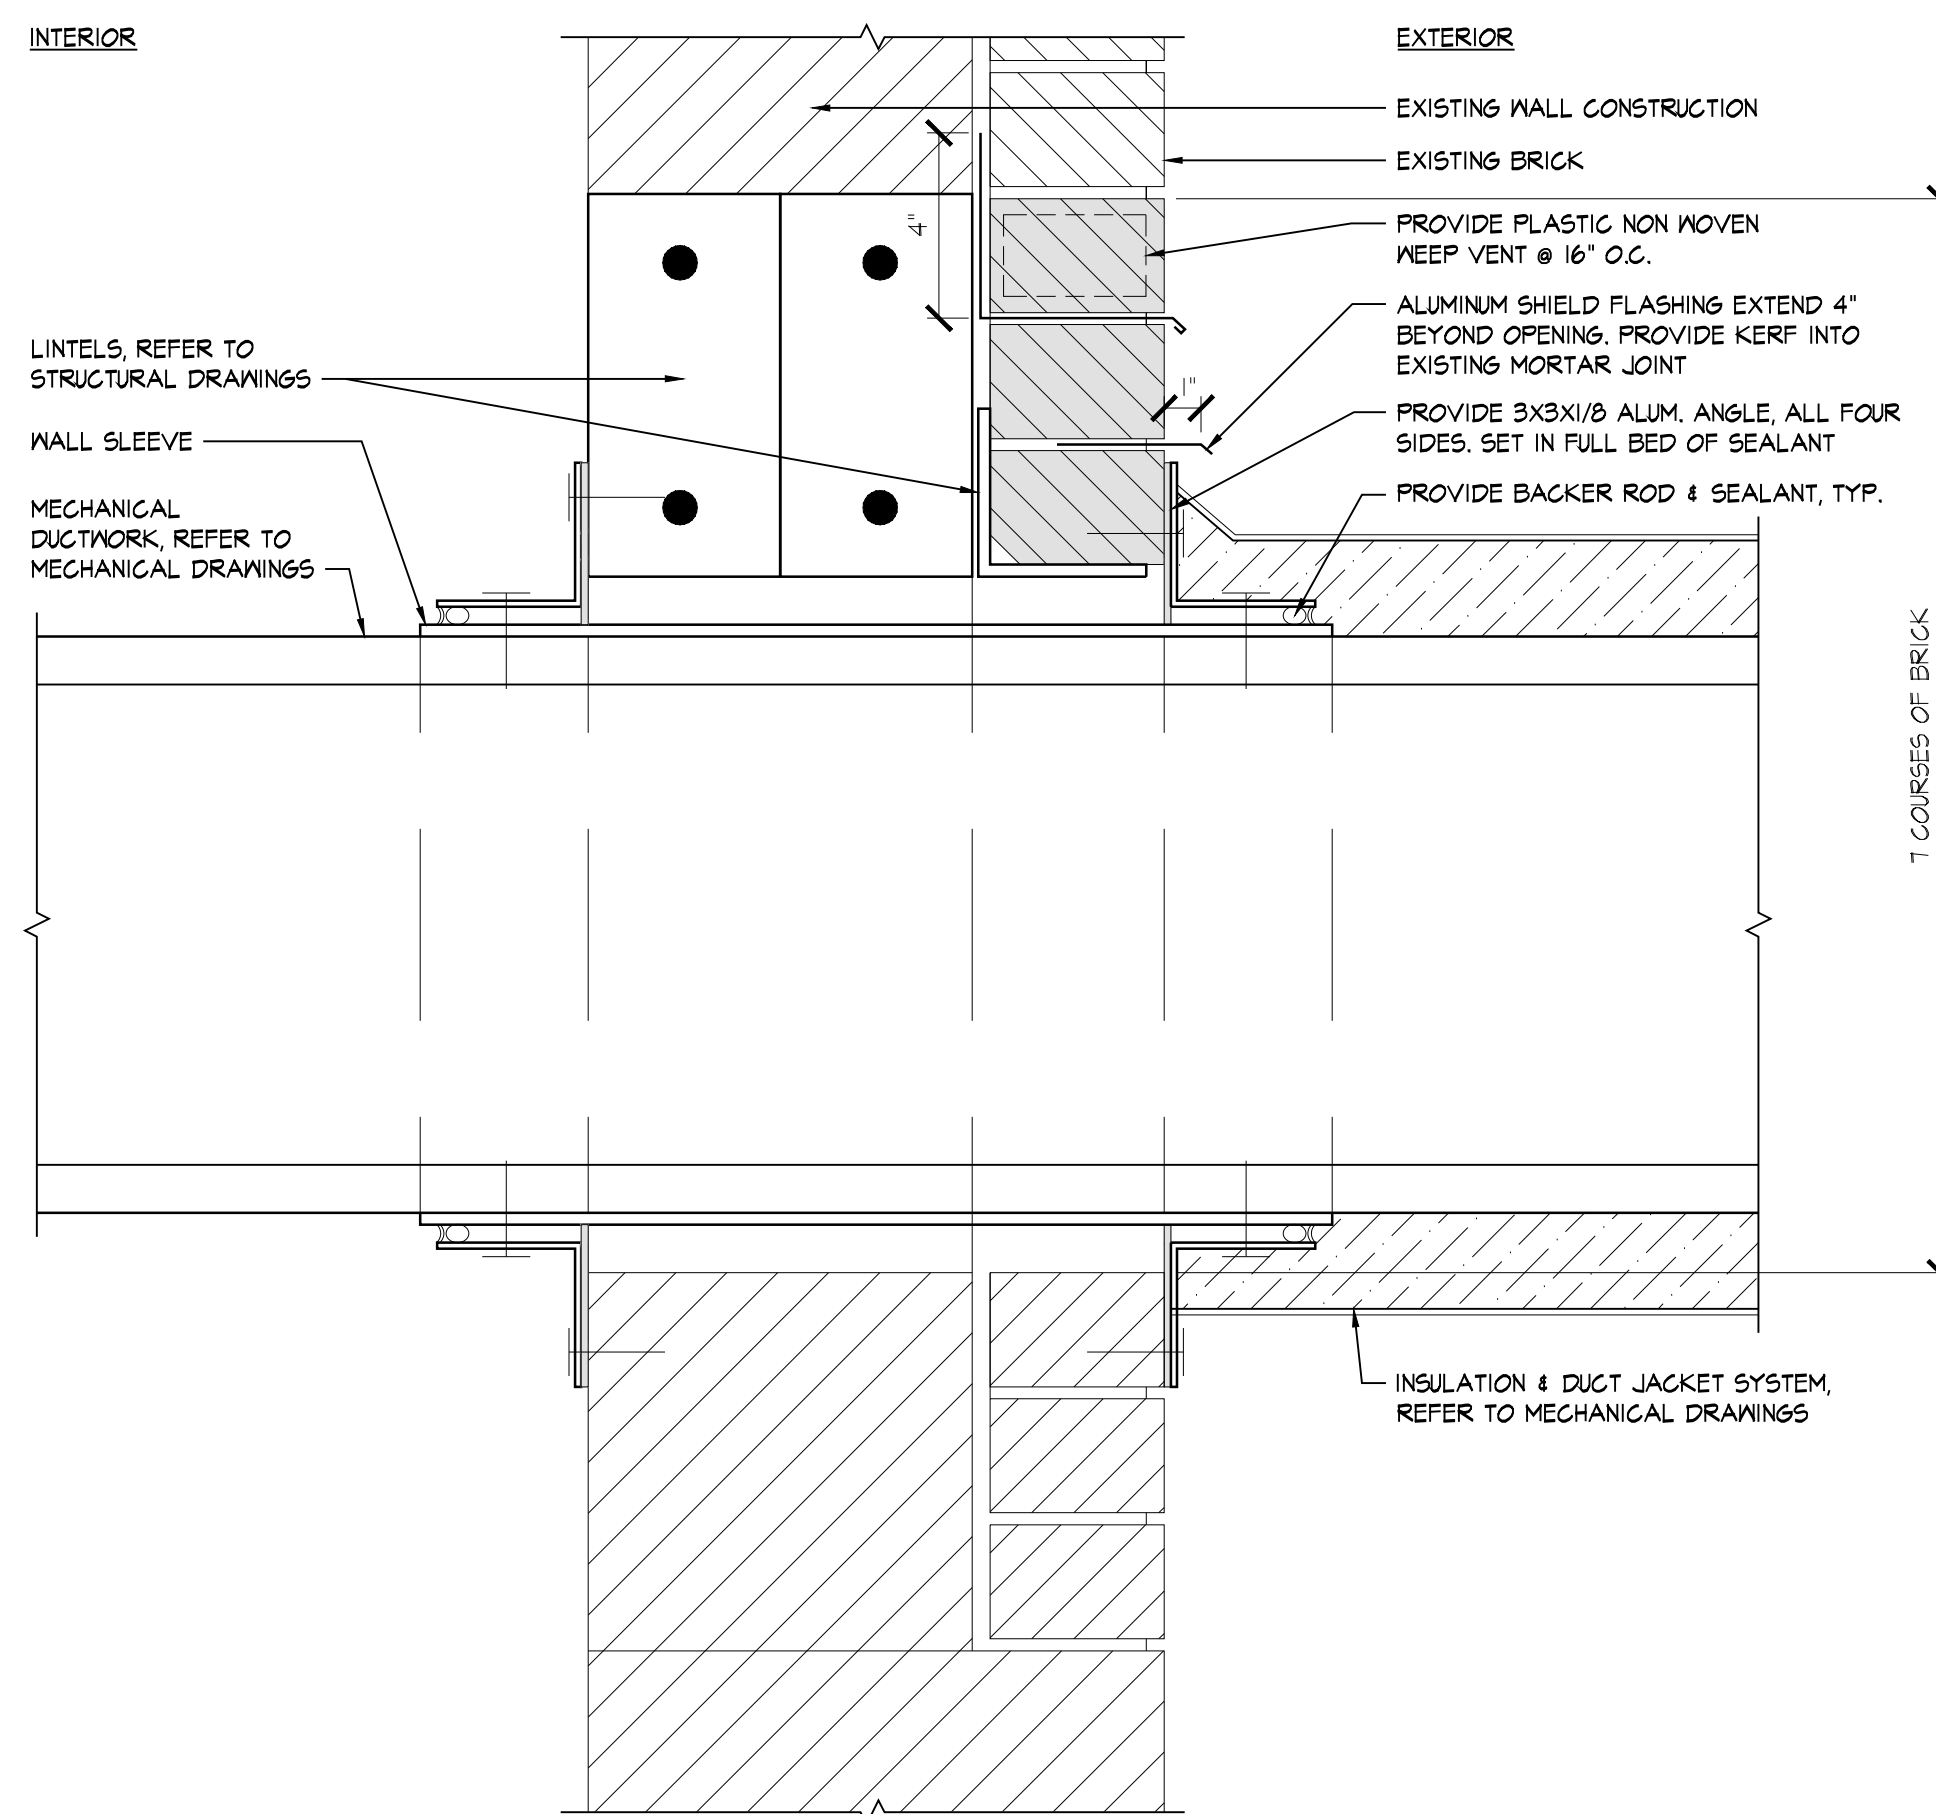


8 SECTION THRU OUTSIDE WALL AT DUCT PENETRATION
3'-11'-0"

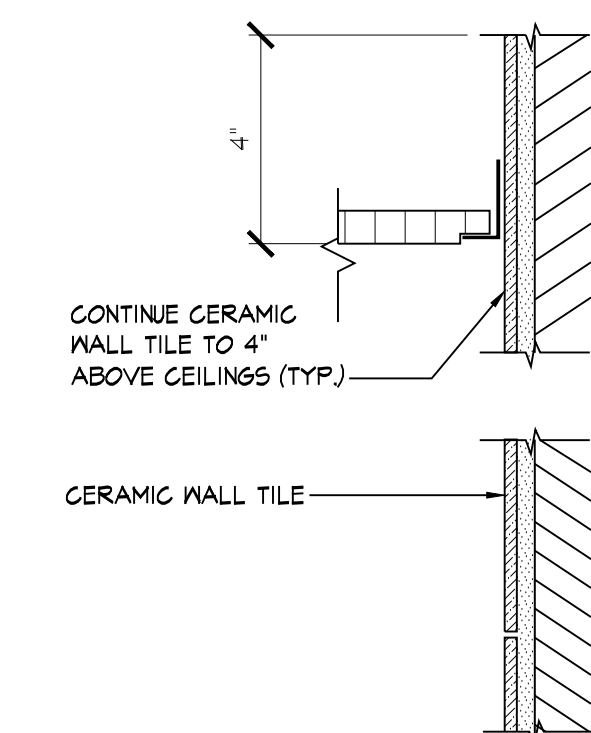


4 TYPICAL TILE DETAIL
3'-1'-0"

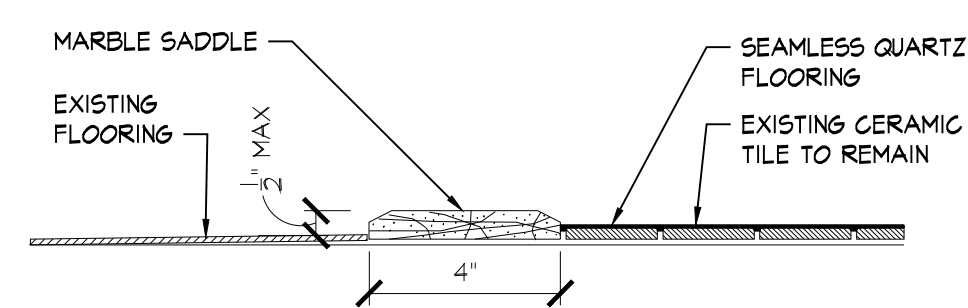


3 SADDLE DETAIL
3'-1'-0"

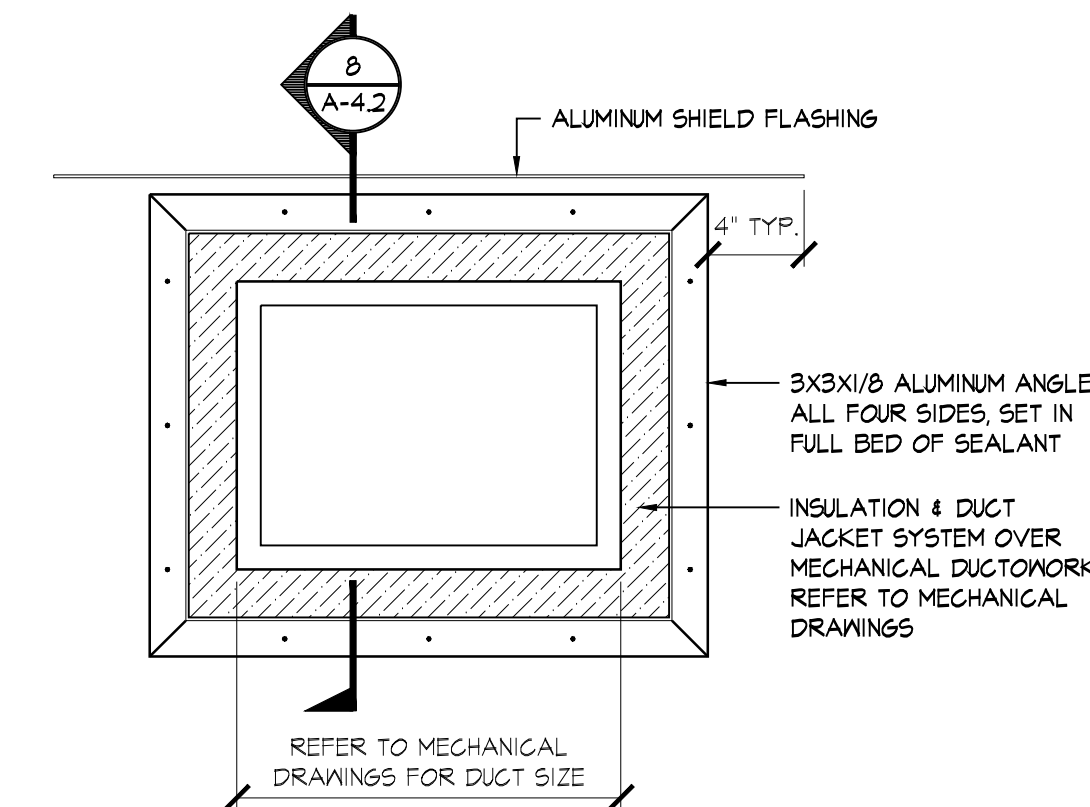


7 DUCT PENETRATION ELEVATION DETAIL
1'-1/2"-1'-0"

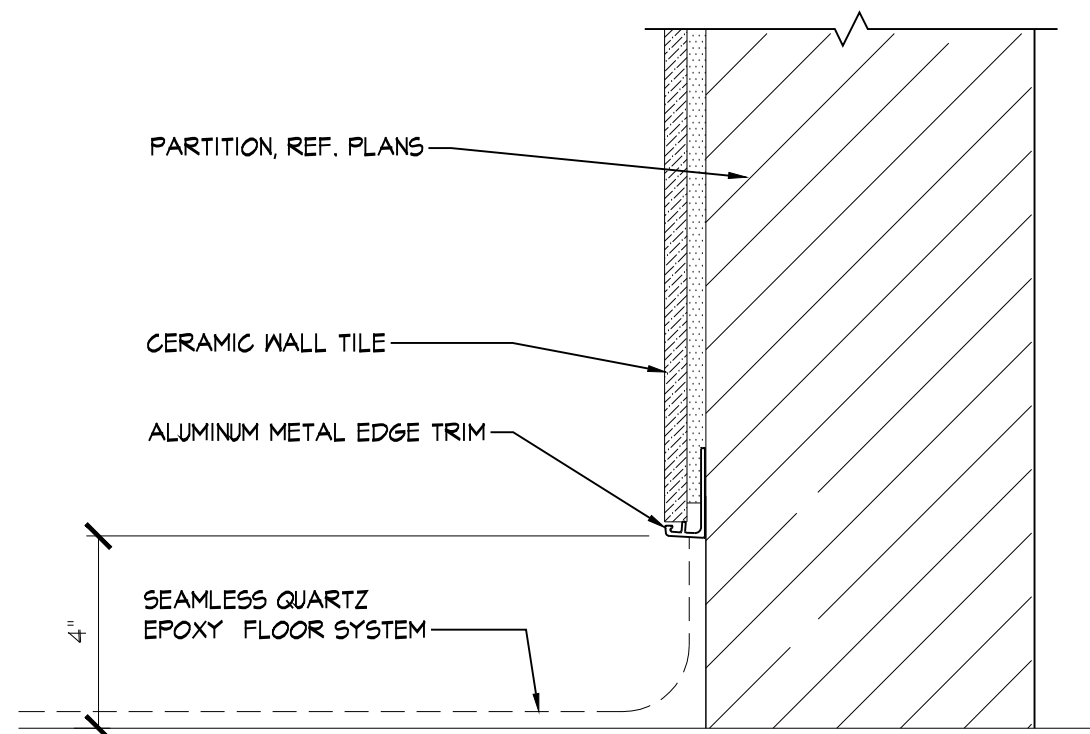


2 TYPICAL COVE BASE DETAIL
3'-1'-0"

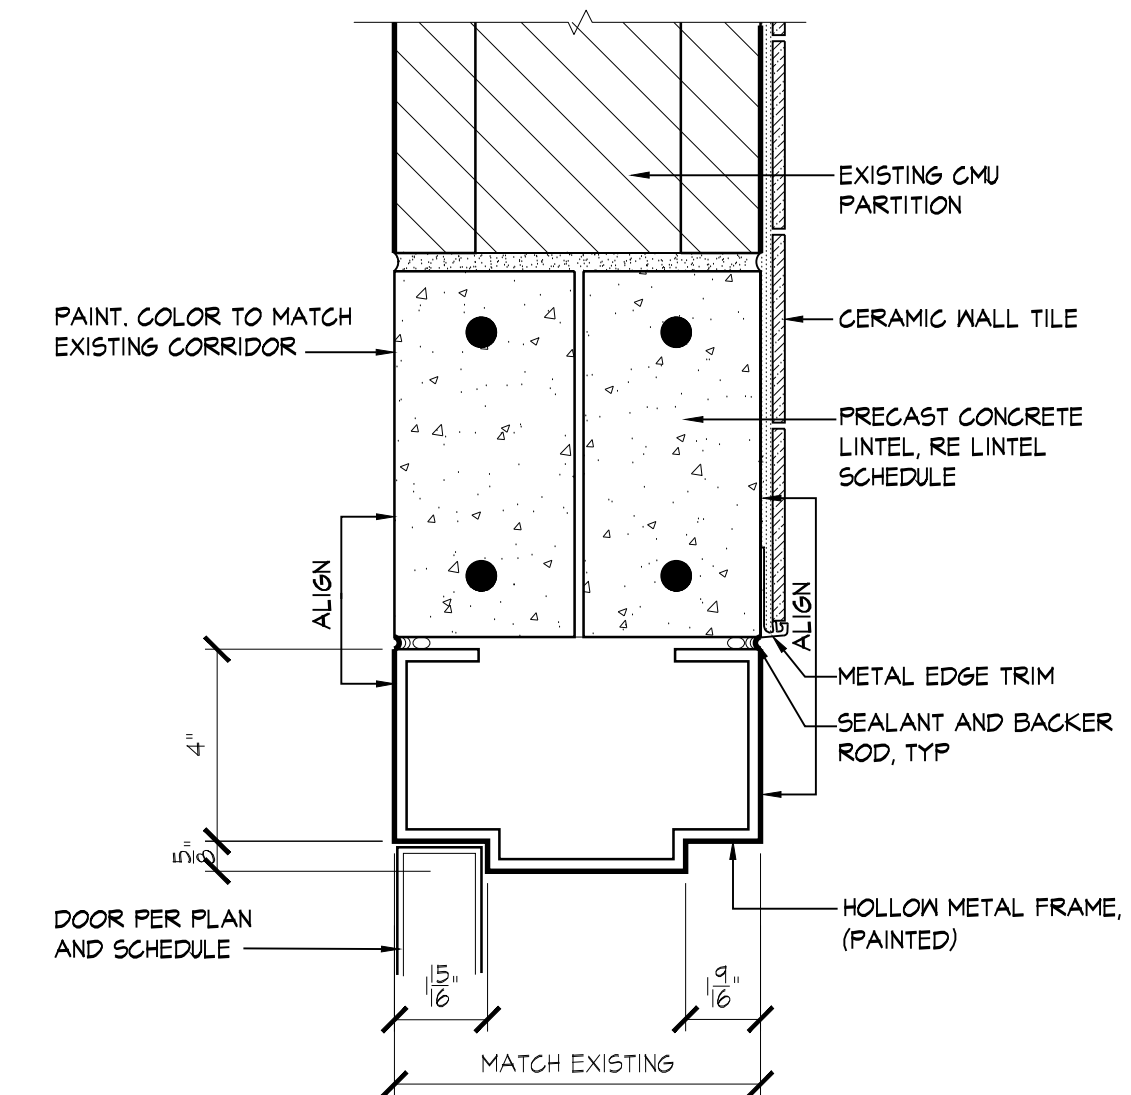

10 DOOR HEAD DETAIL
3'-1'-0"

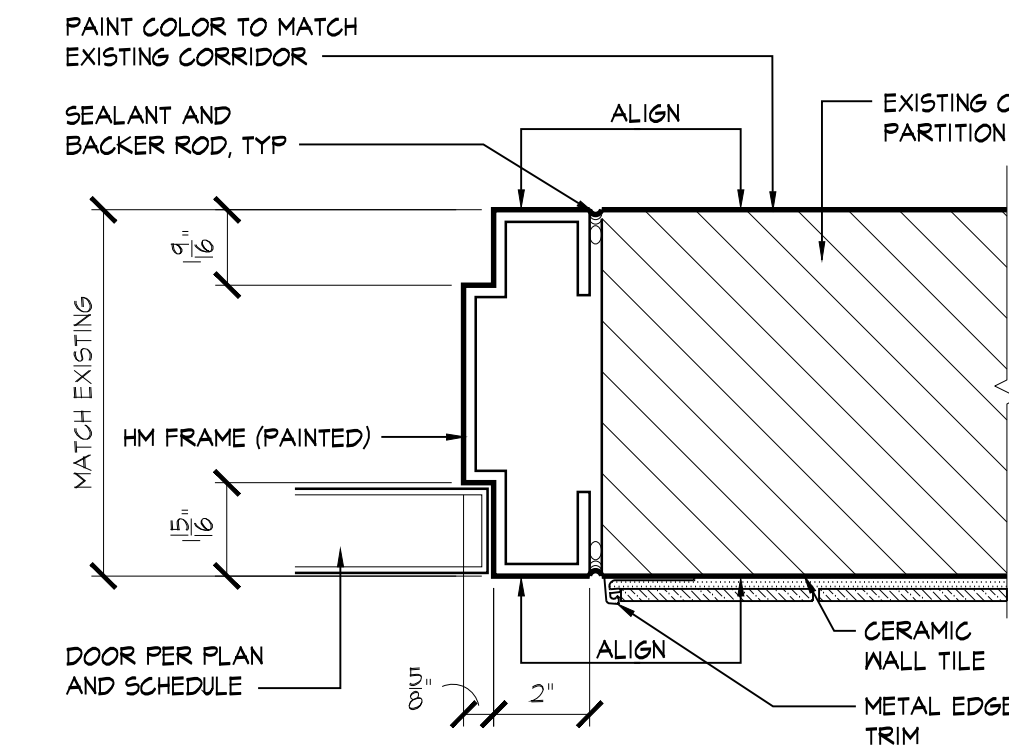

6 DOOR JAMB DETAIL
3'-1'-0"

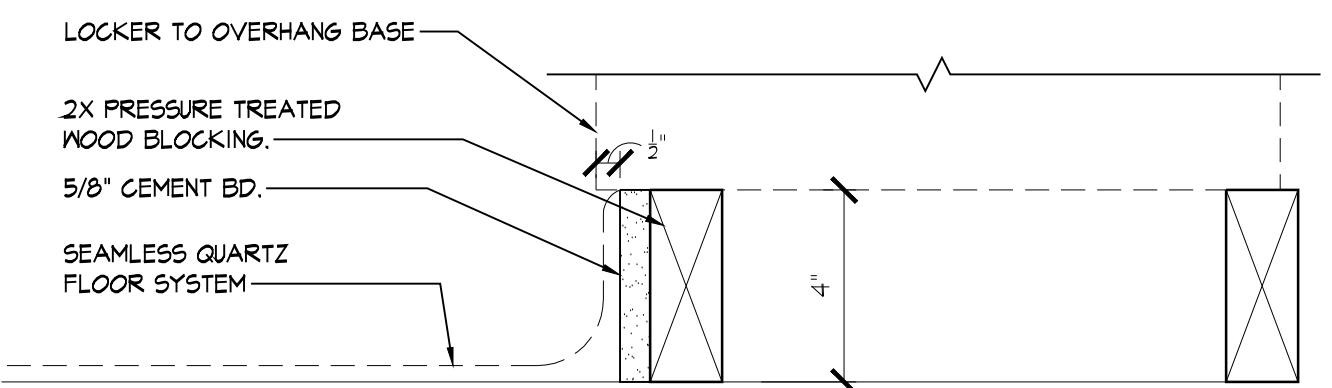

1 TYPICAL LOCKER BASE DETAIL
3'-1'-0"

PROJECT GENERAL NOTES

GENERAL ABBREVIATIONS

MECHANICAL SYMBOLS

GENERAL NOTES

- MOTOR CONTROLLERS, MOTOR STARTERS & DISCONNECTS SHALL BE FURNISHED BY DIVISION 23 AND INSTALLED UNDER DIVISION 26.
- POWER WIRING TO MECHANICAL EQUIPMENT, MOTOR CONTROLLERS AND CONTROL PANELS SHALL BE PROVIDED UNDER DIVISION 26.
- HVAC CONTROL WIRING SHALL BE PROVIDED UNDER DIVISION 23.
- DISCONNECT SWITCHES SHALL BE HEAVY DUTY TYPE WITH LOCKABLE HANDLE. DISCONNECTS FOR ALL ELECTRICALLY DRIVEN HVAC EQUIPMENT SHALL BE FURNISHED BY DIVISION 23 AND INSTALLED BY DIVISION 26.
- STARTERS SHALL BE NEMA COMBINATION MAGNETIC MOTOR STARTERS SIZED PER MOTOR HORSE POWER. COORDINATE MOTOR STARTER TYPE AND FEATURES WITH THE REQUIREMENTS OF THE MECHANICAL EQUIPMENT AND THE CONTROL SYSTEM. PROVIDE OVERLOAD, UNDER VOLTAGE AND PHASE LOSS PROTECTION IN ALL STARTERS. STARTERS FOR MOTORS 50 HORSE POWER AND LARGER SHALL BE REDUCED VOLTAGE TYPE.
- DUCTWORK AND PIPING LAYOUTS ARE SCHEMATIC DIAGRAMS AND ARE INTENDED TO SHOW GENERAL ARRANGEMENT, SIZE AND CAPACITY AND DO NOT INDICATE WHICH PIPE OR DUCT IS ABOVE OR BELOW THE OTHER. ALL OFFSETS ARE NOT NECESSARILY SHOWN. CONTRACTOR SHALL ARRANGE AND COORDINATE THE WORK. FURNISH NECESSARY OFFSETS, VALVES, VENTS, AND FITTINGS TO AVOID CONFLICT WITH OTHER MECHANICAL AND ELECTRICAL SERVICES AND STRUCTURAL AND ARCHITECTURAL ELEMENTS WITHOUT ADDITIONAL COST TO THE OWNER. IF AREAS OF CONFLICT ARE ENCOUNTERED, THE ENGINEER SHALL BE NOTIFIED AND CONTRACTORS' RECOMMENDATIONS SHALL BE SUBMITTED TO THE ENGINEER FOR APPROVAL BEFORE WORK HAS BEGUN.
- ENTIRE INSTALLATION SHALL COMPLY WITH ALL LOCAL AND STATE CODES AND OTHER AUTHORITIES HAVING JURISDICTION.
- CONTRACTOR SHALL SECURE AND PAY FOR ALL REQUIRED PERMITS AND SHALL ARRANGE ALL REQUIRED INSPECTIONS.
- PROPER FIRE PROTECTION MEASURES, SATISFACTORY TO THE LOCAL FIRE DEPARTMENT SHALL BE TAKEN WHEN WELDING OR CUTTING WITH TORCHES OR ELECTRIC ARC.
- PROVIDE FLEXIBLE CONNECTIONS ON ALL ROTATING EQUIPMENT.
- CONTRACTOR SHALL PROVIDE ALL NECESSARY MISCELLANEOUS STEEL FOR THE SUPPORT OF ALL EQUIPMENT, PIPING, CONDUIT, AND DUCTWORK. SUSPEND FROM SLAB, STEEL, WALL, OR TRUSS WORK.
- BALANCE AND CERTIFY ALL AIR AND WATER SYSTEMS AS PER SPECIFICATIONS.
- CONTRACTOR SHALL COORDINATE HIS WORK WITH THE WORK OF ALL OTHER TRADES AND THE EXISTING SHUT OFF CONDITIONS.
- PROVIDE SHUT OFF VALVES AT ALL BRANCH PIPING CONNECTIONS.
- CONTRACTOR SHALL BE RESPONSIBLE FOR ALL CUTTING AND PATCHING OF SLAB REQUIRED AS A RESULT OF HIS WORK.
- MINIMUM SIZE OF ALL CONDENSATE DRAIN PIPING SHALL BE 3/4". MINIMUM SLOPE SHALL BE 1/8" PER FOOT.
- ALL MECHANICAL CONTROLS (THERMOSTATS, ETC.) SHALL BE FURNISHED AND INSTALLED AS PER BARRIER-FREE SUB-CODE OF THE LOCAL GOVERNING CODE.
- UNLESS OTHERWISE NOTED ON THE DRAWINGS, ALL MECHANICAL EQUIPMENT SHALL BE MOUNTED ON VIBRATION ISOLATORS TO PREVENT THE TRANSMISSION OF SOUND TO THE BUILDING STRUCTURE. VIBRATION ISOLATORS SHALL BE IN ACCORDANCE WITH THE SPECIFICATIONS AND ON ACTUAL WEIGHT DISTRIBUTION OF THE EQUIPMENT FURNISHED. DEFLECTIONS SHALL BE AS NOTED ON THE EQUIPMENT SHOP DRAWING SUBMITTALS.
- ALL CONDENSATE DRAIN LINES SHALL COMPLY WITH NSPC.
- ALL PENETRATIONS OF FLOORS (WHETHER OR NOT FIRE RESISTANCE RATED) AND ALL PENETRATIONS OF FIRE RATED WALLS AND FLOORS SHALL BE PROVIDED WITH A THROUGH PENETRATION PROTECTION SYSTEM (FIRE STOPPING). EACH THROUGH-PENETRATION PROTECTION SYSTEM SHALL BE TESTED IN ACCORDANCE WITH ASTM E814 AND BE LISTED FOR THE TYPE OF FLOOR OR WALL ASSEMBLY PENETRATED AND THE TYPE OF PROTECTION SYSTEM. REFER TO SECTION OF THE SPECIFICATION FOR ADDITIONAL INFORMATION.
- ALL REMOVED EQUIPMENT, MATERIAL AND DEBRIS SHALL BE LEGALLY DISPOSED OF BY THIS CONTRACTOR.
- CONTRACTOR SHALL ENSURE THAT ALL MECHANICAL DEVICES WILL BE INSTALLED IN A LOCATION WHICH AFFORDS ACCESSIBILITY FOR MAINTENANCE AND REPAIR. COORDINATE INSTALLATION AMONG ALL TRADES TO AVOID INTERFERENCE, AND LOCATE EQUIPMENT TO PROVIDE CLEARANCE OR EXCEED THOSE RECOMMENDED BY THE MANUFACTURER.
- INSTALL ALL DIELECTRIC UNIONS IN A MANNER WHICH MAKE THEM READILY ACCESSIBLE FOR FUTURE REPAIR OR REPLACEMENT.
- CONTRACTOR SHALL DRAIN AND REFILL ALL PIPING AS REQUIRED.
- FURNISH LOCAL DISCONNECT SWITCHES FOR ALL ELECTRICALLY DRIVEN HVAC EQUIPMENT. DISCONNECT SWITCH SHALL BE IN ACCORDANCE WITH MANUFACTURER'S REQUIREMENTS.
- CONTRACTOR SHALL VISIT JOB SITE AND VERIFY EXISTING CONDITIONS PRIOR TO SUBMISSION OF BID.
- ALL INTERIOR PIPING SHALL BE SUPPORTED FROM THE STRUCTURE ABOVE.
- ALL CONTROL WIRING SHALL BE INSTALLED IN CONDUIT IF RUN IN MECH ROOM OR OPEN TO DAMAGE. WIRING ABOVE CEILING OR CONCEALED LOCATIONS (SAFE FROM DAMAGE) CAN BE ROUTED AS PLENUM RATED CABLE.
- WHERE PIPING CONNECTIONS FOR THE EQUIPMENT SUCH AS PUMPS, AC UNITS, COILS, ETC., DIFFER FROM THE LINE SIZE, IT SHALL BE THE RESPONSIBILITY OF THE MECHANICAL CONTRACTOR TO FURNISH AND INSTALL THE NECESSARY REDUCERS OR EXPANDER FITTINGS TO ENABLE CONNECTION BETWEEN THE PIPING SYSTEM AND THE EQUIPMENT.
- ALL DRAINAGE PIPING SHALL BE SLOPED AT A MINIMUM OF 1/8" PER FOOT.
- ALL INSULATION PROVIDED FOR THE PROJECT MUST MEET A MINIMUM FLAME SPREAD RATING OF 25 AND SMOKE DEVELOPED OF 50 OR LESS, AS TESTED IN ACCORDANCE WITH ASTM, NFPA & U.L. GUIDELINES.
- ALL EQUIPMENT FOR THIS PROJECT SHALL BE LISTED BY A NATIONALLY RECOGNIZED TESTING LABORATORY.
- CONTRACTOR SHALL SUBMIT DIMENSIONED, COORDINATED SHOP DRAWINGS FOR ENGINEERS' APPROVAL. DRAWING SHALL INDICATE ALL TRADES, (ELECTRICAL, MECHANICAL, PLUMBING, FIRE PROTECTION AND INFRASTRUCTURE).
- THE CONTRACTOR SHALL PROVIDE THE OWNER WITH A ONE (1) YEAR WRITTEN GUARANTEE OF ALL WORK (LABOR AND MATERIALS) STARTING FROM THE DATE OF ISSUANCE OF SUBSTANTIAL COMPLETION.
- UNLESS OTHERWISE SPECIFIED, ALL MOTORS 1/2 H.P. AND ABOVE SHALL BE 3 PHASE AND MOTORS UNDER 1/2 H.P. SHALL BE SINGLE PHASE.
- THE MECHANICAL CONTRACTOR SHALL COORDINATE THE ELECTRICAL REQUIREMENTS OF HIS WORK WITH THE GENERAL AND ELECTRICAL CONTRACTORS PRIOR TO SUBMISSION OF BIDS.
- CONTRACTOR TO PATCH ALL DISTURBED FINISHES WITH MATERIAL AND ASSEMBLIES TO MATCH EXISTING ADJACENT SURFACES AND FINISHES.

IDENTIFIER	DESCRIPTION	IDENTIFIER	DESCRIPTION
ATF	ABOVE FINISHED FLOOR	MC	MECHANICAL CONTRACTOR
AFG	ABOVE FINISHED GRADE	MCA	MINIMUM CIRCUIT AMPS
ATC	AUTOMATIC TEMPERATURE CONTROLS	MEZZ	MEZZANINE
BFG	BELOW FINISHED GRADE	MFG	MANUFACTURER
BUDG	BUILDING	MH	MOUNTING HEIGHT
CONN'S	CONNECTIONS	MN	MINIMUM
CLG	CEILING	MOD	MOTOR OPERATED DAMPER
CO	COMPANY	MTD	MOUNTED
CONTR.	CONTRACTOR	NC	NORMALLY CLOSED
CTE	CONNECT TO EXISTING	NC	NOT IN CONTRACT
DN	DOWN	NO	NORMALLY OPEN
DWG(S)	DRAWING(S)	NTS	NOT TO SCALE
EC	ELECTRICAL CONTRACTOR	OC	ON CENTER
EM	EMERGENCY	PC	PLUMBING CONTRACTOR
EQUIP	EQUIPMENT	PSI	POUNDS PER SQUARE INCH
ETR	EXISTING TO REMAIN	PVC	POLYVINYL CHLORIDE
EW	ELECTRIC WATER COOLER	R	EXISTING EQUIPMENT TO BE REMOVED
EX	EXISTING	REL	EXISTING EQUIPMENT TO BE RELOCATED
FLA	FULL LOAD AMPS	RLA	RUNNING LOAD AMPS
FS	FLOW SWITCH	RPM	REVOLUTIONS PER MINUTE
GC	GENERAL CONTRACTOR	SDD	DUCT SMOKE DETECTOR
HP	HORSEPOWER	SQ. FT.	SQUARE FEET
MAX	MAXIMUM	TYP	TYPICAL
		VSD	VARIABLE SPEED DRIVE

* NOTE THAT NOT ALL ABBREVIATIONS APPLY TO THE PROJECT * NOTE THAT NOT ALL ABBREVIATIONS APPLY TO THE PROJECT

MECHANICAL ABBREVIATIONS

CFM	CUBIC FEET PER MINUTE	S/A	SUPPLY AIR
CR	CEILING REGISTER	SD	SMOKE DAMPER
CU	CONDENSING UNIT	SE	SMOKE EXHAUST
CW	COLD WATER	SF	SUPPLY FAN
DB	DRY BULB	SR	SUPPLY REGISTER
DN	DOWN	T	THERMOSTAT
E/A	EXHAUST AIR	TO	TRANSFER GRILLE
EAT	ENTERING AIR TEMPERATURE	TR	TRANSFER OPENING
EDB	ENTERING DRY BULB	TT	THERMOSTATIC TRAP
EER	ENERGY EFFICIENCY RATIO	UH	UNIT HEATER
EG	EXHAUST GRILLE	UV	UNIT VENTILATOR
EH	ELECTRIC HEATER	VO	VOLUME DAMPER
ESP	EXTERNAL STATIC PRESSURE	WB	WET BULB
EWB	ENTERING WET BULB	W.C.	WATER COLUMN
EF	EXHAUST FAN	WG	WATER GAUGE
FD	FIRE DAMPER WITH ACCESS DOOR	WMS	WIRE MESH SCREEN
FFM	FEET PER MINUTE	XEF	EXISTING EXHAUST FAN
G	GAS	XB	EXISTING BOILER
GPM	GALLONS PER MINUTE	X	EXISTING
HX	HEAT EXCHANGER	UV	UNIT VENT
LAT	LEAVING AIR TEMPERATURE	VAV	VARIABLE AIR VOLUME
MAU	MAKE UP AIR UNIT	RTU	ROOFTOP UNIT
MBH	THOUSAND BTU PER HOUR	SCUV	SELF CONTAINED UNIT VENT
MOD	MOTOR OPERATED DAMPER	CONV	CONVECTOR
N.C.	NORMALLY CLOSED	FTF	FIN TUBE RADIATION
N.O.	NORMALLY OPEN	CUH	CABINET UNIT HEATER
O/A	OUTSIDE AIR	XEF	EXISTING EXHAUST FAN
OAI	OUTSIDE AIR INTAKE	XR	EXISTING RETURN GRILLE
OED	OPEN ENDED DUCT	XS	EXISTING SUPPLY DIFFUSER
P	PUMP	XRH	EXISTING REHEAT COIL
R/A	RETURN AIR	XSP	EXISTING SMOKE PURGE GRILLE
RAV	RELIEF AIR VENT	XVAV	EXISTING VAV BOX
RG	RETURN GRILLE		
RH	RELATIVE HUMIDITY		
RR	RETURN REGISTER		

* NOTE THAT NOT ALL ABBREVIATIONS APPLY TO THE PROJECT * NOTE THAT NOT ALL ABBREVIATIONS APPLY TO THE PROJECT

IDENTIFIER	DESCRIPTION	IDENTIFIER	DESCRIPTION
HWS	HEATING HOT WATER SUPPLY	REDUCER (ECCENTRIC)	
HWR	HEATING HOT WATER RETURN	VALVE ON RISER	
CD	CONDENSATE DRAIN	ANGLE VALVE	
PC	PUMPED CONDENSATE	PRESSURE RELIEF VALVE	
V	EQUIPMENT VENT	CONTROL VALVE (2-PORT)	
PR	PRESSURE REDUCING VALVE (SELF-CONTAINED)	CONTROL VALVE (3-PORT)	
PR	PRESSURE REDUCING VALVE (REMOTE TYPE)	PIPE ANCHOR	
SG	STEAM PRESSURE GAUGE W/ SHUT-OFF	MOMENT GUIDES	
SG	PRESSURE GAUGE W/ SHUT-OFF	OPEN-ENDED PIPE	
TM	THERMOMETER W/ SHUT-OFF	PIPE TO BE DEMOLISHED	
Y	Y-TYPE STRAINER W/ BLOWDOWN & HOSE BIBB	CONNECT TO EXISTING	
UN	UNION	DUCT UNDER POSITIVE PRESSURE	
MA	MANUAL AIR VENT	DUCT UNDER NEGATIVE PRESSURE	
AV	AUTOMATIC AIR VENT	ROUND DUCT	
PT	PIPE TURNING UP	SUPPLY REGISTER	
PD	PIPE TURNING DOWN	RETURN OR EXHAUST REGISTER	
FD	FITCH DOWN	VOLUME DAMPER	
DF	DIRECTION OF FLOW	FIRE DAMPER W/ACCESS DOOR	
CP	CAPPED PIPE	BACKDRAFT DAMPER	
EX	EXPANSION JOINT	MOTORIZED DAMPER	
BV	BALL VALVE	AIRFLOW THRU UNDERCUT	
SCV	SWING TYPE CHECK VALVE	AIRFLOW THRU LOUVERED DOOR	
GV	GATE VALVE	THERMOSTAT (WALL MOUNTED)	
GV	GLOBE VALVE	AIR DEVICE TYPE	
BV	BUTTERFLY VALVE	AIR QUANTITY	
CBV	CALIBRATED BALANCING VALVE	DUCTWORK TO BE DEMOLISHED	
TDV	TRIPLE-DUTY VALVE	SENSOR	
RC	REDUCER (CONCENTRIC)	FLEXIBLE CONNECTION	
GC	GAS COOK	EXISTING DUCTWORK TO REMAIN	
PR	PRESSURE REGULATOR (LOCK UP TYPE)	THERMOMETER	
GP	GAS PIPING	PUMP	
SP	SANITARY SEWER PIPING	EXISTING SUPPLY DIFFUSER	
SV	SANITARY VENT PIPING	EXISTING RETURN OR EXHAUST GRILLE	
XX	EQUIPMENT TYPE		
XX	EQUIPMENT ID NUMBER		

* NOTE THAT NOT ALL SYMBOLS APPLY TO THE PROJECT

HVAC DESIGN CRITERIA

- APPLICABLE CODES AND REFERENCES:
 - INTERNATIONAL BUILDING CODE - 2021
 - ASHRAE / IEA STANDARD 90.1 - 2020
 - INTERNATIONAL MECHANICAL CODE - 2021
 - INTERNATIONAL FUEL GAS CODE - 2021
 - NATIONAL STANDARD PLUMBING CODE - 2021
 - UNIFORM CONSTRUCTION CODE OF NEW JERSEY
- SUMMER OUTDOOR DESIGN CONDITIONS (PER ASHRAE FUNDAMENTALS - 2021):
 - DRY BULB: 94.3 DEG. F.
 - WET BULB: 74.4 DEG. F. *
 - ASHRAE 0.4 % COOLING DRY BULB/MEAN WET BULB FOR NEWARK, NEW JERSEY.
- SUMMER INDOOR DESIGN CONDITIONS:
 - DRY BULB: 75 DEG. F. (+/- 2 DEG. F.)
 - RELATIVE HUMIDITY: 50%
- WINTER OUTDOOR DESIGN CONDITIONS (PER ASHRAE FUNDAMENTALS - 2021):
 - DRY BULB: 12.7 DEG. F. *
 - ASHRAE 99.6 % DESIGN DRY DRY BULB FOR NEWARK, NEW JERSEY.
- WINTER INDOOR DESIGN CONDITIONS:
 - DRY BULB: 70 DEG. F. (+/- 2 DEG. F.)
 - RELATIVE HUMIDITY: NO MINIMUM HUMIDITY CONTROL PROVIDED

SYMBOL LIST

SYMBOL	DESCRIPTION
	PLAN OR DETAIL TAG DRAWING # TO LOCATE DETAIL
	SECTION TAG DRAWING # TO LOCATE SECTION DETAIL
	ELEVATION TAG DETAIL #
	DRAWING # TO LOCATE ELEVATION KEY NOTE SYMBOL
	KEY NOTES APPLYING TO SAME ITEM
	CONNECT TO EXISTING



Department of Community Affairs
Construction Project Review
Project No: 9050-26
partial release
mechanical
Thomas Williams
Released: 4/22/2025
N.J.S.A. 52:27D-119 ET SEQ., AS AMENDED

tm
TOKARSKI + MILLEMAN
ARCHITECTS, LLC

1729 ROUTE 35
WALL, NEW JERSEY 07719
phone 732.262.0046
facsimile 732.262.0045
Email info@tm-architects.com

Michael J. Millemann, AIA
NJ LICENSE # A1 14550
N.Y. LICENSE # 02885

CERTIFICATE OF AUTHORIZATION
No. AC33200

LATRINE ALTERATIONS FOR:
MT HOLLY ARMORY
1670 NJ-38
MT HOLLY, NEW JERSEY 08060
DMA PROJECT NO. MH008

REV: DATE: DESCRIPTION:


MECHANICAL
GENERAL
INFORMATION

PROJECT NO: 2557 DRAWN BY: KM

DATE ISSUED: 3/30/24

SHEET NO:

M0.1

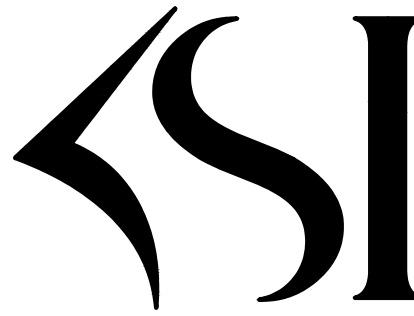


KSI CONSULTING ENGINEERS, LLC
ADDRESS:
P.O. BOX 628 FARMINGDALE, NJ 07727
PHONE:
732.938.2666


FAX:
732.938.2521

CERTIFICATE OF AUTHORIZATION NO:
24CA28124300


PAUL RIPPET, P.E.
Professional Engineer
State of New Jersey

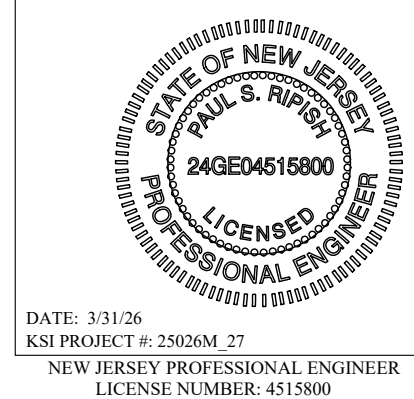

DATE: 3/31/24
KSI PROJECT #: 250004 27
NEW JERSEY PROFESSIONAL ENGINEER
LICENSE NUMBER: 451806

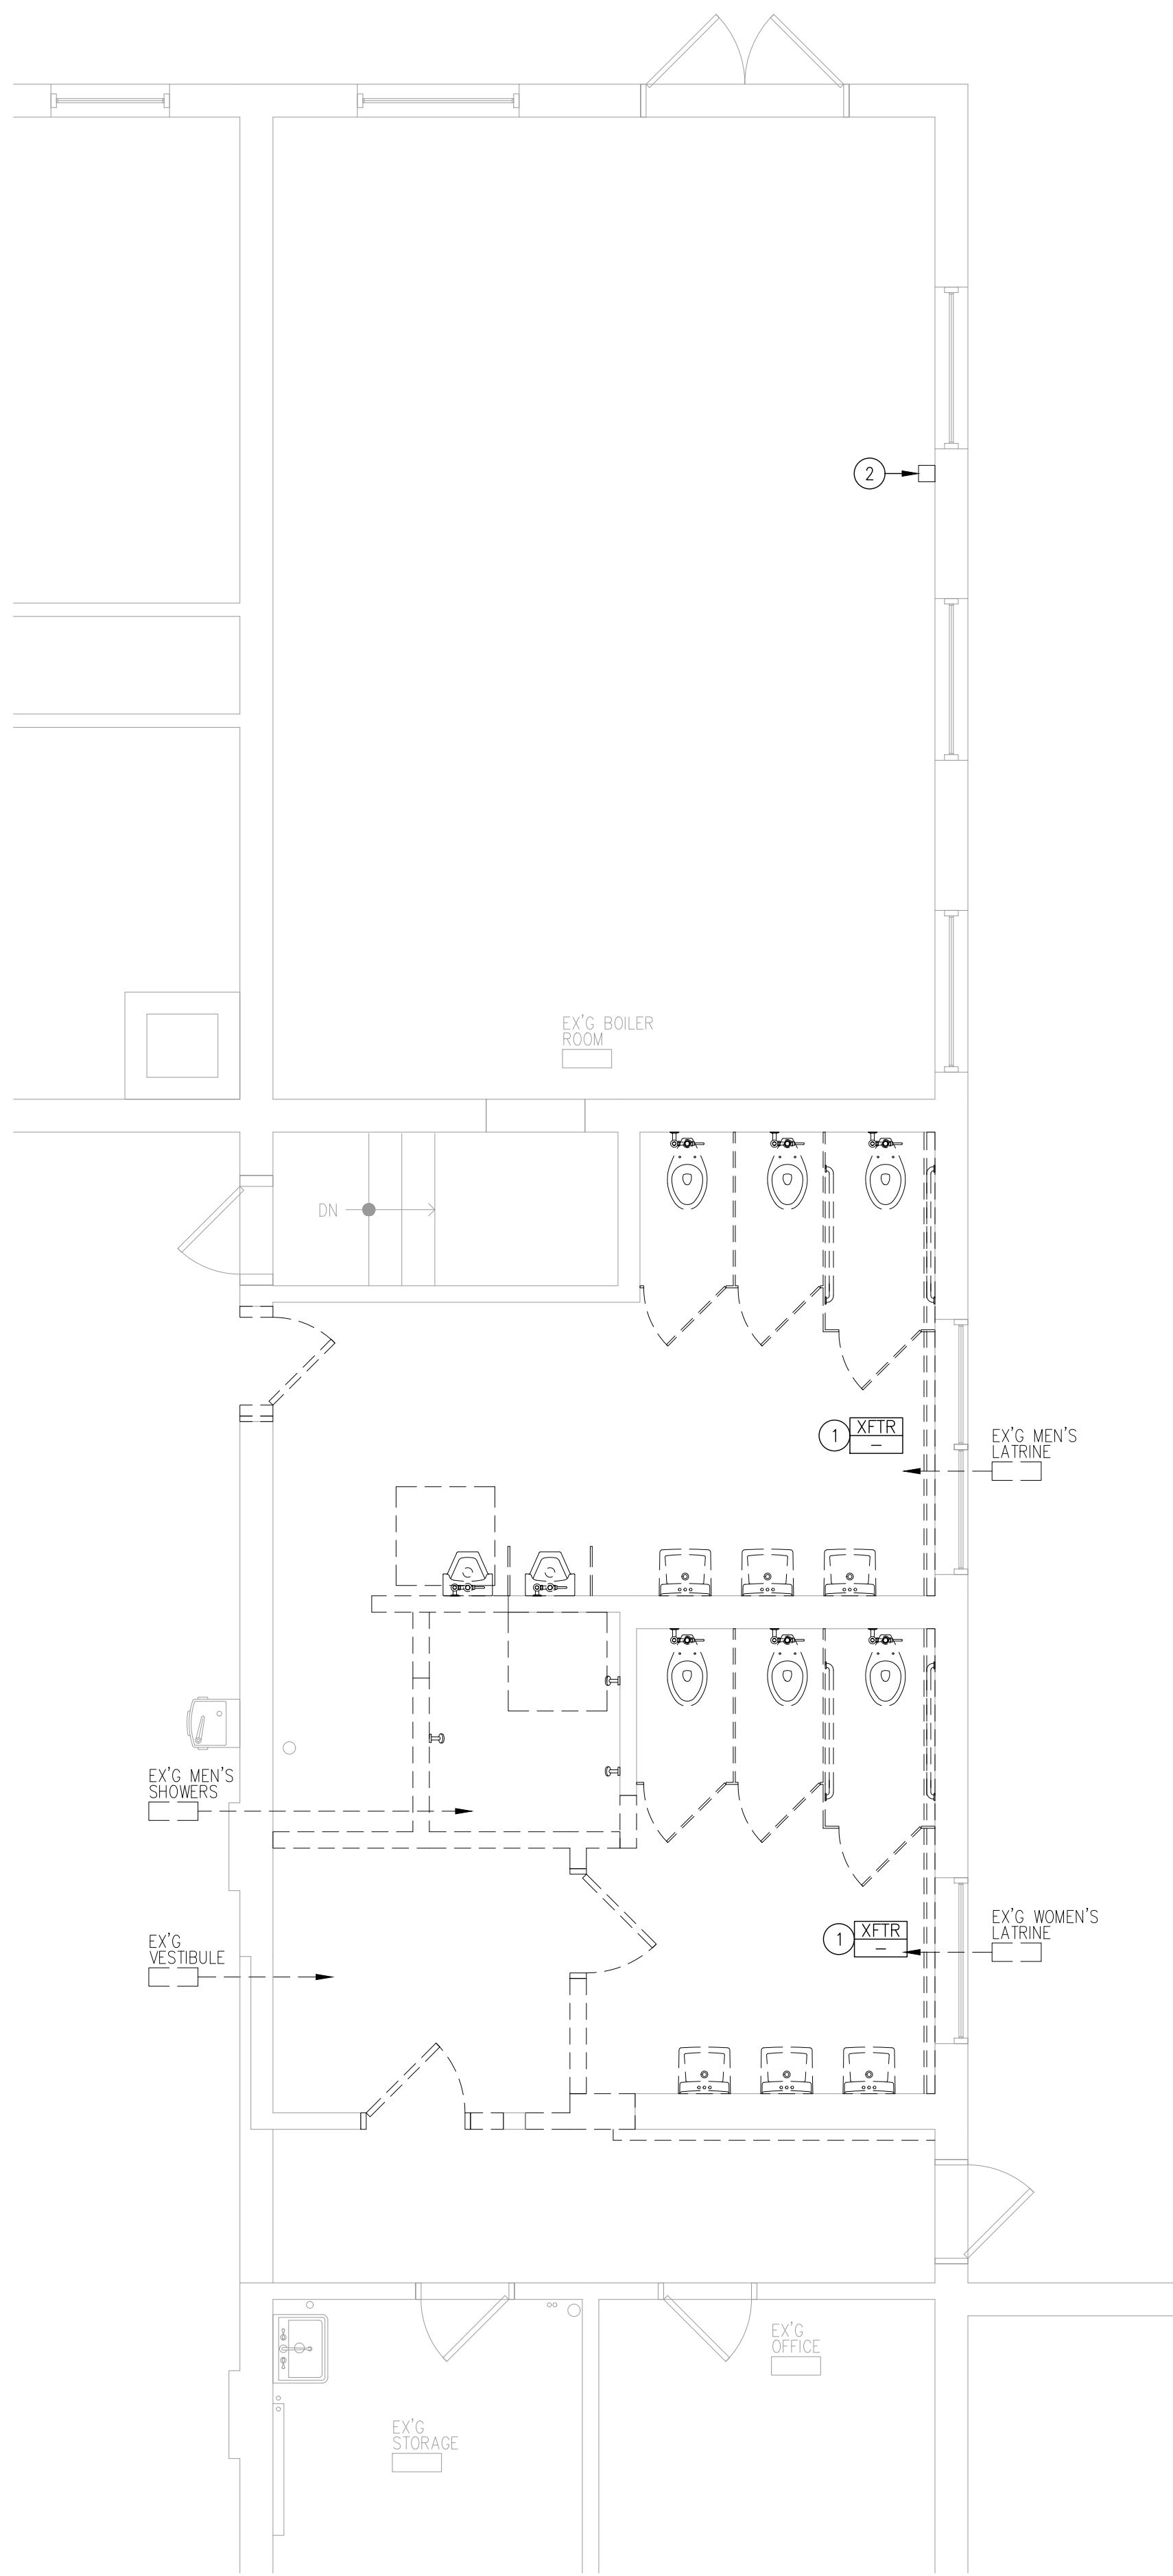

01
M1.1
MECHANICAL DEMOLITION PART PLAN
1/4"=1'-0"

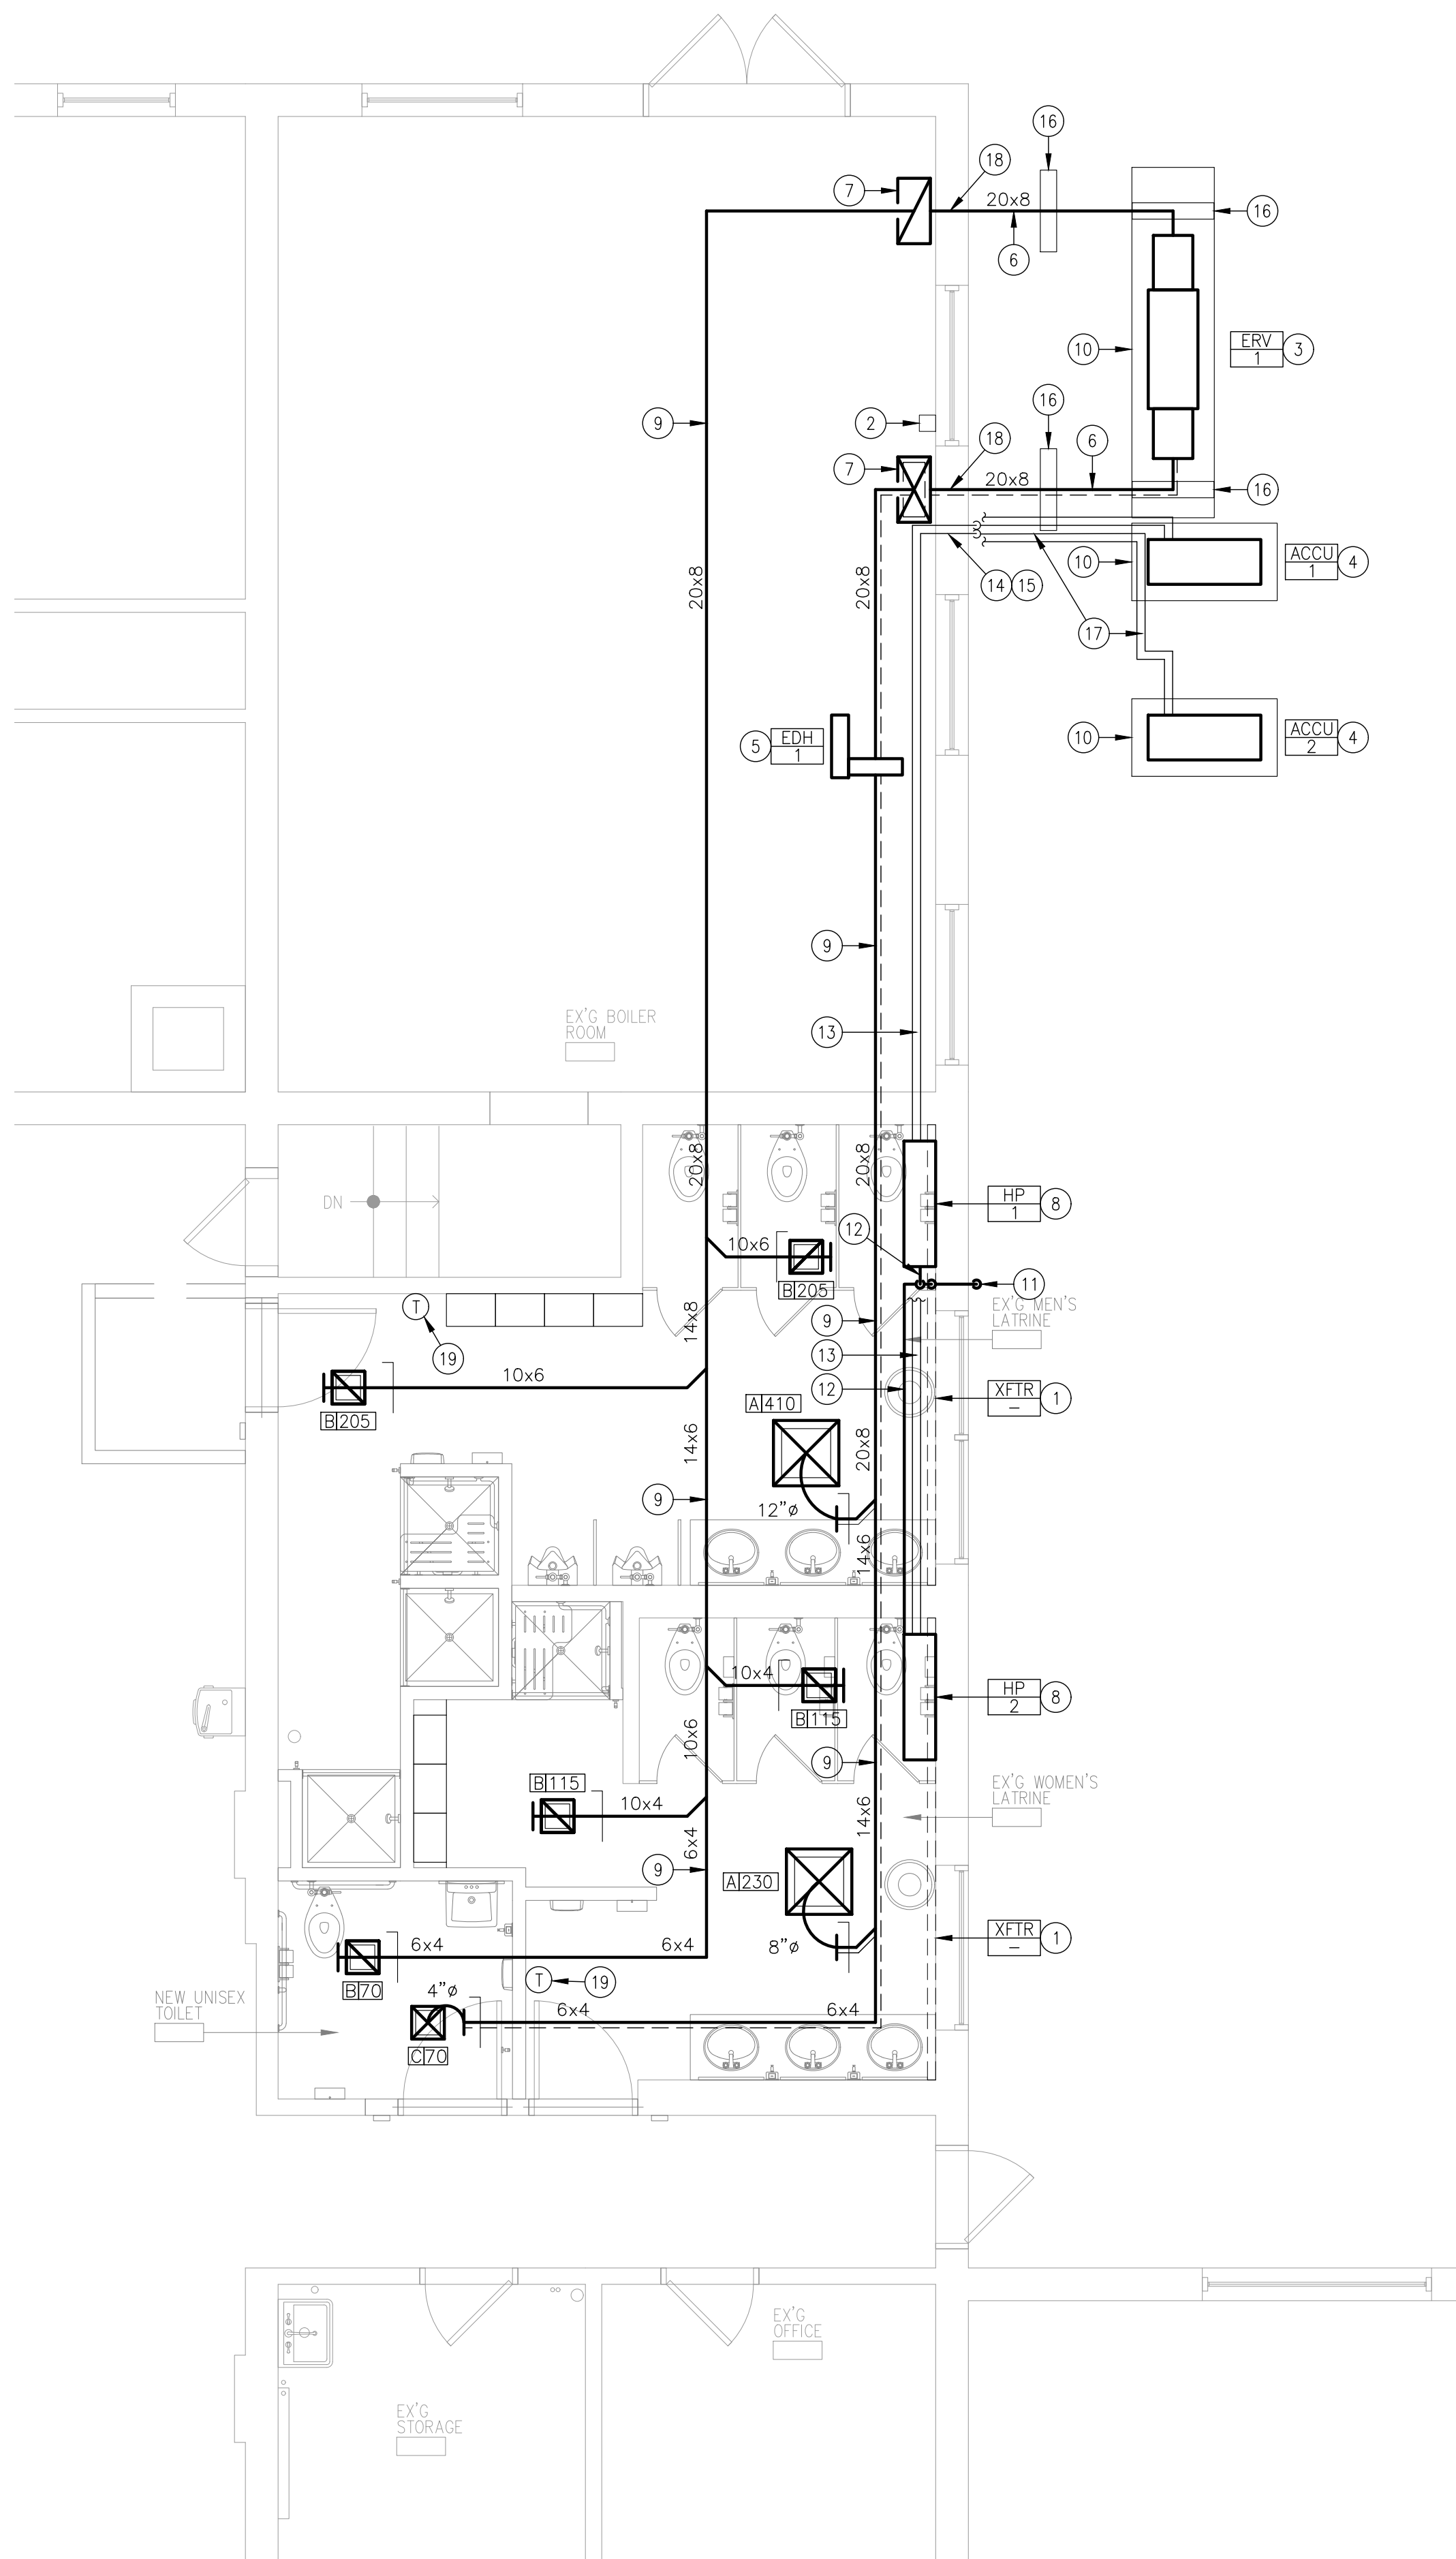


02
M1.1
MECHANICAL NEW WORK PART PLAN
1/4"=1'-0"

KEY NOTES

- EXISTING HOT WATER FTR TO REMAIN.
- RELOCATE EXISTING DESK AND WALL MOUNTED MEASURING DEVICE AND BACKBOARD AS SHOWN. PATCH/PAINT WALL TO MATCH EXISTING CONSTRUCTION. PROPOSED NEW LOCATION IS UNDER WINDOW. COORDINATE NEW LOCATION IN FIELD.
- PROVIDE NEW GRADE-MOUNTED ENERGY RECOVERY VENTILATOR. MOUNT ON 18" TALL CURB (CONCRETE PAD).
- PROVIDE NEW GRADE-MOUNTED CONDENSING UNIT. SECURE TO CONCRETE PAD WITH CONCRETE ANCHORS.
- PROVIDE NEW ELECTRIC DUCT HEATER.
- MOUNT DUCTS SUCH THAT BOTTOM OF DUCTS ARE ALIGNED WITH THE 4TH BRICK COURSE (OR HIGHER) FROM BOTTOM. ABOVE WHITE SOLID FOUNDATION WALL. CONTRACTOR TO COORDINATE DUCT HEIGHT IN FIELD.
- ROUTE DUCT UP ALONG BOILER ROOM INNER WALL. ROUTE DUCT AS HIGH AS POSSIBLE IN BOILER ROOM WITHOUT INTERFERING WITH PIPING. COORDINATE DUCT ROUTING WITH ALL TRADES.
- PROVIDE NEW HI-WALL HEAT PUMP.
- PROVIDE NEW DUCTWORK. PROVIDE GALVANNEEL OR MILL-PHOSPHATIZED FINISH IN EXPOSED AREAS AND PAINT. COORDINATE PAINT COLOR WITH ARCHITECT. TYPICAL.
- PROVIDE NEW CONCRETE PAD. FIELD VERIFY ALL UNDERGROUND PIPING PRIOR TO INSTALLATION OF CONCRETE PAD. INSTALL PAD SO THAT IT DOES NOT COVER EXISTING UNDERGROUND PIPING.
- PROVIDE NEW OPENING IN WALL FOR CONDENSATE PIPING. PROVIDE NEW 1" COPPER CONDENSATE PIPING THROUGH WALL. CAULK CONDENSATE PIPING IN WALL WATER TIGHT. TERMINATE CONDENSATE PIPING WITH 90 DEGREE COPPER ELBOW. PROVIDE SPLASH BLOCK AND SPILL CONDENSATE TO SPLASH BLOCK.
- PROVIDE NEW 1" COPPER CONDENSATE PIPING. INSULATE AS PER SPECIFICATIONS. SLOPE PIPING AT 1/8" PER FOOT.
- PROVIDE NEW REFRIGERANT PIPING. ALL REFRIGERANT SIZES AND QUANTITIES SHALL BE BY FINAL APPROVED HP/CO MANUFACTURER.
- PROVIDE NEW REFRIGERANT PIPING THROUGH EXTERIOR WALL. SEAL WALL PENETRATIONS WATER TIGHT.
- INSTALL REFRIGERANT PIPING, POWER AND CONTROL CONDUITS RACKED. ONLY TWO LINES ARE SHOWN FOR CLARITY.
- PROVIDE NEW DUCT SUPPORT CURB AND ANCHOR TO NEW CONCRETE PADS WITH CONCRETE ANCHORS.
- ROUTE REFRIGERANT PIPING TO BE ON TOP OF CONCRETE PAD AS SHOWN.
- PROVIDE NEW DUCTWORK THRU EXTERIOR WALL. REFER TO EXTERIOR WALL DUCT PENETRATION DETAIL ON DRAWING M2.2. PROVIDE NEW LINTEL AT NEW DUCT OPENING.
- PROVIDE NEW WALL MOUNTED THERMOSTAT BY HEAT PUMP MANUFACTURER.



Department of Community Affairs
Construction Project Review
Project No: 9050-26
partial release
mechanical
Thomas Williams
Released: 4/22/2018
N.J.S.A. 52:27D-119 ET SEQ., AS AMENDED

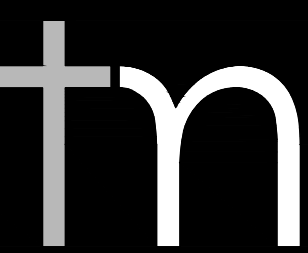

TOKARSKI + MILLEMAN
ARCHITECTS, LLC

1729 ROUTE 35
WALL, NEW JERSEY 07719
phone 732.262.0046
facsimile 732.262.0045
Email info@tm-architects.com

Michael J. Millemann, AIA


N.J. LICENSE # A1 14550
N.Y. LICENSE # 028885

CERTIFICATE OF AUTHORIZATION
No. AC33200

LATRINE ALTERATIONS FOR:
MT HOLLY ARMORY
1670 NJ-38
MT HOLLY, NEW JERSEY 08060
DMA PROJECT NO. MH008



KSI CONSULTING ENGINEERS, LLC
ADDRESS:
P.O. BOX 628 FARMINGDALE, NJ 07727
PHONE:
732.938.2666
FAX:
732.938.2521
CERTIFICATE OF AUTHORIZATION NO.
24GA28124300

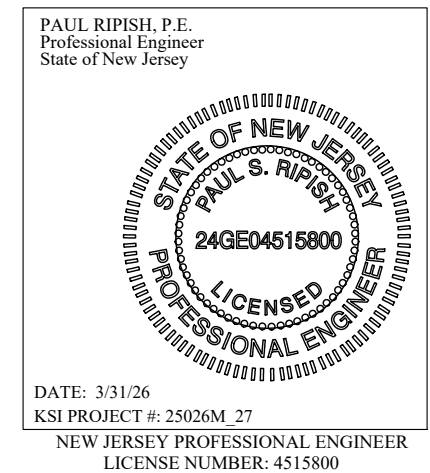


MECHANICAL
DEMOLITION &
NEW WORK
PART PLANS

PROJECT NO.: 2557 DRAWN BY: KM

DATE ISSUED: 3/30/24

SHEET NO.:

M1.1

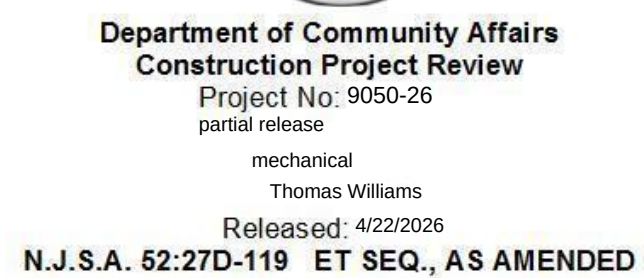

Michael J. Millemann, AIA

N.J. LICENSE # AI 14550
N.Y. LICENSE # 028885



LATRINE ALTERATIONS FOR:
MT HOLLY ARMORY
1670 NJ-38
MT HOLLY, NEW JERSEY 08060
DMA PROJECT NO. MH008

MT HOLLY, NEW JERSEY 08060
DMA PROJECT NO. MH008

REV.:	DATE:	DESCRIPTION:
-------	-------	--------------

PROJECT NO.: 2557	DRAWN BY: KM
-------------------	--------------

 SHEET NO.:

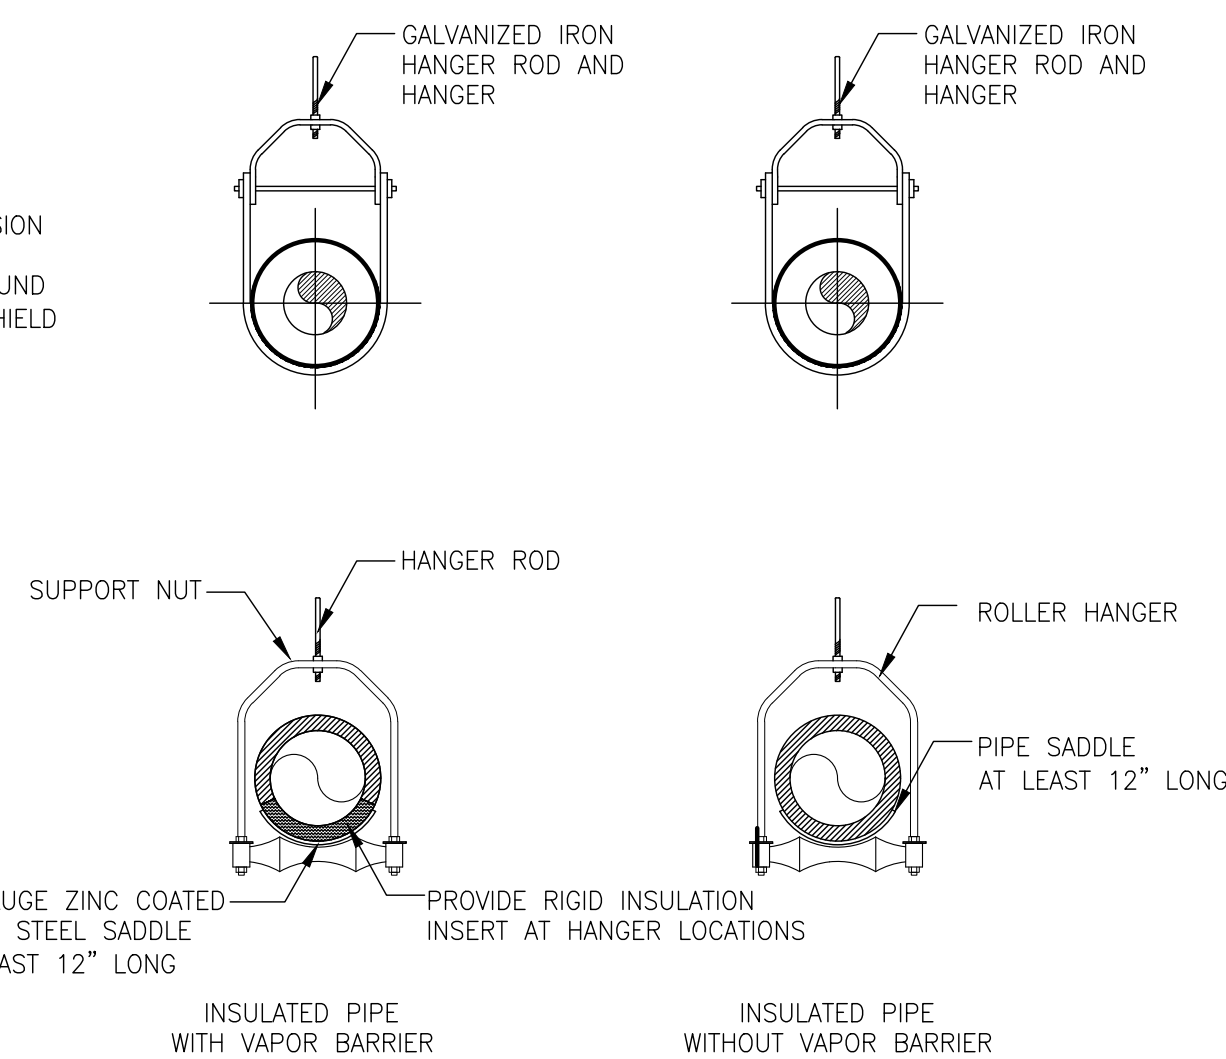

HANGER ROD SIZE/SPACING SCHEDULE					
PIPE SIZE	WEIGHT PER FOOT	MINIMUM HANGER ROD SIZE	MAXIMUM HANGER SPACING		NATURAL GAS, 40'
			WASTE & WATER COPPER TYPE M	STEEL SCH. 40	
1/2"	1.0	1/4"	6'	5'	6'
3/4"	1.4	1/4"	6'	6'	8'
1"	2.1	1/4"	6'	7'	8'
1-1/4"	2.9	3/8"	6'	9'	10'
1-1/2"	3.6	3/8"	6'	9'	10'
2"	5.2	3/8"	10'	10'	10'
2-1/2"	7.9	1/2"	10'	11'	10'
3"	10.8	1/2"	-	12'	-
4"	16.5	5/8"	-	14'	-
6"	31.5	3/4"	-	17'	-
8"	47	7/8"	-	19'	-
10"	70	7/8"	-	22'	-
12"	94	7/8"	-	23'	-

- NOTES:
1. DETAIL SHALL BE APPLIED TO ALL WALL (CORRIDOR, STAIRWELLS, UTILITY ROOMS, ETC.) PIPING PENETRATIONS.
 2. PROVIDE ESCUTCHEON PLATE WHERE PIPE PENETRATIONS ARE EXPOSED IN FINISHED AREAS.
 3. PROVIDE 3M F-55 WRAPSTIR FIRE STOP AND C.P. 25 CAULKING PUTTY INSTALLED AS PER MANUFACTURER'S RECOMMENDATIONS TO ALL FIRE-RATED WALL PENETRATIONS.

01	PIPE PENETRATION THROUGH WALL
M2.2	NONE


M2.2	NONE
------	------



1. PROVIDE ALL WEATHERPROOFING MEASURES (FLASHING, SEALANTS, ETC.) FOR THE WALL PENETRATION.
2. ALL HARDWARE, SHEETMETAL, ETC. USED OUTSIDE SHALL BE NON-CORROSIVE EXTERIOR RATED.
3. WALL PENETRATION SIZE SHALL ACCORD TO AND ACCOMMODATE ANY INCREASED DUCT SIZES WHERE INTERNAL LINING IS PRESENT.
4. DUCTS AND COUNTER FLASHING SHALL BE PROPERLY SECURED TO THE WALL ASSEMBLY. ALL FASTENER PENETRATIONS IN WEATHERPROOF BARRIERS SHALL USE SILICON CAULK SEALANT.
5. WALL PENETRATION ASSEMBLY SHALL FIT TIGHT AGAINST WALLS WITH WEATHERPROOFING MEASURES PROVIDED. PROVIDE ALL REQUIRED DUCT BLOODING STRIPS, HARDWARE, SEALANTS, ETC.) TO ACCOMMODATE THE WALL ASSEMBLY. ALL MATERIALS USED SHALL BE EXTERIOR GRADE RATED.
6. DUCTS SHALL NOT BE SUPPORTED BY WALL PENETRATION ASSEMBLY. PROVIDE SUPPORTS ON BOTH SIDES OF WALL PENETRATION
7. SEE FLOOR PLANS FOR DUCT SIZES.

03	EXTERIOR WALL DUCT PENETRATION
M2.2	NONE

M2.2	NONE
------	------

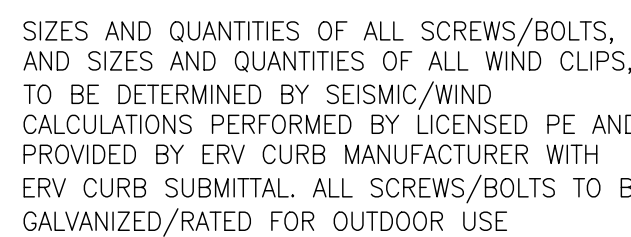


ERV UNIT ON GRADE MOUNTED CONCRETE PAD DETAIL


04	MC
M2.2	NONE

05 EXTERIOR DUCT INSTALLATION DETAIL

NONE

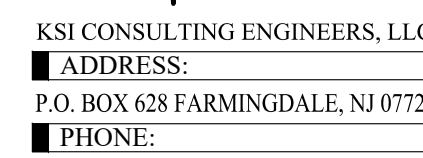

FAX: 732.938.2521
 CERTIFICATE OF AUTHORIZATION NO. 24GA28124300

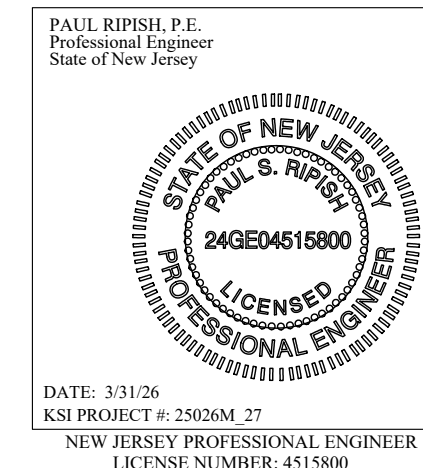

DATE: 3/31/26
KSI PROJECT #: 25026M_27
NEW JERSEY PROFESSIONAL ENGINEER
LICENSE NUMBER: 4515800

ENERGY RECOVERY UNIT SCHEDULE (ERV)																							NOTES	
UNIT ID	MODEL NUMBER	SPACE SERVED SUPPLY FAN			EXHAUST FAN			WINTER CONDITIONS			SUMMER CONDITIONS			ELECTRICAL CHARACTERISTICS				DIMENSIONS						
		AIR FLOW (CFM)	MOTOR (WATTS)	ESP (IN. W.C.)	AIR FLOW (CFM)	MOTOR (WATTS)	ESP (IN. W.C.)	EAT (AMBIENT) DB/WB °F	LAT (SUPPLY) DB/WB °F	TOTAL CAPACITY RECOVERED (MBH)	EAT (AMBIENT) DB/WB °F	LAT (SUPPLY) DB/WB °F	TOTAL CAPACITY RECOVERED (MBH)	VOLTS	PHASE	HERTZ	MCA	MOP (AMPS)	LENGTH (INCH)	WIDTH (INCH)	HEIGHT (INCH)		WEIGHT (LBS)	
ERV-1	HE10-JRTH	BATHROOMS	710	438	1.25	710	411	1.25	12.3/8.0	53.2/40.2	38.29	95.0/73.6	80.8/68.2	14.83	208/230	1	60	11.3	15	81.75	18.25	55.25	261	1 THRU 12
NOTES: 1. SELECTIONS BASED ON EQUIPMENT MANUFACTURED BY RENEW-AIRE. SELECTIONS ARE BASIS OF DESIGN ONLY. CONTRACTOR MAY PROVIDE APPROVED EQUAL THAT MEETS THE PERFORMANCE REQUIREMENTS AND SALIENT CHARACTERISTICS OF THE BASIS OF DESIGN. 2. UNIT SHALL BE OUTDOOR RATED AND "RTH" CONFIGURATION WITH HORIZONTAL SUPPLY AND RETURN AIRFLOW. 3. UNIT SHALL HAVE ALL INTEGRAL CONTROLS FOR COMPLETE OPERATION. 4. UNIT SHALL HAVE CROSS-FLOW "AIR-TO-AIR" ENERGY RECOVERY CORE HEAT EXCHANGER. COORDINATE AIR CONNECTION CONFIGURATION TYPE WITH LAYOUT ON PLANS. 5. UNIT SHALL HAVE FACTORY MOTORIZED OUTSIDE AND EXHAUST AIR DAMPERS WITH FULL CONTROL. 6. UNIT SHALL HAVE DISCONNECT SWITCH. 7. UNIT SHALL HAVE REMOVABLE TYPE ACCESS DOOR PANELS. 8. PROVIDE MERV 8 FILTERS (SIZES AND QUANTITIES AS PER MANUFACTURER REQUIREMENTS). 9. PROVIDE ALL REQUIRED CONTROLS COMPONENTS (CONTROLLERS, SENSORS, CONTROL AND POWER WIRING, CONTROL TRANSFORMERS, ETC.) REQUIRED FOR A COMPLETE INSTALLATION. 10. UNIT SHALL HAVE PLUG-IN CORD. PROVIDE 120V/1PH/60HZ DUPLEX RECEPTACLE AND DISCONNECT WITH ALL REQUIRED POWER WIRING, DEVICES, ETC. 11. UNIT SHALL HAVE DOUBLE WALL CONSTRUCTION. 12. PROVIDE NEW 18" SEISMIC/WIND LOAD RATED CURB WITHOUT VIBRATION ISOLATION. CURB MANUFACTURER TO PROVIDE SIGNED AND SEALED (BY NJ PE) CALCULATIONS INDICATING QUANTITIES AND LOCATIONS OF ERV TO CURB AND CURB TO CONCRETE PAD ATTACHMENTS TO COMPLY WITH WIND LOAD CALCULATIONS OF 126 MPH FOR MOUNT HOLLY, NJ. CURBS SHALL BE THYBAR, VMC, CAMBRIDGE, OR APPROVED EQUAL.																								

AIR-COOLED CONDENSING UNIT SCHEDULE (ACCU)															
UNIT NO.	MODEL NO.	INTERLOCKED INDOOR UNIT(S)	NOMINAL COOLING CAPACITY (TONS)	NOMINAL COOLING CAPACITY (BTUH)	NOMINAL HEATING CAPACITY (BTUH)	ELECTRICAL			FEED 1		DIMENSIONS			WEIGHT (LBS.)	NOTES
							VOLTS	PHASE	HERTZ	MCA (AMPS)	MOCP (AMPS)	WIDTH (INCH)	HEIGHT (INCH)		
ACCU-1	PUZ-AK24NLHZ	HP-1	2	24,000	26,000	208/230	1	60	24	35	41.34	52.67	14	231	1 THRU 9
ACCU-2	PUZ-AK24NLHZ	HP-2	2	24,000	26,000	208/230	1	60	24	35	41.34	52.67	14	231	1 THRU 9
NOTES:															
1. SELECTIONS BASED ON EQUIPMENT MANUFACTURED BY TRANE. SELECTIONS ARE BASIS OF DESIGN ONLY. CONTRACTOR MAY PROVIDE APPROVED EQUAL THAT MEETS THE PERFORMANCE REQUIREMENTS AND SALIENT CHARACTERISTICS OF THE BASIS OF DESIGN.															
2. MOUNT CONDENSING UNIT ON CONCRETE PAD ON GRADE. SEE MECHANICAL DETAILS FOR MORE INFORMATION.															
3. PROVIDE POWER DISCONNECT SWITCH, ANTI-SHORT CYCLE TIMER AND CONDENSER COIL GUARD.															
4. PROVIDE FACTORY BRANCH JOINTS AS REQUIRED TO ACCOMMODATE OVERALL SYSTEM CONNECTIONS AND OPERATION. COORDINATE INSTALLATION HARDWARE REQUIREMENTS WITH MANUFACTURER.															
5. UNIT SHALL BE SUITABLE FOR LOW AMBIENT TEMPERATURES DOWN TO 0°F.															
6. UNIT SELECTION BASED ON 95°F AMBIENT AIR CONDITIONS.															
7. UNIT SHALL USE REFRIGERANT R-32 OR R-454B.															
8. PROVIDE ALL REQUIRED CONTROLS COMPONENTS (CONTROLLERS, SENSORS, CONTROL AND POWER WIRING, CONTROL TRANSFORMERS, ETC.) REQUIRED FOR A COMPLETE INSTALLATION.															
9. MANUFACTURER INSTALLED, CODE COMPLIANT, REFRIGERANT DETECTOR AND CORRESPONDING CONTROLS SEQUENCES FOR REFRIGERANT LEAK.															

HEATPUMP "DX VRF SPLIT SYSTEM" UNIT SCHEDULE (HP)																		NOTES
UNIT ID	MODEL NUMBER	TYPE	INTERLOCKED WITH	SUPPLY AIR FAN RANGE (CFM) (LOW / MED / HIGH)	OUTSIDE AIR (CFM) (PRE-TREATED)	NOMINAL COOLING CAPACITY (BTUH)	NOMINAL HEATING CAPACITY (BTUH)	ELECTRICAL CHARACTERISTICS					DIMENSIONS					
								VOLTS	PHASE	HERTZ	MCA	MOPC (AMPS)	DEPTH (INCH)	WIDTH (INCH)	HEIGHT (INCH)	WEIGHT (LBS.)		
HP-1	PKA-AK24NL	WALL MOUNTED	ACCU-1	635 / 705 / 775	N/A	24,000	26,000	208/230	1	60	24	35	46.06	11.63	14.38	46	1 THRU 7	
HP-2	PKA-AK24NL	WALL MOUNTED	ACCU-2	635 / 705 / 775	N/A	24,000	26,000	208/230	1	60	24	35	46.06	11.63	14.38	46	1 THRU 7	

NOTES:

1. SELECTIONS BASED ON EQUIPMENT MANUFACTURED BY TRANE. SELECTIONS ARE BASIS OF DESIGN ONLY. CONTRACTOR MAY PROVIDE APPROVED EQUAL THAT MEETS THE PERFORMANCE REQUIREMENTS AND SALIENT CHARACTERISTICS OF THE BASIS OF DESIGN.

2. UNIT SHALL BE WALL MOUNTED TYPE WITH MODULATING SUPPLY AIR LOUVER DISCHARGE, TOP RETURN AIR GRILLE INTAKE AND FACTORY WALL SUPPORT PLATE.

3. PROVIDE DISCONNECT SWITCHES FOR ALL EQUIPMENT.

4. UNIT SHALL HAVE MANUFACTURERS INTEGRAL FACTORY CONDENSATE PUMP ASSEMBLY. PROVIDE MINI-CONDENSATE PUMP ASSEMBLY FOR WALL MOUNTED UNITS CONCEALED IN UNIT (OR IN ENGINEERED DECORATIVE WALL CAP).

5. PROVIDE FACTORY WALL MOUNTED "SIMPLIFIED" TEMPERATURE CONTROLLER MODEL C1S01 (WIRED TYPE).


6. PROVIDE ALL REQUIRED CONTROLS COMPONENTS (CONTROLLERS, SENSORS, CONTROL AND POWER WIRING, CONTROL TRANSFORMERS, ETC.) REQUIRED FOR A COMPLETE INSTALLATION. PROVIDE H-LINK ADAPTOR FOR CENTRAL CONTROLLER TIE-IN.

7. MANUFACTURER INSTALLED, CODE COMPLIANT, REFRIGERANT DETECTOR AND CORRESPONDING CONTROLS SEQUENCES FOR REFRIGERANT LEAK.

DIFFUSER AND REGISTER SCHEDULE						
UNIT ID	MODEL	FACE SIZE	NECK SIZE	DESCRIPTION		REMARKS
A	ASCD	24x24	SEE TABLE 1	ALUMINUM CONSTRUCTION 3-CONE CEILING DIFFUSER WITH OPPOSED BLADE VOLUME DAMPER.		1 THROUGH 7
B	630	12x12	10x10	ALUMINUM RETURN GRILLE WITH FIXED 45 DEGREE LOUVERS AND 3/4" SPACING WITH OPPOSED BLADE VOLUME DAMPER.		1,3,5,6
C	ASCD	12x12	4" DIAMETER	ALUMINUM CONSTRUCTION 3-CONE CEILING DIFFUSER WITH OPPOSED BLADE VOLUME DAMPER.		1 THROUGH 7
NOTES				TABLE 1:		
1. SELECTIONS ARE BASED ON PRICE INDUSTRIES. EQUALS SHALL BE TITUS, CARNES, KRUEGER				UP TO 275 CFM - 8" DIAMETER		
2. BRANCH DUCTS AND FLEXIBLE DUCTS CONNECTING TO THE DIFFUSERS SHALL BE FULL SIZE OF NECK DIAMETER				276 TO 380 CFM - 10" DIAMETER		
3. BAKED ENAMEL FINISH. COLOR TO BE SELECTED BY ARCHITECT.				381 TO 500 CFM - 12" DIAMETER		
4. DIFFUSERS SHALL BE 4-WAY BLOW UNLESS OTHERWISE INDICATED ON PLANS.				501 TO 700 CFM - 14" DIAMETER		
5. MOUNTING FRAME TYPE SHALL BE COORDINATED WITH CEILING/WALL/DUCT CONSTRUCTION TYPE.				701 TO 901 CFM - 15" DIAMETER		
6. REFER TO ARCHITECTS REFLECTED CEILING PLANS FOR FINAL LOCATION OF DIFFUSERS AND GRILLES						
7. PROVIDE SQUARE TO ROUND NECK ADAPTERS IF REQUIRED						

ELECTRIC DUCT HEATER SCHEDULE (EDH)									
UNIT ID	SERVING	MODEL	CFM	KW	STAGES	EAT	LAT	VOLTS	PH
EDH-1	LATRINES	EK-200805SCCHR	710	5	SCR	53	75	208	1
NOTES: 1. SELECTIONS BASED ON RENEWAIRE. 2. CONTRACTOR SHALL COORDINATE DUCT SIZE WITH MANUFACTURER'S MINIMUM AIRFLOW VELOCITY REQUIREMENTS 3. AUTOMATIC RESET THERMAL CUTOUT 4. AIRFLOW SWITCH 5. DOOR INTERLOCK DISCONNECT SWITCH 6. SCR CONTROL 7. PROVIDE SLP-IN ARRANGEMENT 8. UNIT ENABLING SHALL BE INTERLOCKED WITH ASSOCIATED HP UNIT OPERATION. PROVIDE DISCHARGE AIR DUCT TEMPERATURE SENSOR INTERLOCKED WITH COIL HEATING FOR CONTROL OPERATION (SET FOR MAINTAINING 75°F SUPPLY AIR DISCHARGE TEMPERATURE). PROVIDE ALL CONTROL WIRING AND COMPONENTS REQUIRED FOR FULL OPERATION (RELAYS, 24V TRANSFORMERS, LINE VOLTAGE WIRING, ETC.)									

01
M3.1 MECHANICAL EQUIPMENT SCHEDULES
NONE

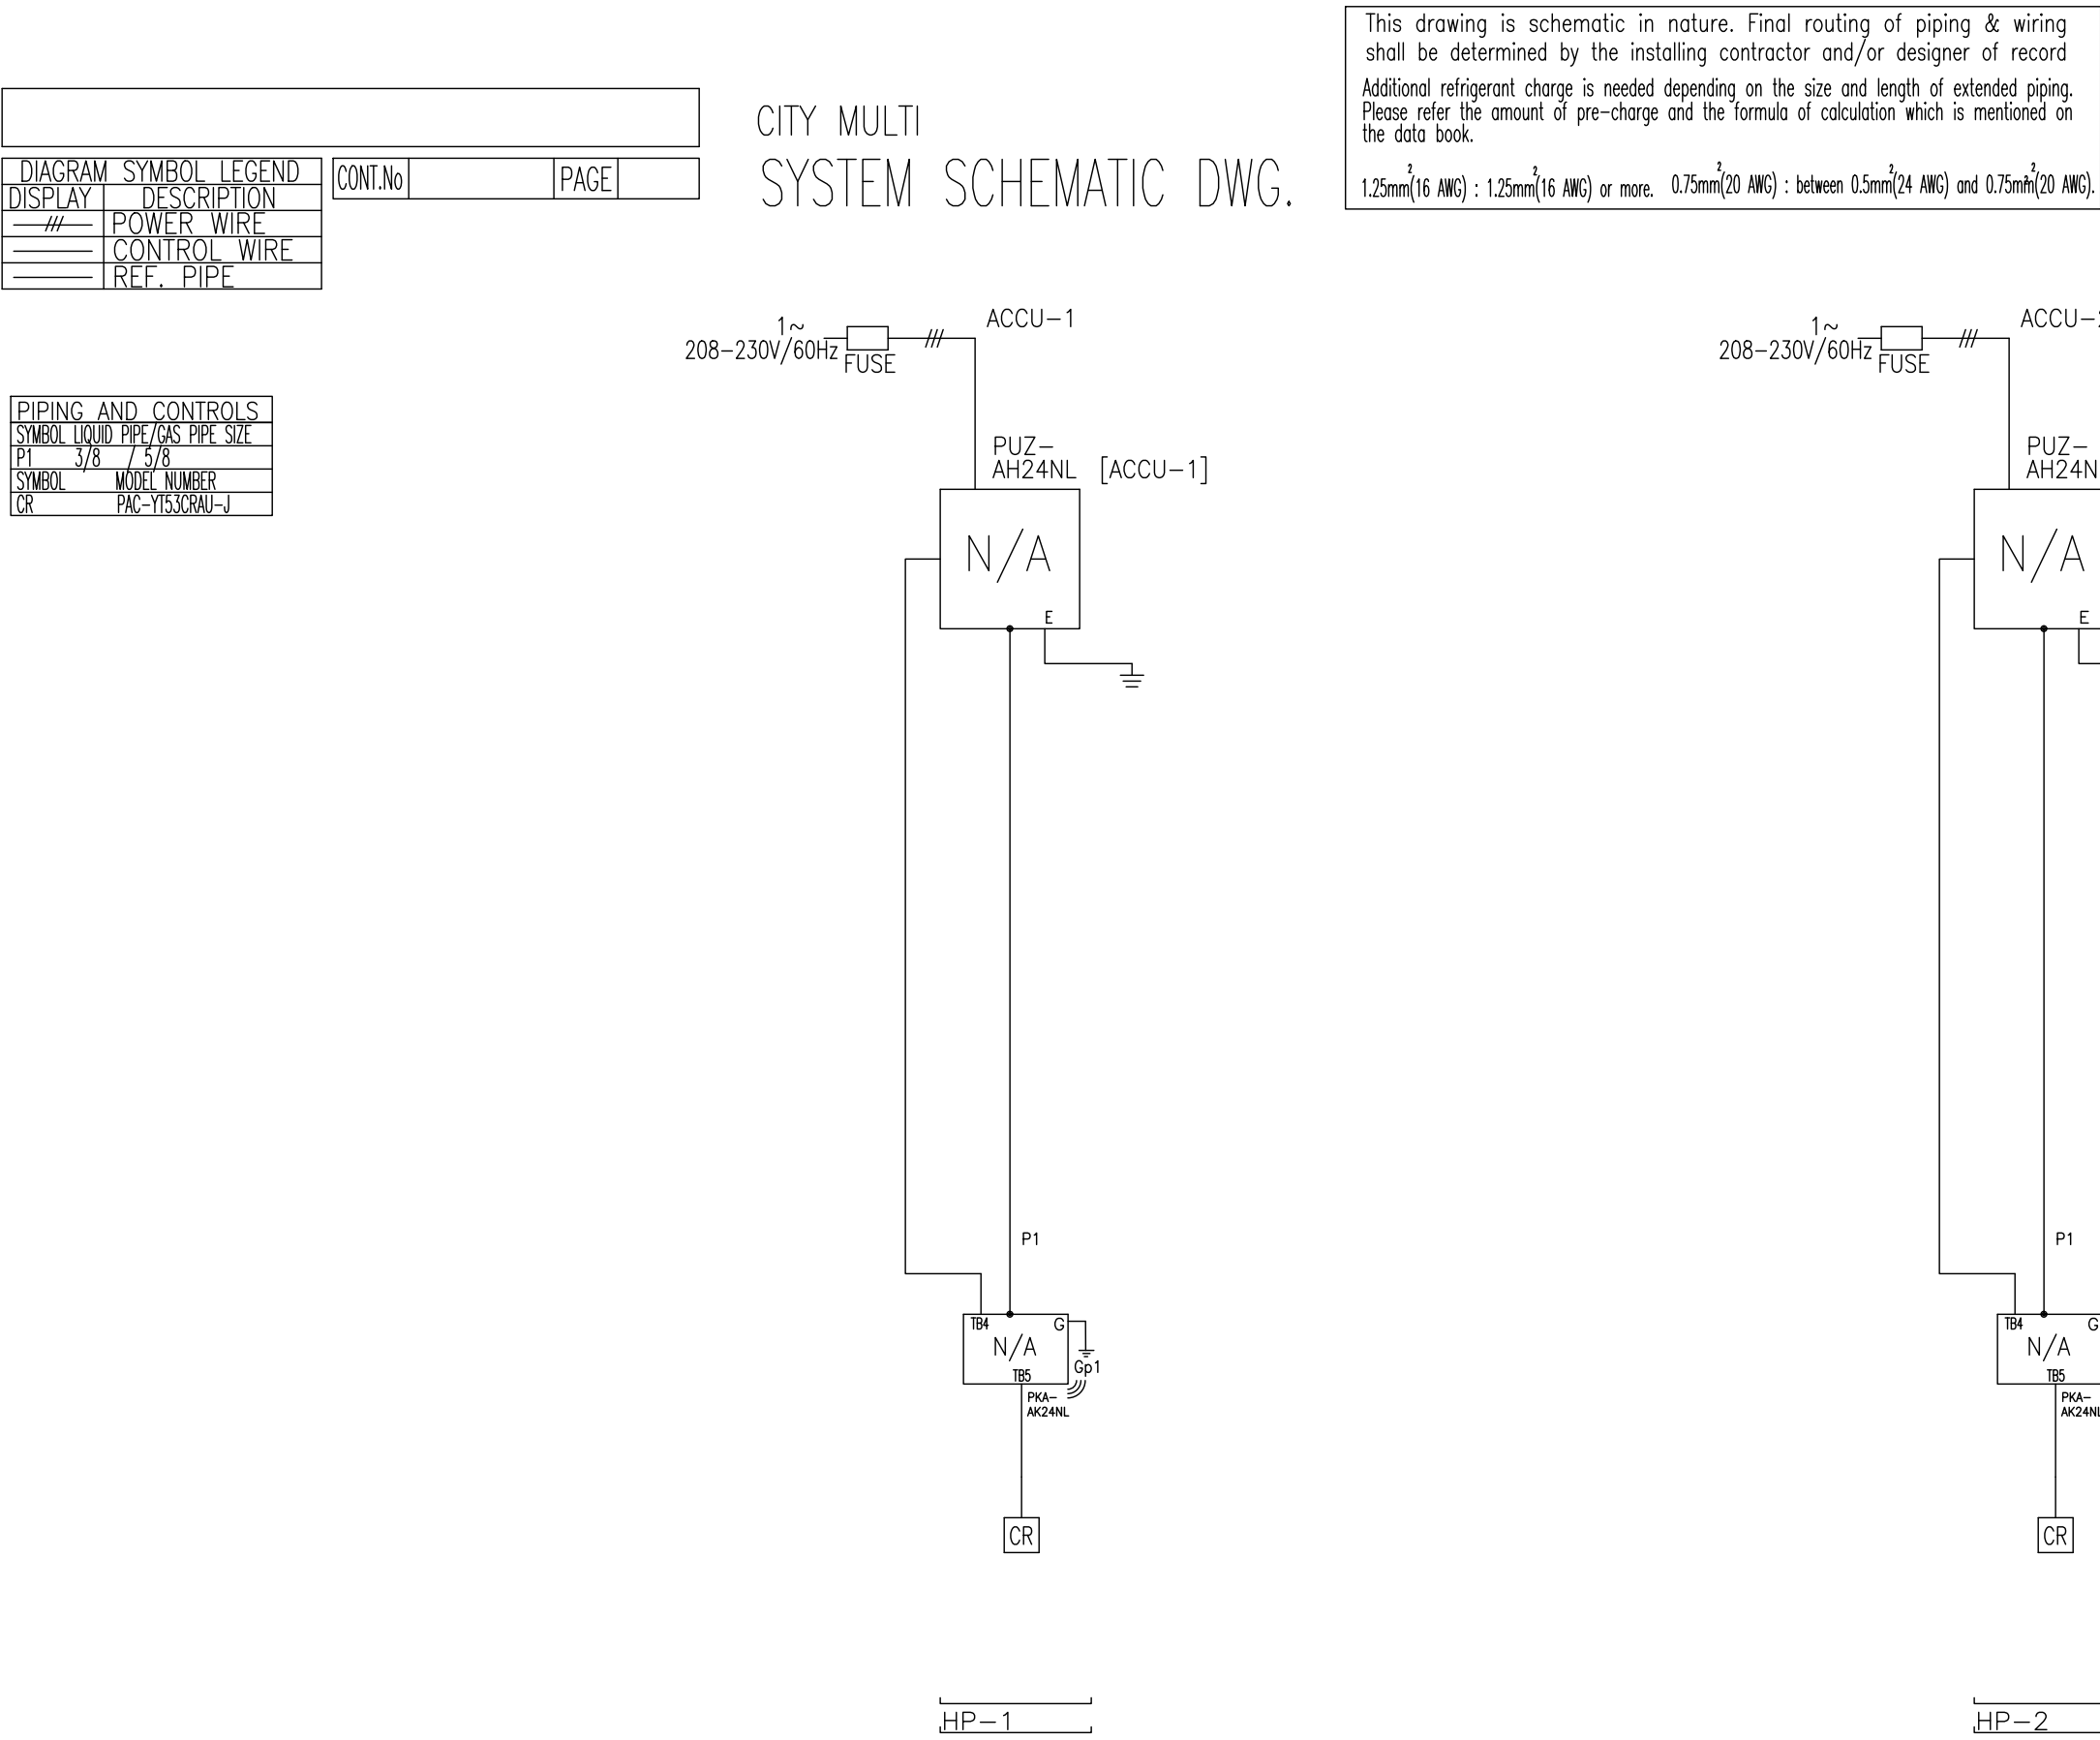

02
M3.1 MECHANICAL CONTROLS AND PIPING DIAGRAMS
NONE

KSI
KSI CONSULTING ENGINEERS, LLC
ADDRESS:
P.O. BOX 628 FARMINGDALE, NJ 07727
PHONE:
732.938.2666
FAX:
732.938.2521
CERTIFICATE OF AUTHORIZATION NO.
24GA28124300
PAUL RIPPET, P.E.
Professional Engineer
State of New Jersey
DATE: 3/31/26
KSI PROJECT #: 2500M 27
NEW JERSEY PROFESSIONAL ENGINEER
LICENSE NUMBER: 4515800

Department of Community Affairs
Construction Project Review
Project No: 9050-26
partial release
mechanical
Thomas Williams
Released: 4/22/2026
N.J.S.A. 52:27D-119 ET SEQ., AS AMENDED

tm
TOKARSKI + MILLEMANN
ARCHITECTS, LLC
1729 ROUTE 35
WALL, NEW JERSEY 07719
phone 732.262.0046
facsimile 732.262.0045
Email info@tm-architects.com

Michael J. Millemann, AIA
N.J. LICENSE # A114550
N.Y. LICENSE # 028885

CERTIFICATE OF AUTHORIZATION
No. AC33200

LATRINE ALTERATIONS FOR:
MT HOLLY ARMORY
I670 NJ-38
MT HOLLY, NEW JERSEY 08060
DMA PROJECT NO. MH008

REV: DATE: DESCRIPTION:


MECHANICAL
SCHEDULES,
CONTROLS AND PIPING
DIAGRAMS

PROJECT NO: 2557 DRAWN BY: KM


DATE ISSUED: 3/30/26

SHEET NO:

M3.1

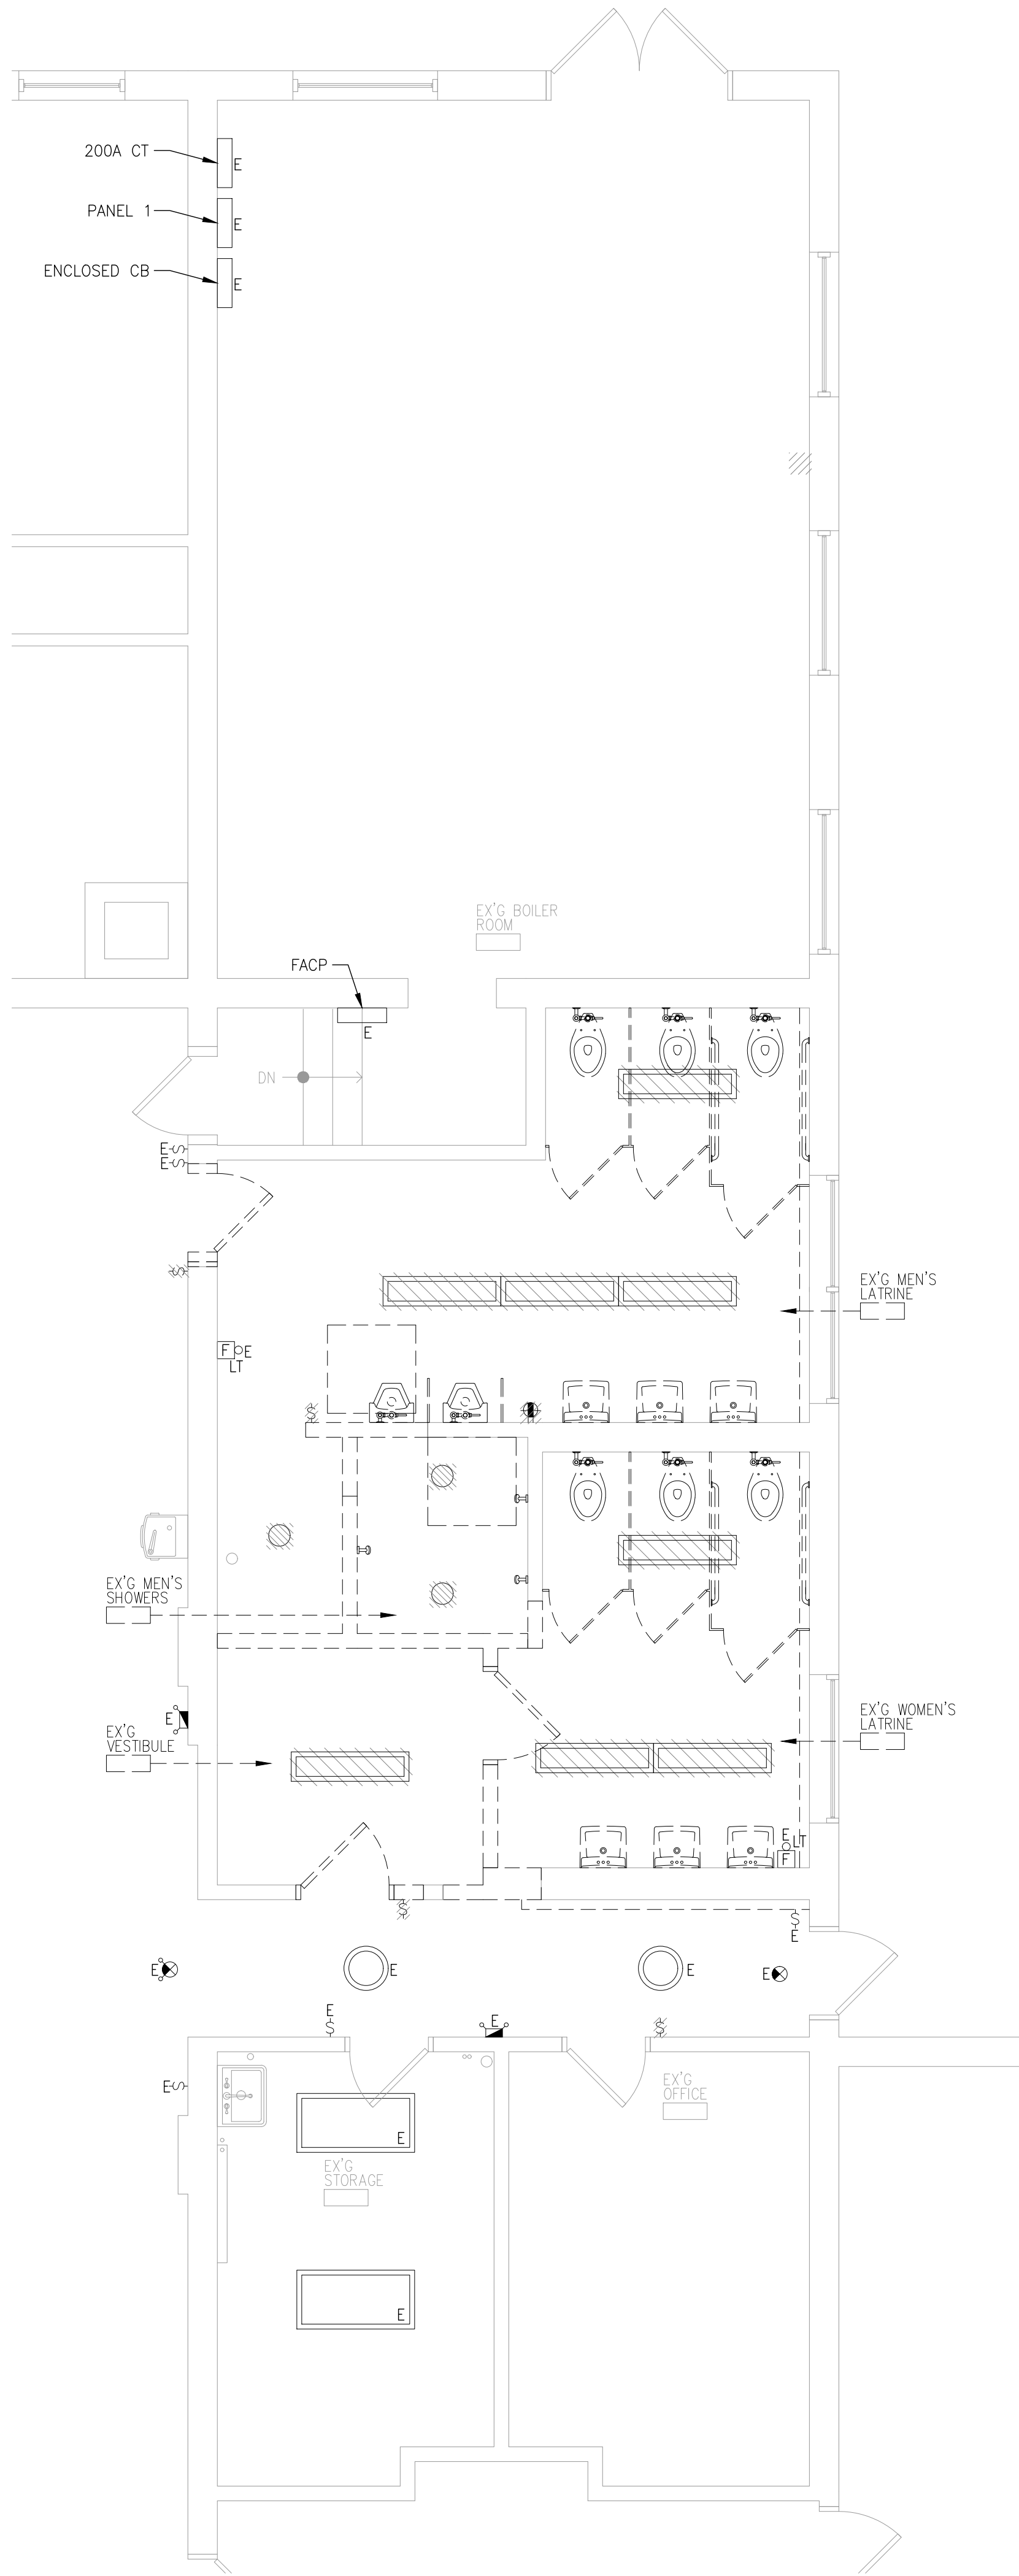

01 ELECTRICAL DEMOLITION PART PLAN
E1.1 1/4"=1'-0"

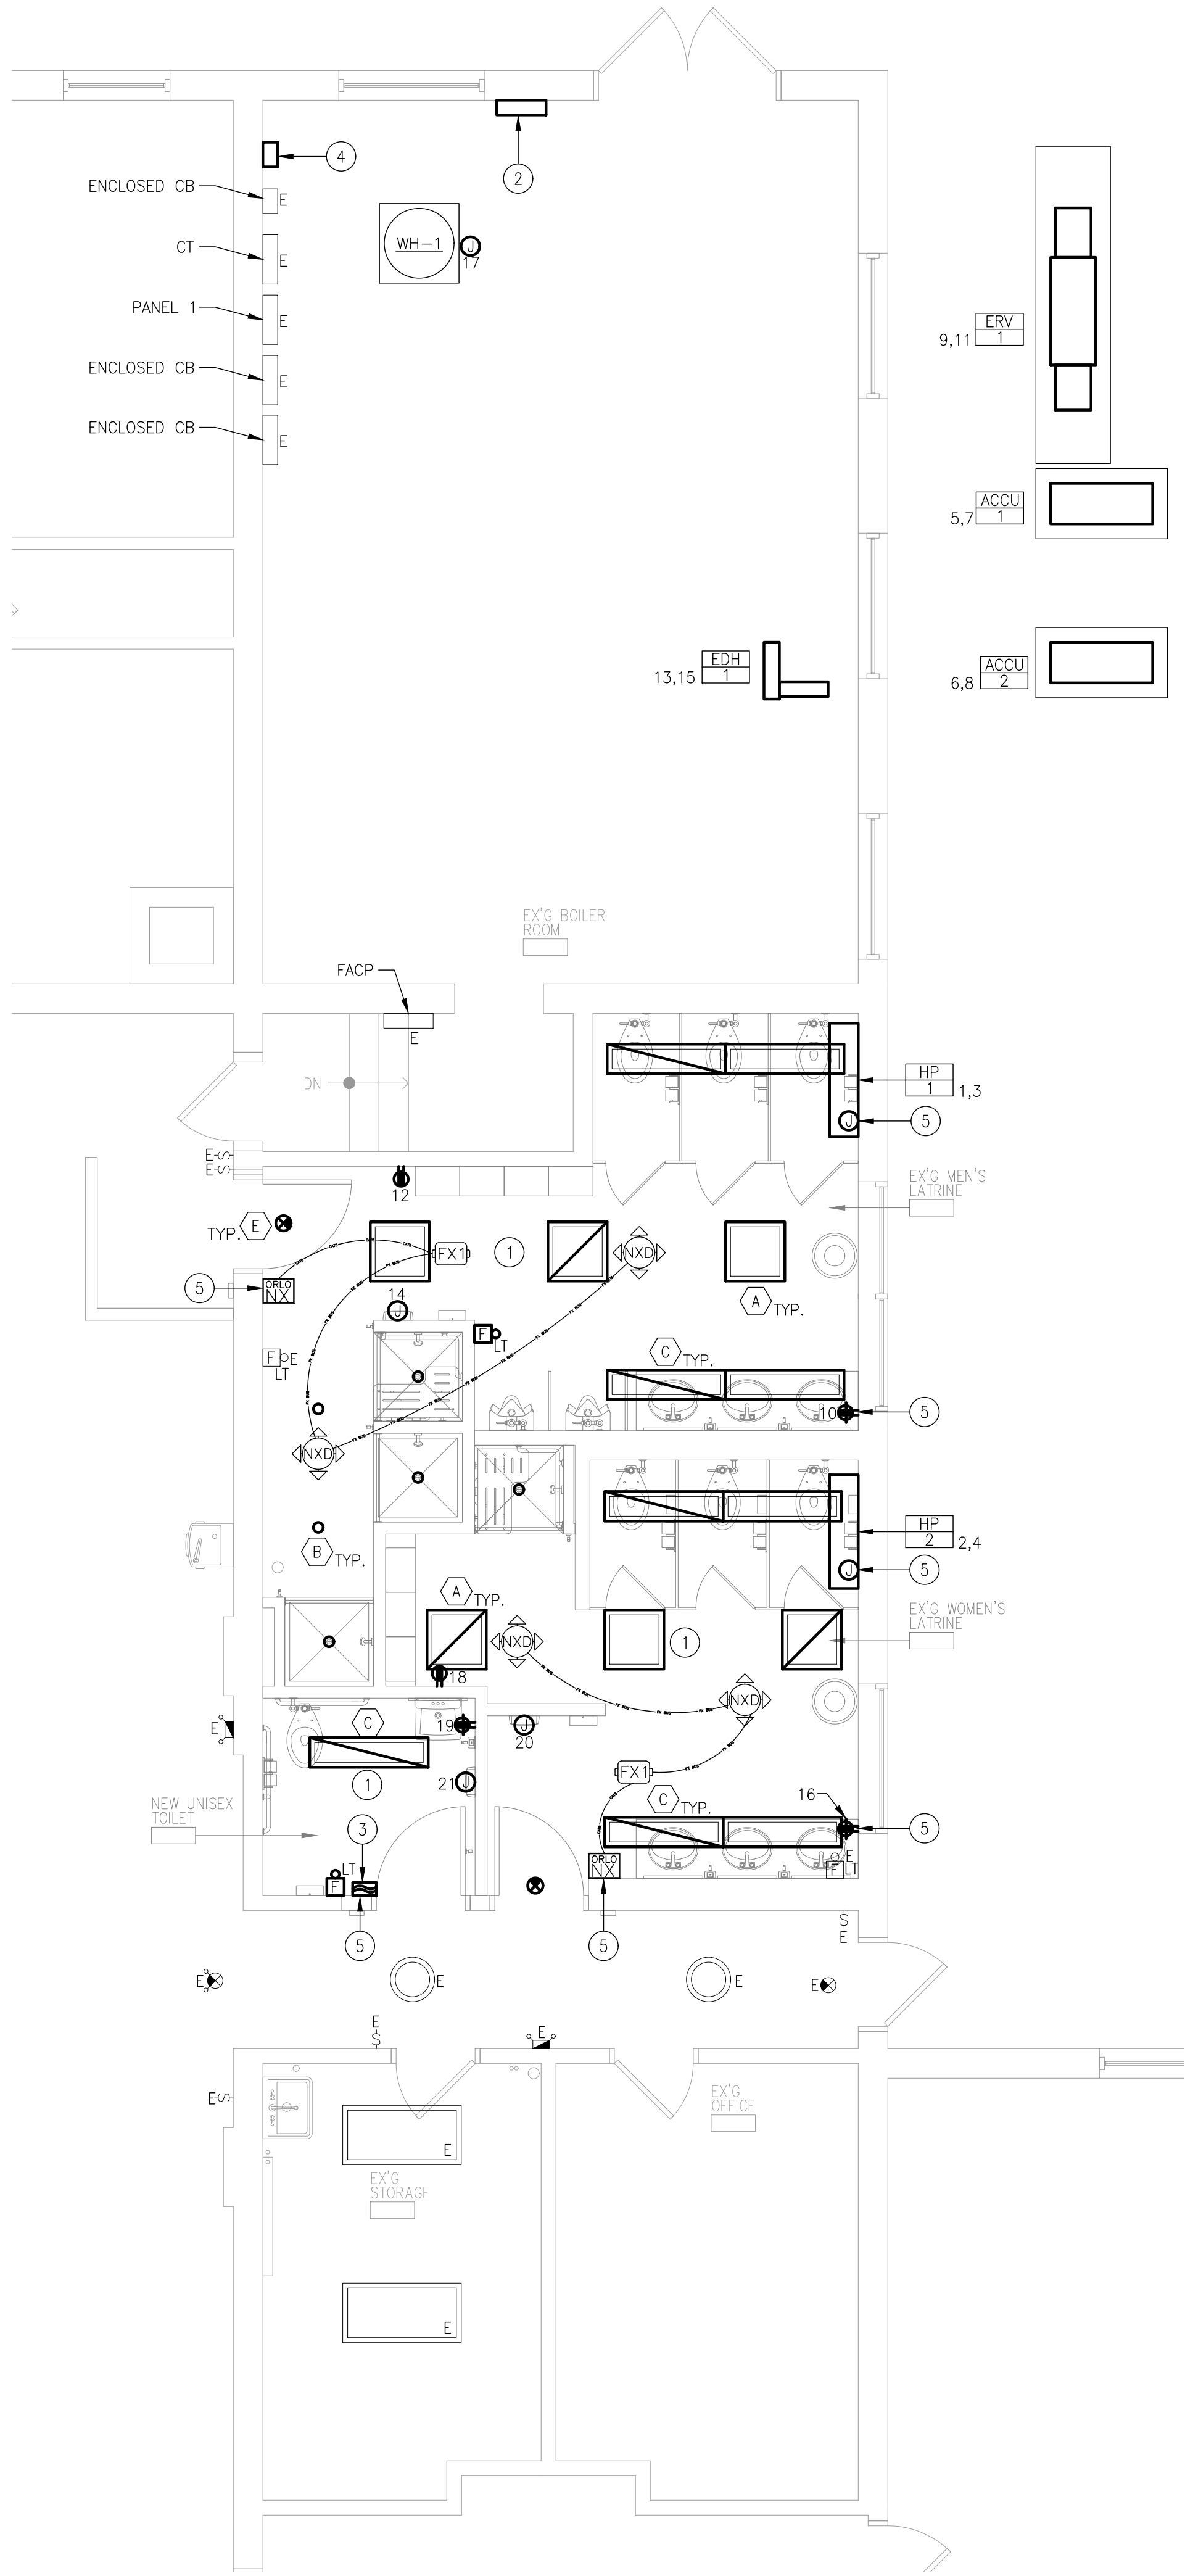

02 ELECTRICAL NEW WORK PART PLAN
E1.1 1/4"=1'-0"

KEY NOTES

1. CIRCUIT NEW LIGHTING FIXTURE TO THE LOCAL LIGHTING CIRCUIT WITH NEW CONTROL WITH (2)#12+(1)#12G-3/4".
2. PROPOSED NEW PANEL RP-1A.
3. COMBINATION WALL MOUNTED OCCUPANCY SENSOR SWITCH SHALL BE MODEL WS1000W AS MANUFACTURED BY HUBBELL.
4. PROPOSED LOCATION FOR THE NEW 200A ENCLOSED CIRCUIT BREAKER. COORDINATE FINAL LOCATION WITH THE OWNER AND ARCHITECT.
5. CONTRACTOR SHALL SAW CUT EXISTING CMU WALL TO RECESS ALL CONDUIT AND JUNCTION BOXES WITHIN WALL AT THIS LOCATION. REFER TO THE ARCHITECT'S DRAWINGS FOR PATCHING OF WALL REQUIREMENTS.

DEMOLITION GENERAL NOTES

1. CONTRACTOR SHALL VISIT THE SITE TO VERIFY EXISTING CONDITIONS PRIOR TO SUBMISSION OF BID. NO ADDITIONAL COMPENSATION SHALL BE CONSIDERED FOR FAILURE TO OBSERVE THIS REQUIREMENT.
2. THE CONTRACTOR SHALL DISCONNECT AND REMOVE ALL ELECTRICAL WIRING AND EQUIPMENT AS REQUIRED WITHIN ALL AREAS TO BE RENOVATED. THIS SHALL INCLUDE BUT NOT BE LIMITED TO FIXTURES, DEVICES, OUTLETS, SWITCHES, RECEPTACLES, STARTERS, DISCONNECTS, PANELS, FEEDERS, ETC.
3. THE CONTRACTOR SHALL DISCONNECT AND REMOVE ALL EXISTING CIRCUITS TO MECHANICAL EQUIPMENT BEING REMOVED. REFER TO ALL MECHANICAL DEMOLITION DRAWINGS OR NOTES FOR LOCATIONS.
4. WHERE ELECTRICAL ITEMS ARE REMOVED, ALL BRANCH DEVICE'S WIRING SHALL BE REMOVED BACK TO PANEL SERVICING THE EQUIPMENT. WHERE CIRCUITS SERVE ADDITIONAL DEVICES OR EQUIPMENT REMAINING, WIRING SHALL BE REMOVED BACK TO THE NEAREST ACTIVE JUNCTION BOX.
5. THE CONTRACTOR SHALL MAINTAIN CONTINUITY OF EXISTING CIRCUITS THAT ARE TO REMAIN IN OPERATION AND SCHEDULE FOR RE-FEEDING FROM NEW PANELS. FORWARD FINDINGS TO ENGINEER FOR REVIEW AND COORDINATION.
6. ALL UNUSED CIRCUITS REMAINING AFTER REMOVALS SHALL BECOME SPARE IN PANELS AND LABELED AS SPARE.
7. THE CONTRACTOR SHALL REFER TO ARCHITECTURAL DEMOLITION DRAWINGS FOR ADDITIONAL INFORMATION AND SCOPE OF DEMOLITION.
8. ALL MATERIALS AND EQUIPMENT REMOVALS SHALL BE DISPOSED OF AS DIRECTED BY THE OWNER OR THE ARCHITECT.

GENERAL NOTES

1. CIRCUIT EXIT AND EMERGENCY LIGHT FIXTURES TO LOCAL LIGHTING CIRCUIT AHEAD OF SWITCHING WITH 2#12+1#12G IN 3/4" CONDUIT.
2. COORDINATE LOCATION OF ALL DEVICES WITH THE OWNER PRIOR TO ROUGH-IN.
3. ALL DEVICES ARE CIRCUITED TO PANEL RP-1A UNLESS OTHERWISE NOTED.



KSI CONSULTING ENGINEERS, LLC
ADDRESS:
P.O. BOX 628 FARMINGDALE, NJ 07727
PHONE:
732.938.2666
FAX:
732.938.2521
CERTIFICATE OF AUTHORIZATION NO.
24GA28124300

PAUL RIPPET, P.E.
Professional Engineer
State of New Jersey
DATE: 3/31/26
KSJ PROJECT #: 2500M 27
NEW JERSEY PROFESSIONAL ENGINEER
LICENSE NUMBER: 4315806



Department of Community Affairs
Construction Project Review
Project No: 9550-26
PARTIAL RELEASE
ELECTRICAL
David Godbolt
Release Date: 4/14/2025
N.J.S.A. 52:27D-119 ET SEQ., AS AMENDED



1729 ROUTE 35
WALL, NEW JERSEY 07719
phone 732.262.0046
facsimile 732.262.0045
Email info@tm-architects.com

Michael J. Millemann, AIA
N.J. LICENSE # A114550
N.Y. LICENSE # 028885

CERTIFICATE OF AUTHORIZATION
No. AC33200

LATRINE ALTERATIONS FOR:
MT HOLLY ARMORY
I670 NJ-38
MT HOLLY, NEW JERSEY 08060
DMA PROJECT NO. MH008

REV: DATE: DESCRIPTION:

ELECTRICAL
DEMOLITION &
NEW WORK
PART PLANS

PROJECT NO: 2557 DRAWN BY: AIC


DATE ISSUED: 3/30/26

SHEET NO:

E1.1

- PLUMBING GENERAL NOTES**
- DO NOT SCALE FROM THESE DRAWINGS.
 - DO NOT MAKE ANY CHANGES OR SUBSTITUTIONS WITHOUT SPECIFIC WRITTEN APPROVAL FROM THE ARCHITECT OR ENGINEER.
 - ALL INDICATED WORK SHALL BE PERFORMED BY THE PLUMBING CONTRACTOR UNLESS OTHERWISE NOTED.
 - REFER TO THE WRITTEN SPECIFICATIONS IN CONJUNCTION WITH THE PLANS FOR FULL PROJECT SCOPE.
 - IT IS THE RESPONSIBILITY OF THE PLUMBING CONTRACTOR TO REVIEW THESE PLANS AND SPECIFICATIONS, AS WELL AS THE RELATED HVAC, FIRE PROTECTION, ELECTRICAL, STRUCTURAL, ARCHITECTURAL, INTERIOR DECOR AND SITE ENGINEERING DRAWING TO BECOME FAMILIAR WITH THE FULL PROJECT SCOPE. IN ADDITION, THIS CONTRACTOR MUST COORDINATE WITH AN OWNER REPRESENTATIVE TO FULLY UNDERSTAND ALL REQUIREMENTS WHICH MAY NOT BE SPECIFIED HEREIN AND WHICH THE OWNER MAY CONSIDER PART OF THIS CONTRACT. DURING THE COURSE OF CONSTRUCTION COORDINATION AND ACTUAL CONSTRUCTION, IT IS THE RESPONSIBILITY OF THE PLUMBING CONTRACTOR TO WORK CLOSELY WITH ALL ACCOMPANYING CONTRACTORS AND TRADESMEN IN ORDER TO ENSURE A SMOOTH RUNNING AND CAREFULLY COORDINATED INSTALLATION.
 - ANY DISCREPANCIES OR INADEQUACIES WITHIN THESE BID DOCUMENTS OR BETWEEN THESE BID DOCUMENTS AND THE RELATED HVAC, FIRE PROTECTION, ELECTRICAL, STRUCTURAL, ARCHITECTURAL, INTERIOR DECOR AND SITE ENGINEERING DRAWINGS, OR BETWEEN THESE BID DOCUMENTS AND FIELD CONDITIONS MUST BE BROUGHT TO THE ATTENTION OF THE OWNER, ARCHITECT AND ENGINEER PRIOR TO BID SUBMISSION.
 - ALL WORK SHALL BE PERFORMED IN ACCORDANCE WITH ALL APPLICABLE REGULATIONS INCLUDING BUT NOT LIMITED TO NATIONAL, CITY, STATE, LOCAL CODES AND ORDINANCES WHICH MAY BE IN EFFECT. ALL PLUMBING MATERIALS, INSTALLATION PROCEDURES AND SYSTEM LAYOUTS SHALL BE APPROVED BY ALL APPLICABLE CODE ENFORCEMENT AUTHORITIES HAVING JURISDICTION, AND IT SHALL BE THE PLUMBING CONTRACTOR'S RESPONSIBILITY TO OBTAIN AND PAY FOR ALL NECESSARY PERMITS AND APPROVALS FOR THIS INSTALLATION.
 - THE PLUMBING CONTRACTOR MUST VISIT THE SITE AND NOTE ALL EXISTING CONDITIONS AS WELL AS ALL CONDITIONS TO BE MET PRIOR TO BID SUBMISSION. LACK OF A THOROUGH UNDERSTANDING OF THE PROJECT SCOPE AND CONDITIONS SHALL NOT CONSTITUTE AN EXCUSE FOR ERRORS OR OMISSIONS, NOR FOR A REQUEST FOR EXTRA COMPENSATION.
 - IT IS CRITICAL THAT THE PLUMBING CONTRACTOR FIELD VERIFIES ALL EXISTING INVERTS PRIOR TO BID SUBMISSION. IF ANY CONFLICTS EXIST BETWEEN THE NEW PLUMBING SYSTEMS AND THE EXISTING SITE LEVEL SYSTEMS, THEY SHOULD BE BROUGHT TO THE ATTENTION OF AN OWNER'S REPRESENTATIVE AND THE ENGINEER PRIOR TO BID SUBMISSION. EXTRA COMPENSATION WILL NOT BE ALLOWED FOR ANY EXTRA WORK WHICH RESULTS FROM AN INABILITY TO MEET THE INVERTS OF THE EXISTING SITE LEVEL PIPING SYSTEMS.
 - THE PLUMBING CONTRACTOR SHALL PROVIDE A COMPLETE SET OF RECORD "AS-BUILT" DRAWINGS INDICATING THE PRECISE LOCATION OF ALL SYSTEMS, EQUIPMENT CONCEALED OR EMBEDDED PIPING, PIPING CONNECTIONS AND ACCESS DOORS. THESE DRAWINGS SHALL ALSO INCLUDE ALL CHANGES AND DEVIATIONS FROM BID DOCUMENTS.
 - RUN ALL DOMESTIC, WASTE & VENT PIPING AS HIGH AS POSSIBLE THROUGHOUT ENTIRE BUILDING. INSTALL LONG RUNS OF PIPING WITHIN STEEL (JOIST) SPACE AND OTHER PIPING TIGHT TO BOTTOM OF STEEL. COORDINATE AND VERIFY WITH OTHER CONTRACTORS AS NOT TO INTERFERE WITH DUCTWORK, FIRE PROTECTION PIPING, LIGHTING SYSTEMS, ETC.
 - ALL EXPOSED HORIZONTAL AND VERTICAL PIPING SHALL BE INSTALLED IN A NEAT ARRANGEMENT IN LOCATIONS WHICH ARE THE MOST INCONSPICUOUS. VERTICAL DROPS SHALL BE KEPT TO AN ABSOLUTE MINIMUM AND THEIR FINAL LOCATIONS SHALL BE COORDINATED AND RUN WITHIN CHASES, WALLS, SOFFITS WITH OTHER MECHANICAL/ELECTRICAL FEEDS. ALL SUCH LOCATIONS ARE TO BE REVIEWED WITH A OWNER REPRESENTATIVE AND ARCHITECT PRIOR TO INSTALLATION.
 - ALL PLUMBING FIXTURES/APPLIANCES SHALL HAVE THEIR OWN INDEPENDENT SHUT-OFF VALVES, INSTALLED IN AN EASILY ACCESSIBLE AND CONVENIENT LOCATION.
 - ALL DOMESTIC WATER BRANCH LINES SHALL HAVE THEIR OWN RESPECTIVE SHUT-OFF VALVES.
 - DOMESTIC HOT WATER HEATER TEMPERATURE/PRESSURE RELIEF VALVES SHALL BE PIPED FULL SIZE TO THE NEAREST APPROVED STANDPIPE OR FLOOR DRAIN. THIS REQUIREMENT SHALL BE APPLICABLE TO ALL DOMESTIC WATER HEATERS EXCEPT INSTANTANEOUS WATER HEATERS.
 - ALL PLUMBING VENT LINES NOTED AS "V. UP" OR "VENT UP" SHALL BE CONNECTED TO THE NEAREST APPROVED "V.T.R." OR VENT THRU ROOF.
 - PRIOR TO INSTALLING SYSTEMS, THE PLUMBING CONTRACTOR SHALL MEET WITH THE ARCHITECTS REPRESENTATIVE TO FIELD VERIFY THE EXACT LOCATION OF ALL PROPOSED EQUIPMENT WHICH MAY NOT BE CLEARLY INDICATED ON THE DRAWINGS.
 - PROVIDE C.O.'S AT THE BASE OF ALL SANITARY AND STORM STACKS.
 - SANITARY SEWER PIPING SHOWN IS BASED ON .25" PER FOOT FALL FOR ALL PIPING SMALLER THAN 4", AND .125" PER FOOT FALL FOR ALL PIPING 4" AND LARGER.
 - PROVIDE ALL SAW CUTTING AND PATCHING AS REQUIRED TO ACCOMMODATE ALL NEW PIPING AND FIXTURE INSTALLATION.
 - LEAD FREE REQUIREMENT: PRODUCTS DESIGNED FOR DISPENSING POTABLE WATER SHALL MEET NSF 61 AND NSF 372 TEST STANDARDS VIA THIRD-PARTY TESTING AND CERTIFICATION.


- DEMOLITION NOTES**
- ALL PIPING AND EQUIPMENT TO BE REMOVED SHALL BE REMOVED BACK TO NEAREST STACK, RISER, OR MAIN IN ACCORDANCE WITH ALL STATE AND LOCAL REGULATIONS/STANDARDS, CODES AND AUTHORITY HAVING JURISDICTION.
 - REMOVE ANY ABANDONED AND/OR UNUSED PIPING DISCOVERED DURING DEMOLITION. THERE SHALL BE NO DEAD-ENDS GREATER THAN 24 INCHES IN ANY PLUMBING PIPING SYSTEMS.
 - DURING DEMOLITION ANY DAMAGES DISCOVERED IN EXISTING PIPING TO REMAIN SHOULD BE BROUGHT TO THE ATTENTION OF THE ENGINEER.
 - ALL EXISTING PIPING AND APPURTENANCES TO REMAIN SHALL BE PROTECTED FROM DAMAGE DURING DEMOLITION. ANY DAMAGES INCURRED SHALL BE REPAIRED OR REPLACED AT NO COST TO THE OWNER.
 - THE CONTRACTOR SHALL COORDINATE, NOTIFY, AND SCHEDULE ALL REMOVALS WITH THE OWNER PRIOR TO PROCEEDING WITH THE WORK.
 - THIS CONTRACTOR SHALL INCLUDE ALL COSTS FOR REMOVAL AND RELOCATIONS IN THE CONTRACT.
 - THE CONTRACTOR PRIOR TO BID SHALL VISIT THE SITE, EXAMINE THE EXISTING CONDITIONS, DRAWINGS AND NOTIFY THE ARCHITECT/ENGINEER OF ANY DISCREPANCIES PRIOR TO BIDDING. CONTRACTOR WILL BE RESPONSIBLE FOR ANY UNREPORTED DISCREPANCIES.
 - THE CONTRACTOR SHALL COORDINATE ALL SHUTDOWNS AND IDENTIFY ANY WORK WHICH MAY BE REQUIRED TO BE PERFORMED ON OVERTIME IN ORDER NOT TO DISTURB OCCUPIED SPACES WHICH ARE NOT WITHIN THE SCOPE OF THIS CONTRACT. OBTAIN WRITTEN APPROVAL OF THE OWNER PRIOR TO PERFORMING ANY SHUTDOWNS OR PERFORMING WORK ON OVERTIME.
 - REFER TO ARCHITECTURAL DRAWINGS FOR ADDITIONAL DEMOLITION INFORMATION AND PHASING SEQUENCE.
 - CONTRACTOR TO MAINTAIN UTILITY SYSTEMS OPERATIONAL DURING CONSTRUCTION. CONTRACTOR TO PROVIDE TEMPORARY MEASURES TO MAINTAIN SYSTEMS IN THE COST OF THE BID.
 - CONTRACTOR TO PATCH ALL HOLES, PENETRATIONS, AND ABANDONED HOLES CREATED BY RENOVATIONS. PATCH WALL AND FLOOR SLABS TO MATCH ADJACENT SURFACES.

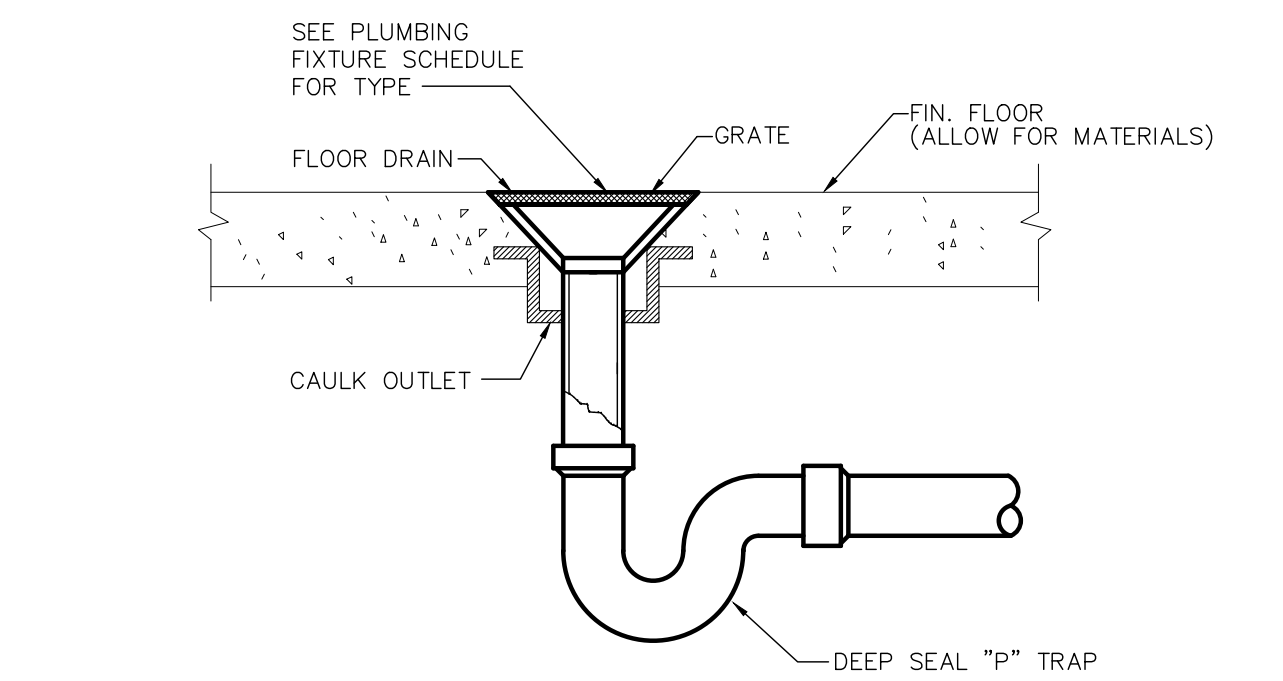


05
P0.1 N.T.S.

TYPICAL FLOOR DRAIN DETAIL

PLUMBING SYMBOLS

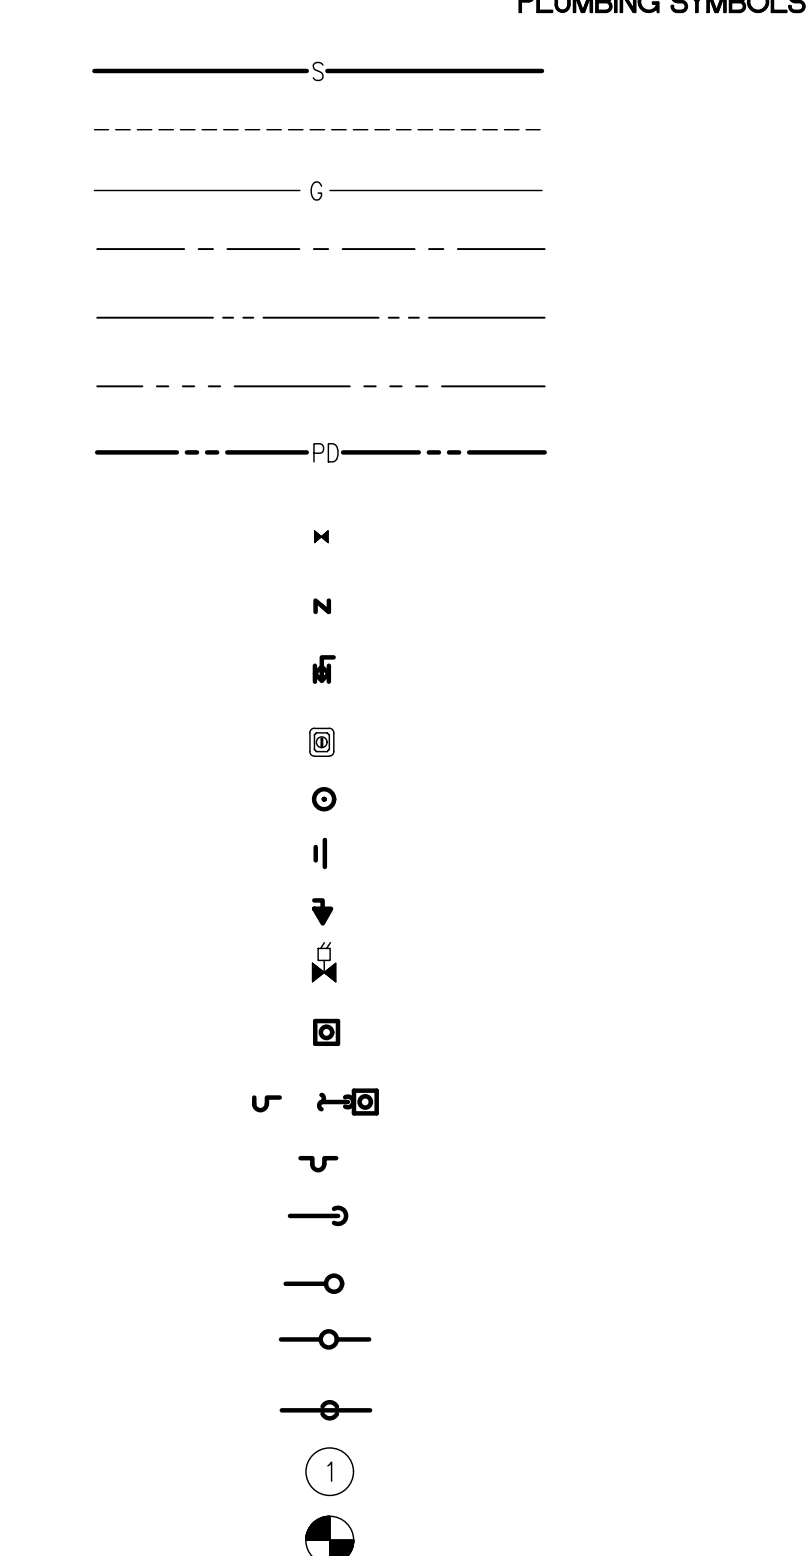


NOTE: NOT ALL SYMBOLS ARE USED ON THIS PROJECT.

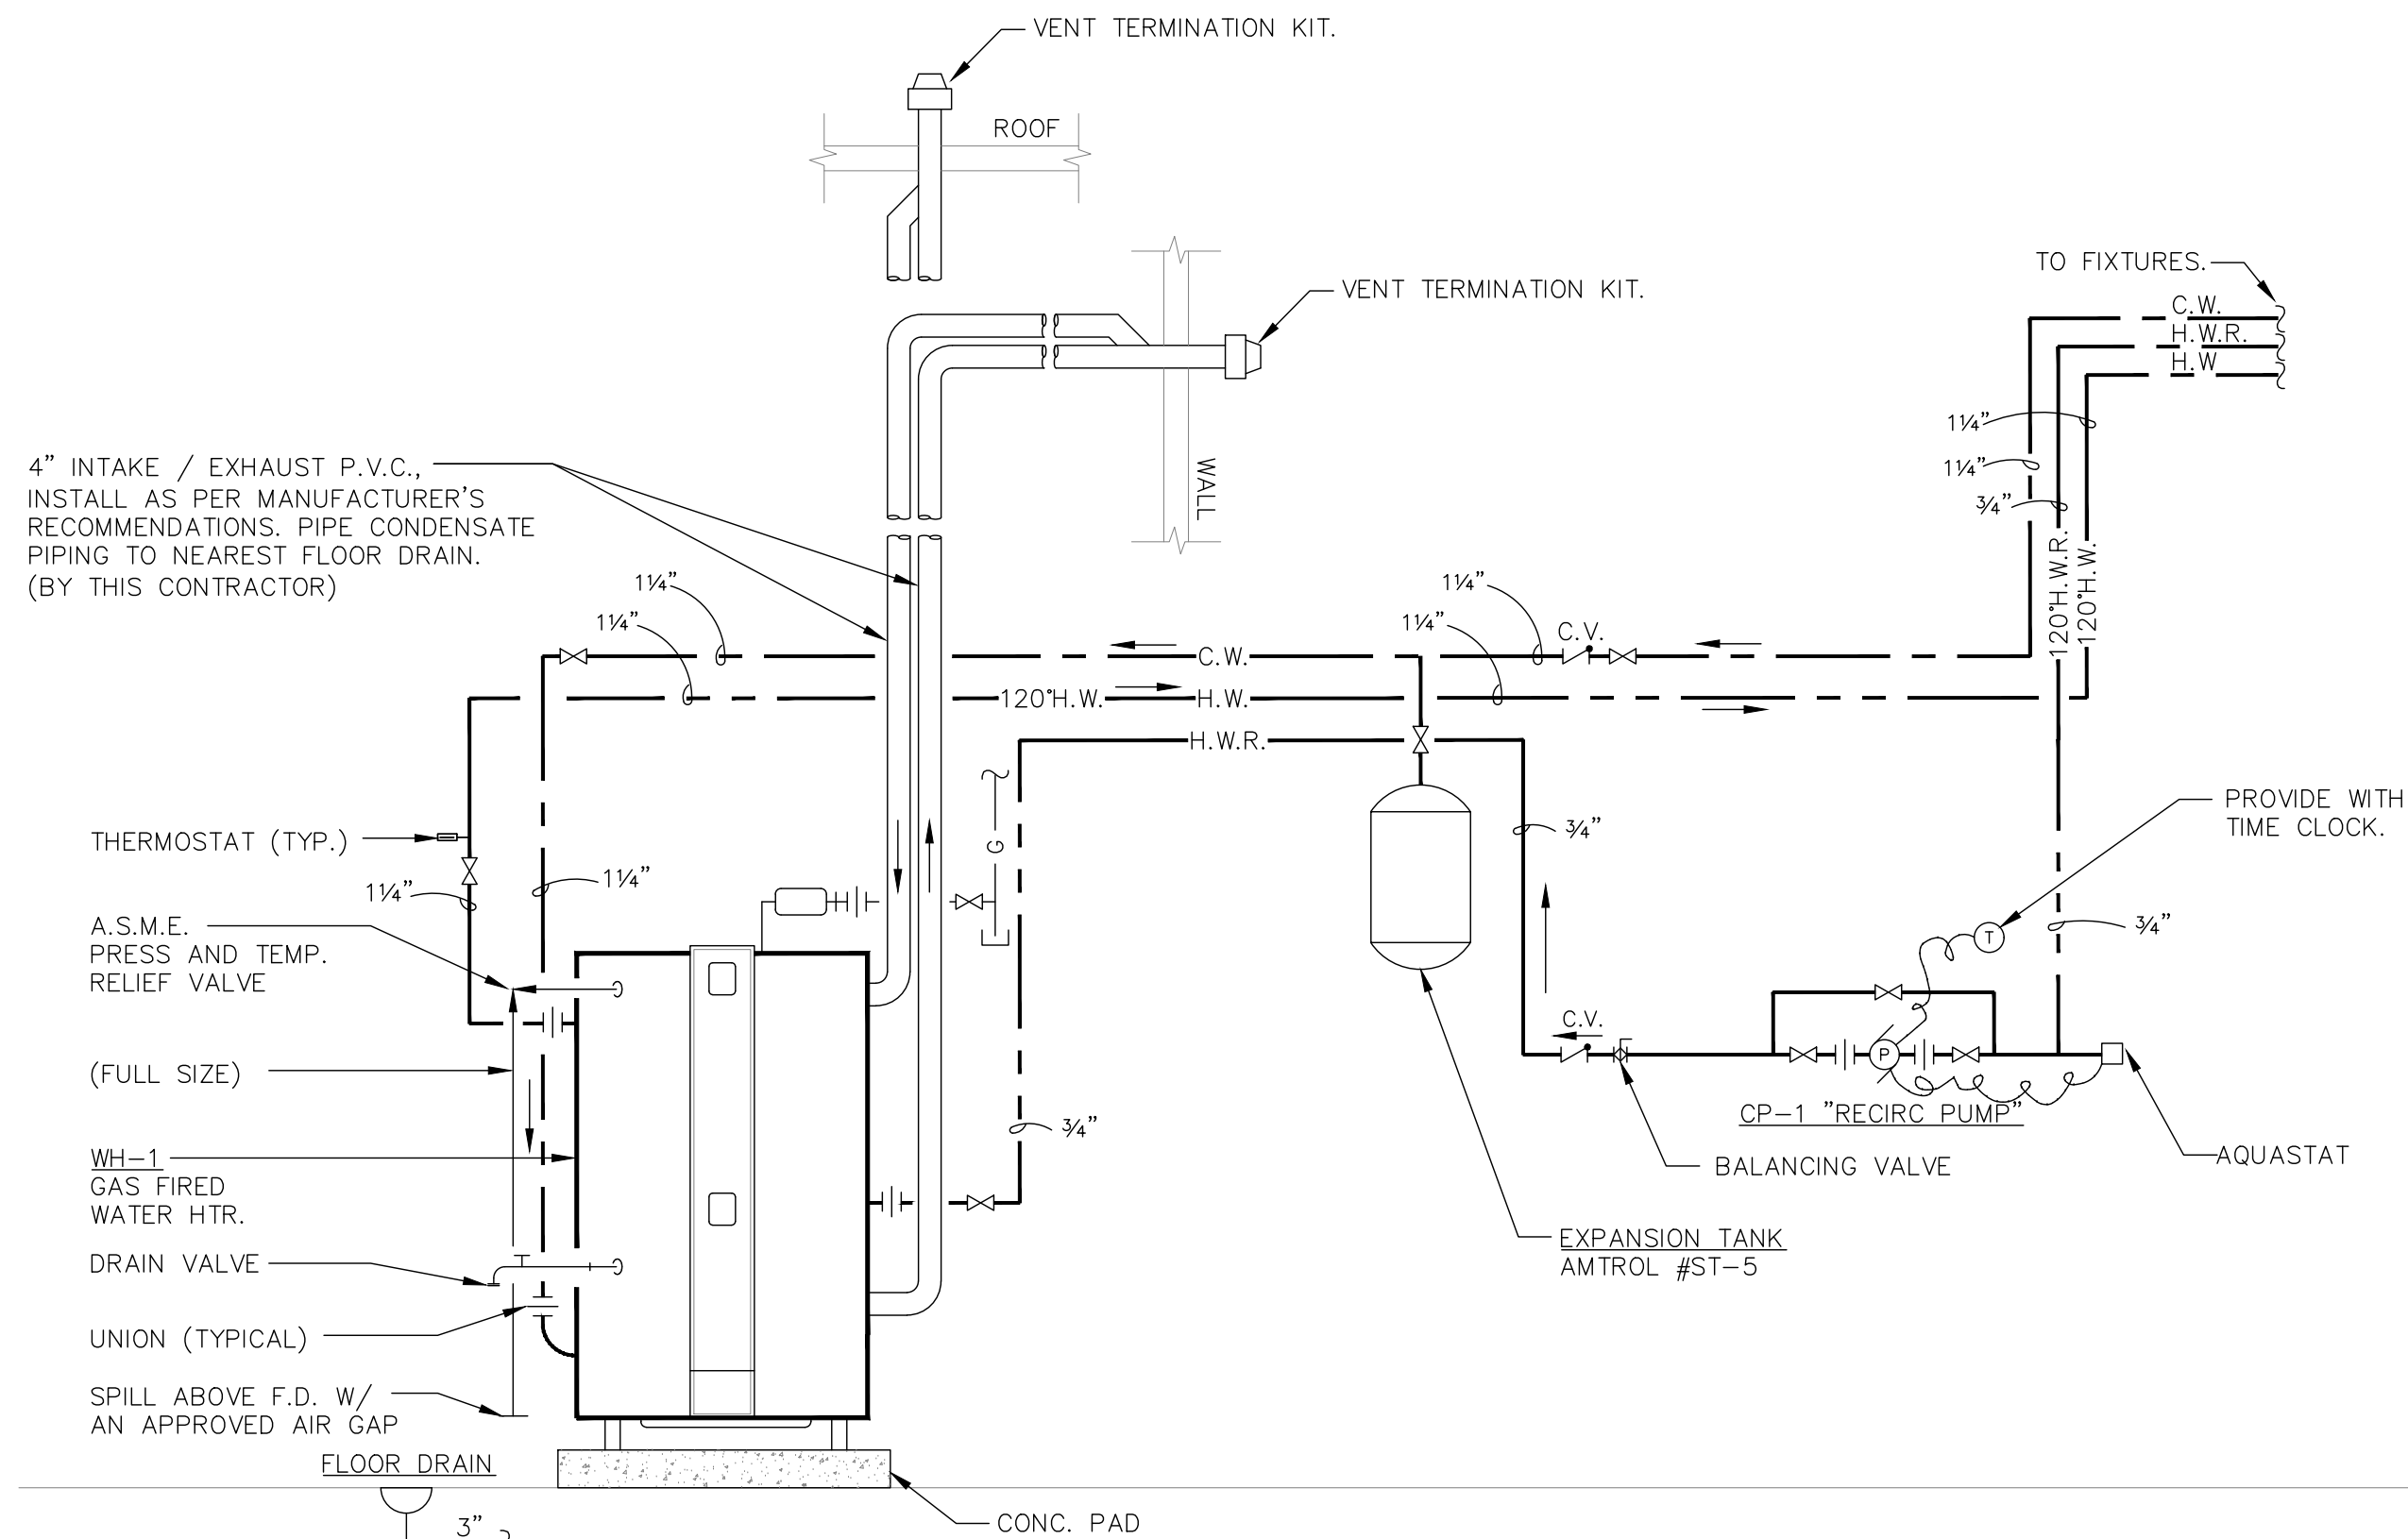

03
P0.1 N.T.S.

WATER HEATER INSTALLATION WH-1

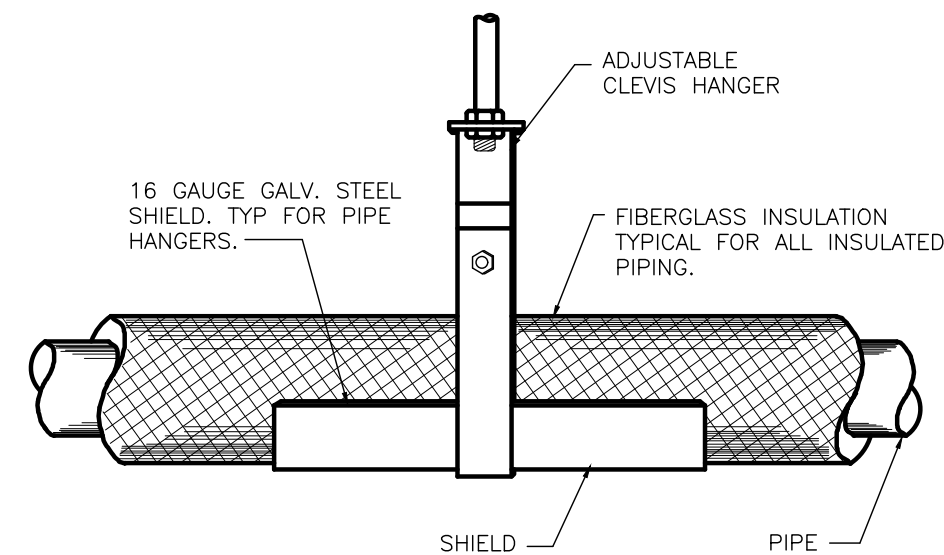


06
P0.1 N.T.S.

TYPICAL HANGER DETAIL

PLUMBING ABBREVIATIONS


SANITARY WASTE	A.F.W.H.	ANTI-FREEZE WALL HYDRANT
VENT LINE	A.D.	ACCESS DOOR
NATURAL GAS	A.F.F.	ABOVE FINISHED FLOOR
COLD WATER	B.F.P.	BACK FLOW PREVENTOR
HOT WATER	CA	COMPRESSED AIR
HOT WATER RETURN	CO.	CLEAN OUT
PUMP DISCHARGE	C.O.D.P.	CLEAN OUT DECK PLATE
BALL VALVE	D.I.	DRAINAGE INLET
CHECK VALVE	EXIST.	EXISTING
BALANCING VALVE	E.W.C.	ELECTRIC WATER COOLER
GAS PRESSURE REGULATOR	F.A.I.	FRESH AIR INLET
CLEAN OUT DECK PLATE	FD.	FLOOR DRAIN
HORIZONTAL CLEANOUT	G.E.	GRADE ELEVATION
GAS COOK	H.B.	HOSE BIBB
GAS SOLENOID VALVE	I.E.	INVERT ELEVATION
FLOOR DRAIN	LAV.	LAVATORY
P TRAP	LDR.	LEADER
PIPE DOWN, DROP & RISE	N.C.	NORMALLY CLOSED
PIPE UP	N.I.C.	NOT IN CONTRACT
TEE PLAN UP	O.F.	OVERFLOW LEADER
TEE PLAN DOWN	O.R.D.	OVER-FLOW ROOF DRAIN
KEY NOTE	O.W.	OIL WASTE
CONNECT TO EXISTING	R.D.	ROOF DRAIN
	S.	SANITARY
	S.A.	SHOCK ARRESTOR
	SK.	SINK
	S.S.	SERVICE SINK
	ST	STORM DRAINAGE
	T.E.	TOP ELEVATION
	UR.	URINAL
	VAC	VACUUM
	V.B.	VACUUM BREAKER
	V.T.R.	VENT THRU ROOF
	W.	WASTE
	W.C.	WATER CLOSET
	W.C.O.	WALL CLEAN OUT

NOTE: NOT ALL ABBREVIATIONS ARE USED ON THIS PROJECT.

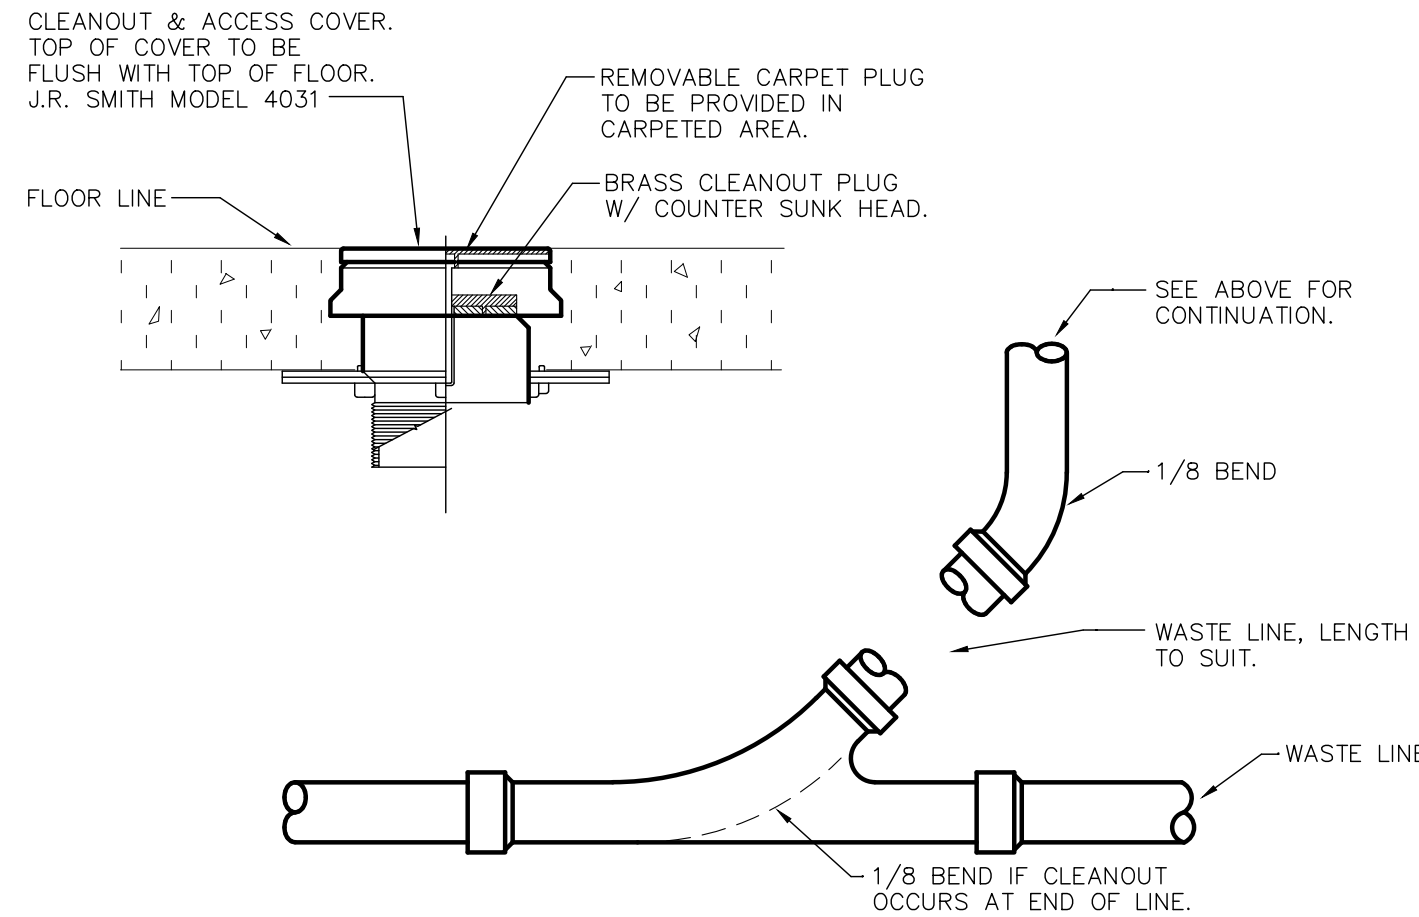


01
P0.1 N.T.S.

TYPICAL FLOOR CLEANOUT DETAIL

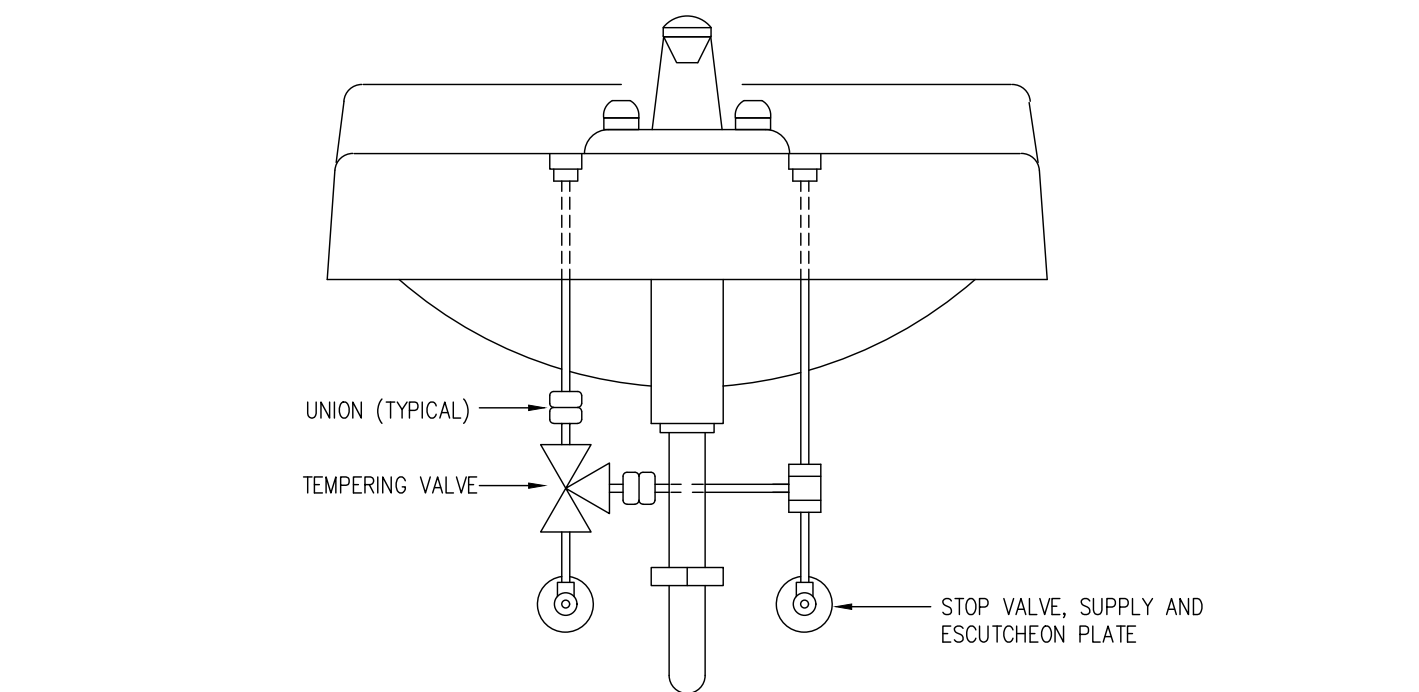

02
P0.1 N.T.S.

POINT OF USE TEMPERING VALVE

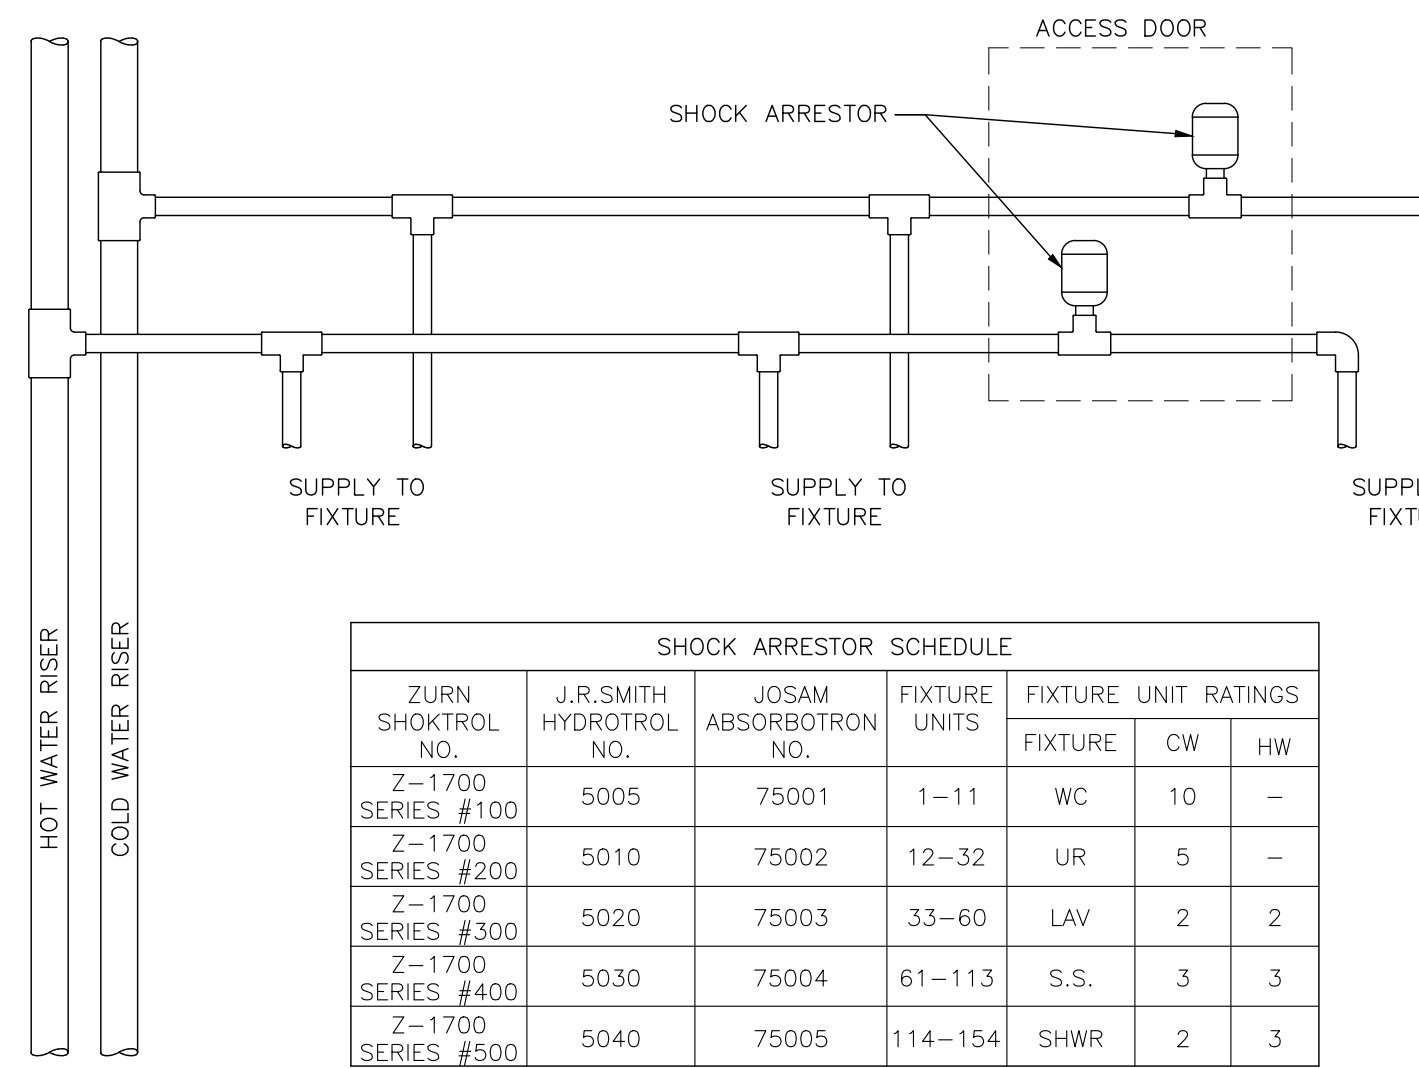


- NOTES:
- ARRESTORS SHALL BE ACCESSIBLE FOR REPLACEMENT BY WAY OF ACCESS DOOR.
 - APPROVED ARRESTORS SHALL BE INSTALLED ON WATER DISTRIBUTION SYSTEMS IN WHICH QUICK CLOSING VALVES ARE INSTALLED. MULTIPLE ARRESTOR INSTALLATIONS SHALL BE AS PER P.D.I. STANDARDS.

04
P0.1 N.T.S.

SHOCK ARRESTOR DETAIL

PLUMBING FUTURE SCHEDULE													
NO.	FIXTURE	MFG.	TYPE AND MODEL NO.	TRIM NO.	SUPPLY PIPE NO.	TRAP NO.	SUPPORT NO.	PIPE SIZES					REMARKS
								TRAP	WASTE	VENT	CW	HW	
P-1	WATER CLOSET	AMERICAN STANDARD	MADERA 2234.001	SLOAN ROYAL 111-1.28	-	-	-	-	4"	2"	1"	-	ELONGATED OPEN FRONT SEAT. 1.28 G.P.F.
P-1A	WATER CLOSET (ACCESSIBLE)	AMERICAN STANDARD	MADERA 3461.001	SLOAN ROYAL 111-1.28	-	-	-	-	4"	2"	1"	-	ELONGATED OPEN FRONT SEAT. 1.28 G.P.F.
P-2	LAVATORY	AMERICAN STANDARD	AQUALYN 0476.028	SYMMONS S-20-2-0.5	McGUIRE LF	8090/PRORAIN	-	1-1/2"	1-1/2"	1-1/2"	1/2"	1/2"	VITREOUS CHINA LAVATORY, 0.5 GPM FAUCET & MIXING VALVE. ACORN: ST70CP-38-MB, STOPS WITH LOOSE KEY SUPPLIES.
P-2A	LAVATORY	AMERICAN STANDARD	LUCERNE 0355.012	SYMMONS S-20-2-0.5	McGUIRE LF	8090/PRORAIN	MIFAB	1-1/2"	1-1/2"	1-1/2"	1/2"	1/2"	VITREOUS CHINA LAVATORY, 0.5 GPM FAUCET & MIXING VALVE. ACORN: ST70CP-38-MB, STOPS WITH LOOSE KEY SUPPLIES.
P-3	URINAL	AMERICAN STANDARD	WASHBROOK 6590.001	SLOAN ROYAL 186-0.125	-	-	MIFAB	2"	2"	1-1/2"	3/4"	-	0.125 G.P.F.
P-4	SHOWER	FIAT	36MFT	SYMMONS ORIGINS S-9601-P-VF-X	-	-	-	2"	2"	1-1/2"	1/2"	1/2"	2.5 GPM PRESSURE BALANCING MIXING VALVE. WITH TERRAZZO SHOWER BASE 36" X 36".
P-4A	SHOWER (ACCESSIBLE)	SYMMONS	-	ORIGINS S-9605-PLR-VF-X	-	-	-	2"	2"	1-1/2"	1/2"	1/2"	2.5 GPM PRESSURE BALANCING MIXING VALVE. ROLL-IN SHOWER WITH FLOOR DRAIN. SHOWER/HAND HELD SHOWER AND 36" SLIDE BAR. PROVIDE WITH SEDIMENT BUCKET AND MI-GUARD TRAP SEAL.
F.D.	FLOOR DRAIN	MIFAB	F1000-7-5	-	-	P-TRAP	-	-	-	-	-	-	
NOTES:													
1	PROVIDE DEEP SEAL TRAPS ON ALL TOILET ROOM FLOOR DRAINS.												
2	PROVIDE McGUIRE PRO-WRAP INSULATING KIT ON TRAPS AND HOT AND COLD WATER SUPPLIES TO ALL HANDICAPPED LAVATORIES. SEE ARCHITECTURAL DRAWINGS FOR LOCATIONS OF HANDICAPPED FIXTURES.												
3	PRIOR TO SUBMITTING SHOP DRAWINGS, THE CONTRACTOR SHALL COORDINATE FIXTURE TYPES AND COLORS WITH THE ARCHITECT.												
4	ALL HANDICAPPED FIXTURES SHALL BE INSTALLED AS PER ICC/ANSI A117.1-2017 REQUIREMENTS.												
5	ALL LAVATORIES AND HAND SINKS SHALL BE PROVIDED WITH THERMOSTATIC MIXING VALVES (ASSE 1070). MAXIMUM TEMPERATURE SHALL BE SET TO 110°F.												

PLUMBING EQUIPMENT SCHEDULE											
GENERAL				DESIGN DATA				ELECTRICAL			
ITEM	SERVICE	MFR.	NO.	LOCATION	CAPACITY	PUMP HEAD	H.P./K.W.	R.P.M.	VOLTS	PHASE	REMARKS
WH-1	WATER HEATER	BRADFORD WHITE	EF-100T-130E-3N	SEE DRAWINGS	100 GAL.	257 G.P.H. @ 68 DEG. RISE	-	-	120	1	PROVIDE WITH CONCRETE PAD AND NEUTRALIZATION KIT.
CP-1	CIRC. PUMP	BELL&GOSSETT	NBF-85/LW	SEE DRAWINGS	1 G.P.M.	1 G.P.M. @ 7 T.D.H.	39 WATTS	2800	115	1	PROVIDE WITH TIME CLOCK. TC-1

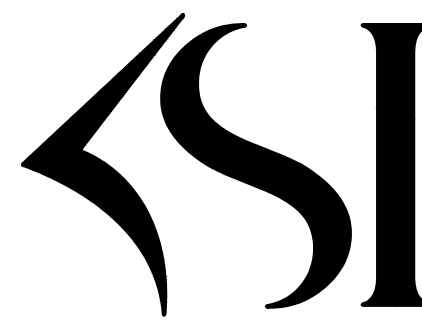

KSI CONSULTING ENGINEERS, LLC
ADDRESS:
P.O. BOX 628 FARMINGDALE, NJ 07727
PHONE:
732.938.2666
FAX:
732.938.2521
CERTIFICATE OF AUTHORIZATION NO.
24GA28124300

PAUL RIPPET, P.E.
Professional Engineer
State of New Jersey
DATE: 3/15/26
KS PROJECT #: 250041 27
NEW JERSEY PROFESSIONAL ENGINEER
LICENSE NUMBER: 4315900

Department of Community Affairs
Construction Project Review
Project No: 9050-26
partial release
Thomas Williams
Released: 4/20/2018
N.J.S.A. 52:27D-119 ET SEQ., AS AMENDED

tm
TOKARSKI + MILLEMANN
ARCHITECTS, LLC

1729 ROUTE 35
WALL, NEW JERSEY 07719
phone 732.262.0046
facsimile 732.262.0045
Email info@tm-architects.com

Michael J. Millemann, AIA
N.J. LICENSE # A1 14550
N.Y. LICENSE # 028895

CERTIFICATE OF AUTHORIZATION
No. AC33200

LATRINE ALTERATIONS FOR:
MT HOLLY ARMORY
1670 NJ-38
MT HOLLY, NEW JERSEY 08060
DMA PROJECT NO. MH008

REV: DATE: DESCRIPTION:


**PLUMBING
GENERAL
INFORMATION**

PROJECT NO: 2557 DRAWN BY: JAH


DATE ISSUED: 3/30/26

SHEET NO:


P0.1

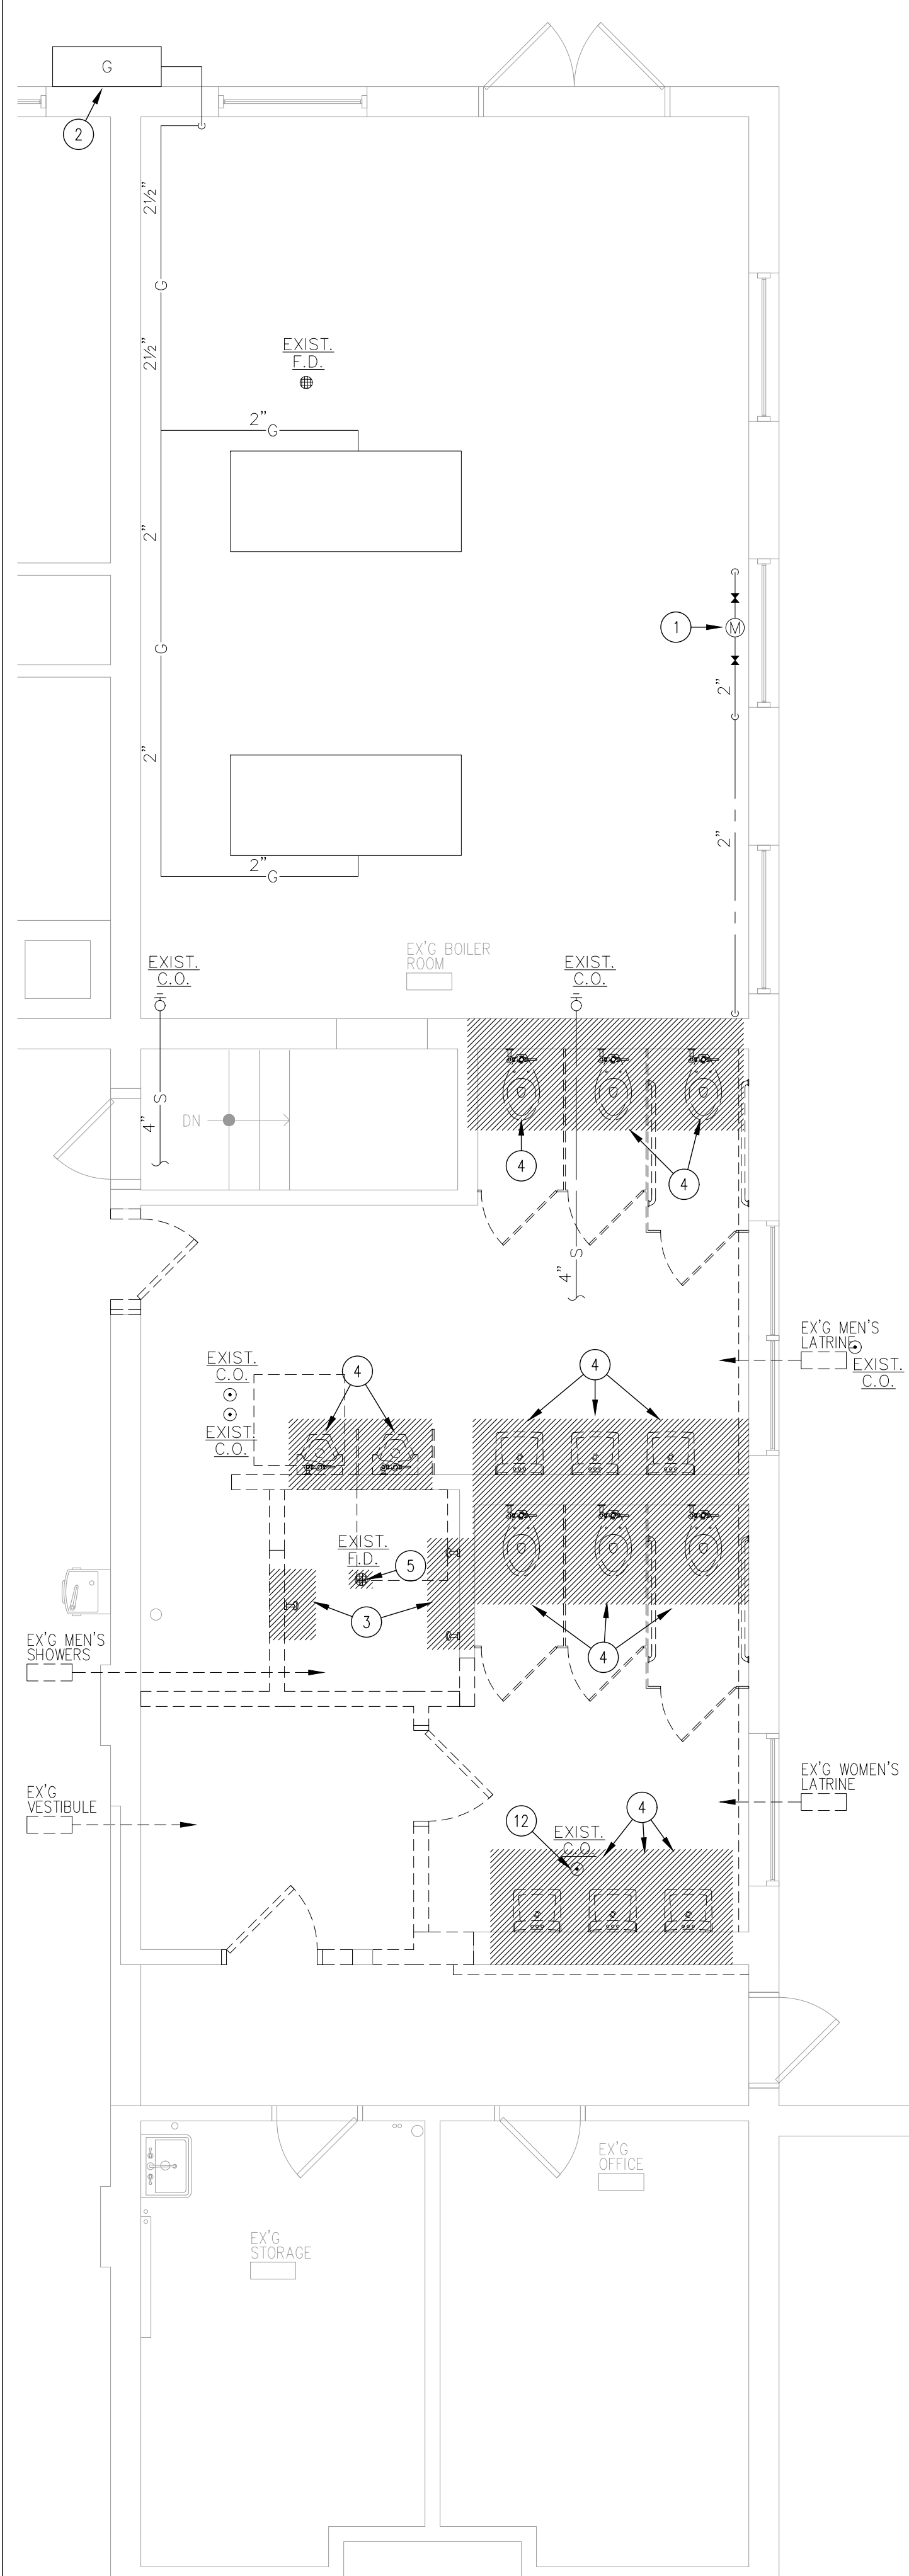

01 PLUMBING DEMOLITION PART PLAN
P1.1 1/4"=1'-0"

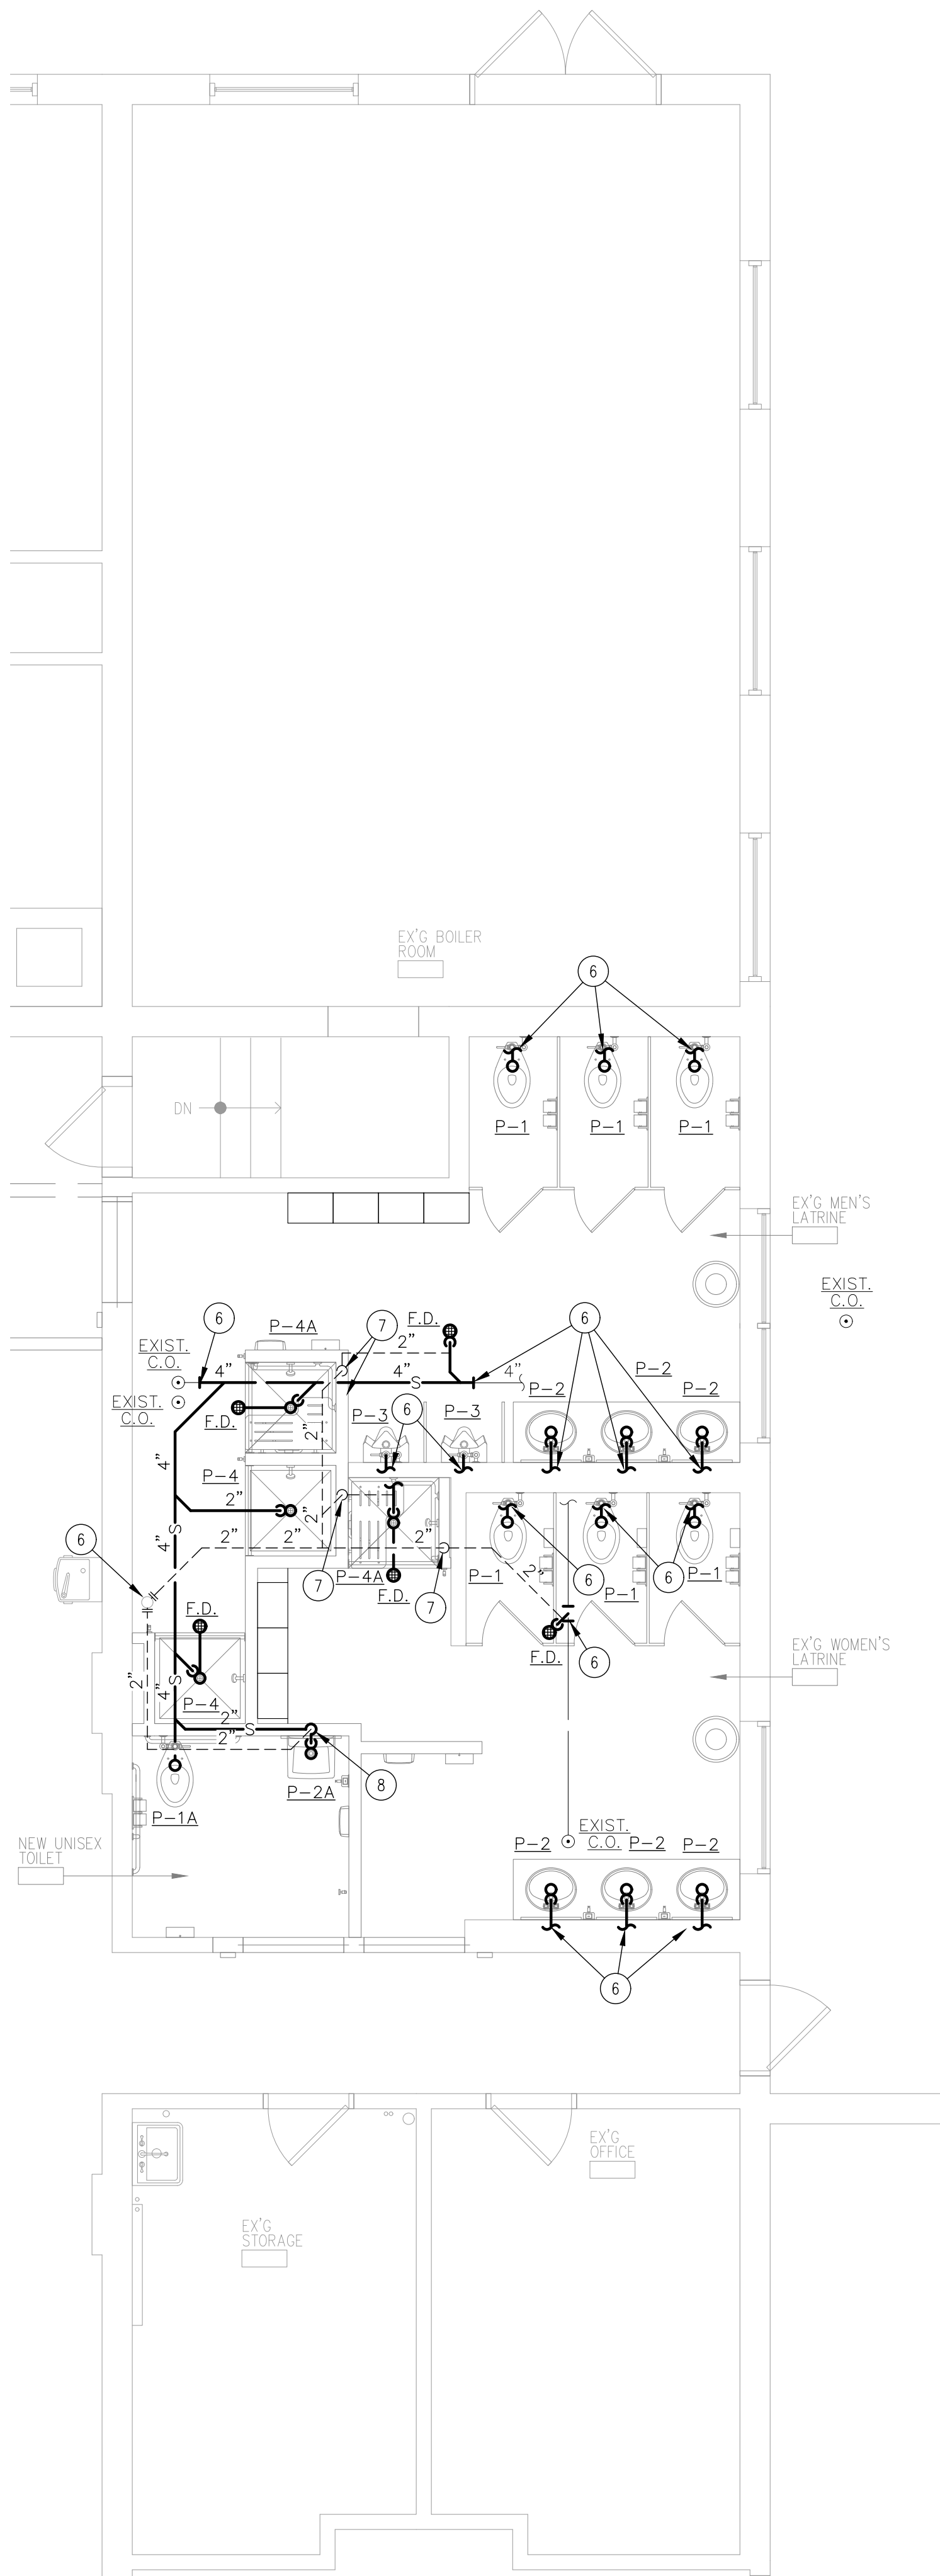

02 PLUMBING NEW WORK PART PLAN - WASTE AND VENT
P1.1 1/4"=1'-0"

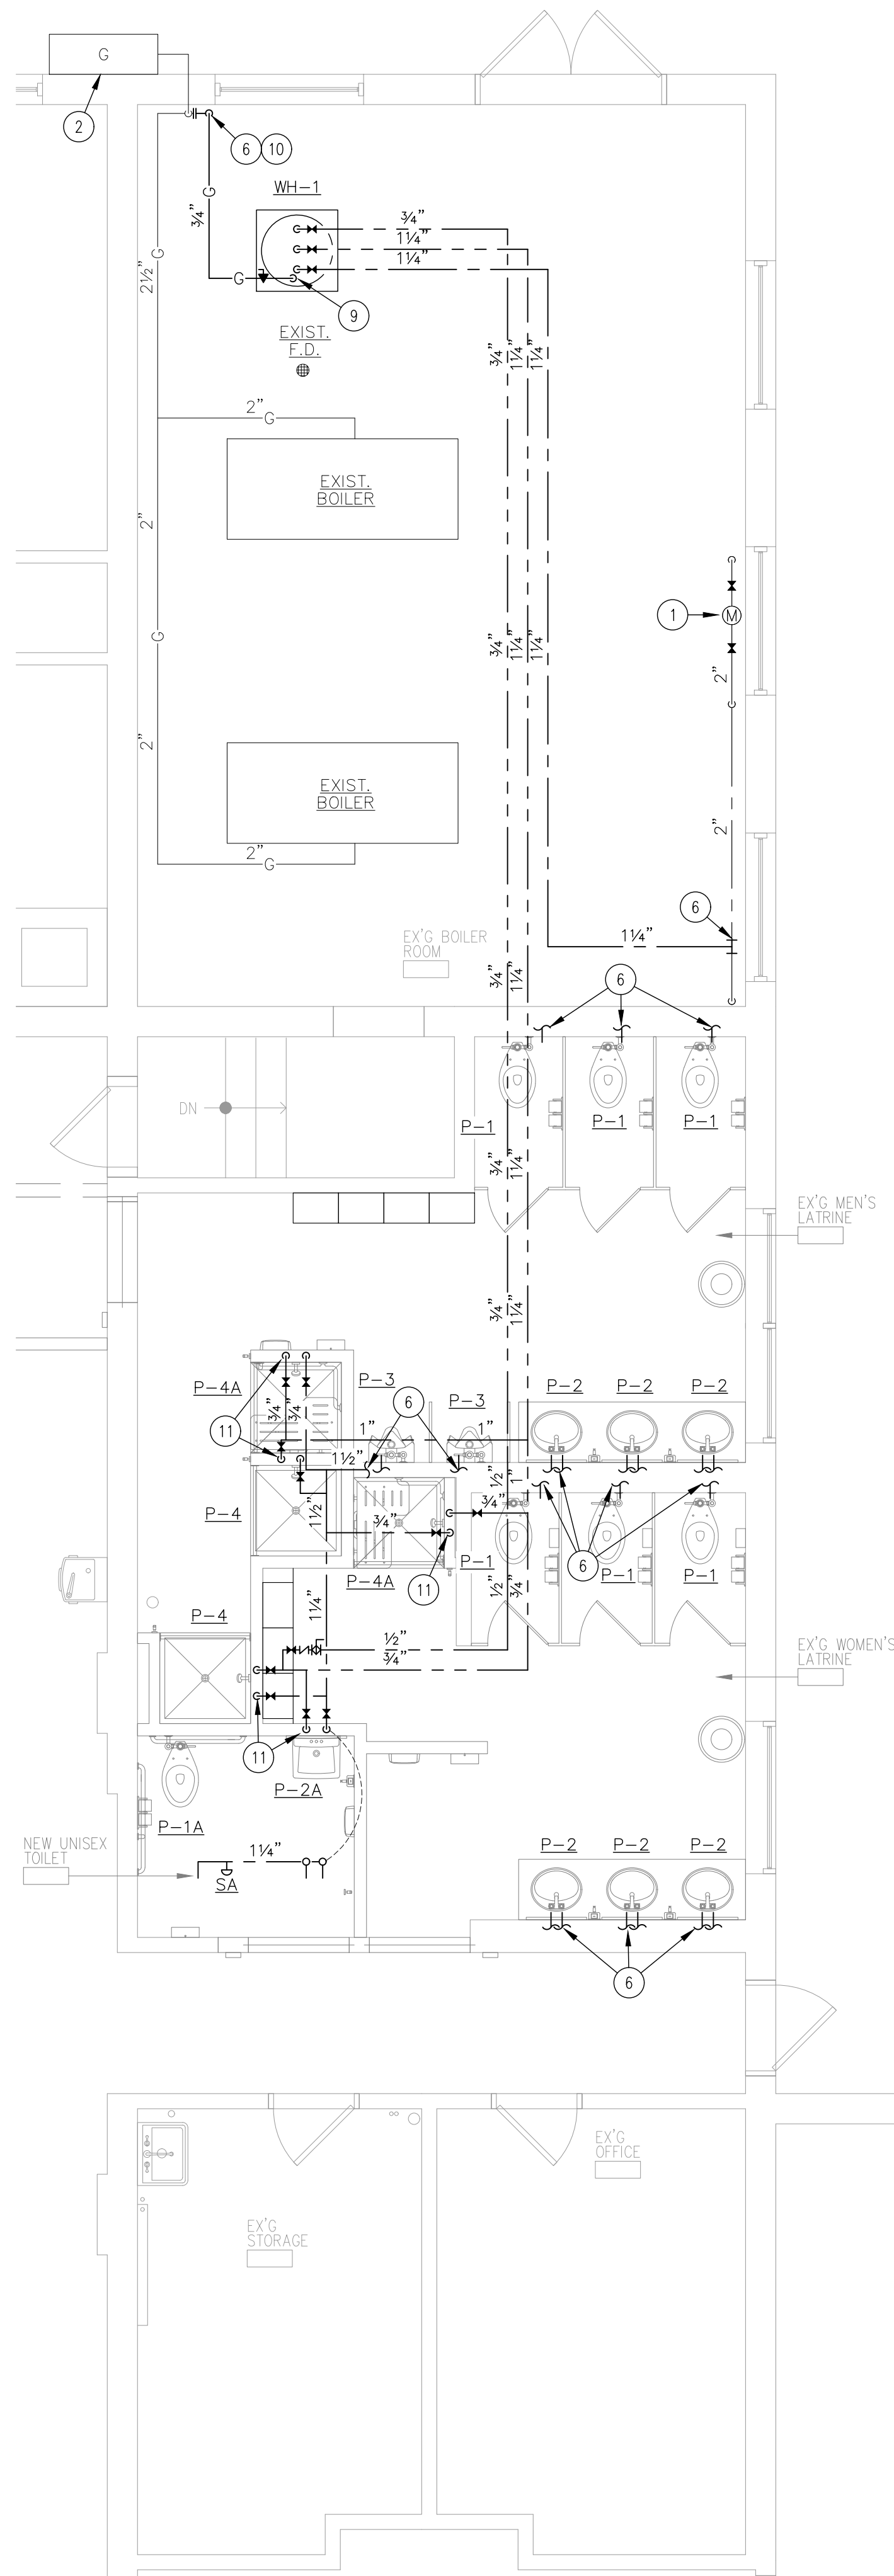

03 PLUMBING NEW WORK PART PLAN - WATER AND GAS
P1.1 1/4"=1'-0"

KEY NOTES

- EXISTING 2" WATER SERVICE AND METER TO REMAIN.
- EXISTING GAS METER TO REMAIN. GAS PRESSURE SET TO 1 PSI. CONTRACTOR SHALL COORDINATE NEW GAS LOADS WITH UTILITY COMPANY.
- REMOVE EXISTING PLUMBING FIXTURE(S) AND ALL ASSOCIATED PIPING BACK TO ACTIVE MAINS.
- REMOVE AND REPLACE EXISTING PLUMBING FIXTURE(S) AND MODIFY ALL ASSOCIATED PIPING TO ACCOMMODATE NEW. REFER TO NEW WORK DRAWINGS FOR NEW PIPING LAYOUT.
- EXISTING FLOOR DRAIN AND ALL EXISTING PIPING SHALL BE REMOVED BACK TO ACTIVE MAIN.
- CONNECT TO EXISTING. CONTRACTOR SHALL VERIFY EXISTING IN FIELD.
- V. RISE.
- W. DN. & V. RISE.
- H.W., C.W., H.W.R. AND GAS PIPING DROP AND CONNECT TO WATER HEATER MOUNTED ON CONCRETE PAD.
- GAS PIPING RISE.
- H.&C.W. DROP AND CONNECT TO PLUMBING FIXTURE(S).
- REMOVE AND RELOCATE EXISTING CLEANOUT. REFER TO NEW WORK PLANS FOR NEW CLEANOUT LOCATION.

GENERAL NOTES

- PROVIDE THERMOSTATIC MIXING VALVES AT LAVATORIES/HAND SINKS IN ACCORDANCE WITH ASSE 1070.
- PROVIDE SHOCK ARRESTORS ON BRANCH PIPING SUPPLYING QUICK CLOSING VALVES.
- PATCH AND REPAIR/REPLACE ALL MASONRY WALLS AT PIPING IN PREPARATION FOR FINISH WALL TILE.

Table B.7.3.C - TYPE L COPPER TUBE									
TUBE SIZE	4 FPS VELOCITY				8 FPS VELOCITY				TUBE SIZE
	WSFU (tanks)	WSFU (valves)	FLOW (gpm)	PD (psi/100ft)	WSFU (tanks)	WSFU (valves)	FLOW (gpm)	PD (psi/100ft)	
3/8"			1.8	7.8	2		2.3	11.7	4
1/2"	3		2.9	5.9	4		3.6	8.9	7
3/4"	7		6.0	3.9	9		7.5	5.8	16
1"	14		10.3	2.8	18		12.9	4.3	31
1-1/4"	23		15.7	2.2	29		19.5	3.3	56
1-1/2"	34	5	22.2	1.8	47	11	27.7	2.7	101
2"	79	26	38.6	1.3	117	43	48.2	2.0	261
2-1/2"	173	73	59.5	1.0	247	120	74.4	1.5	470
3"	300	170	84.9	0.8	406	281	106.2	1.3	749
4"	635	567	149.3	0.6	854	833	186.7	0.9	1739
5"	1189	1189	232.7	0.5	1674	1674	290.9	0.7	3338
6"	2087	2087	334.6	0.4	2847	2847	418.2	0.6	6382

2021 National Standard Plumbing Code - Illustrated, New Jersey Edition

H.W. SIZING

C.W. SIZING


DRAINAGE FIXTURE UNITS (D.F.U.)
N.S.P.C. TABLE 11.4.1
LAV. : 1 D.F.U.
W.C. : 4 D.F.U.
SHR. : 2 D.F.U.
UR. : 4 D.F.U.

WATER SUPPLY FIXTURE UNITS (W.S.F.U.)
N.S.P.C. TABLE 10.14.2A
LAV. : 1 W.S.F.U.
W.C. : 5 W.S.F.U.
SHR. : 5 W.S.F.U.
UR. : 4 W.S.F.U.


GAS PIPING DEVELOPED LENGTH = 38'-0"

SIZING BASED ON:
I.F.G.C. TABLE 402.4(4)


TENANT GAS METER GAS PRESSURE SET TO 1 PSI.

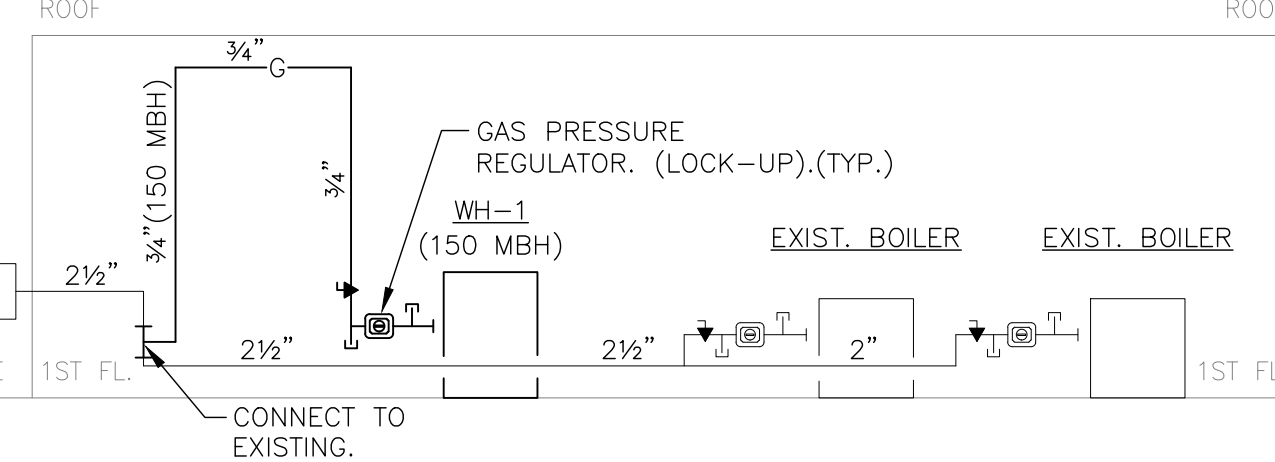


04 GAS RISER DIAGRAM
P1.1 N.T.S.

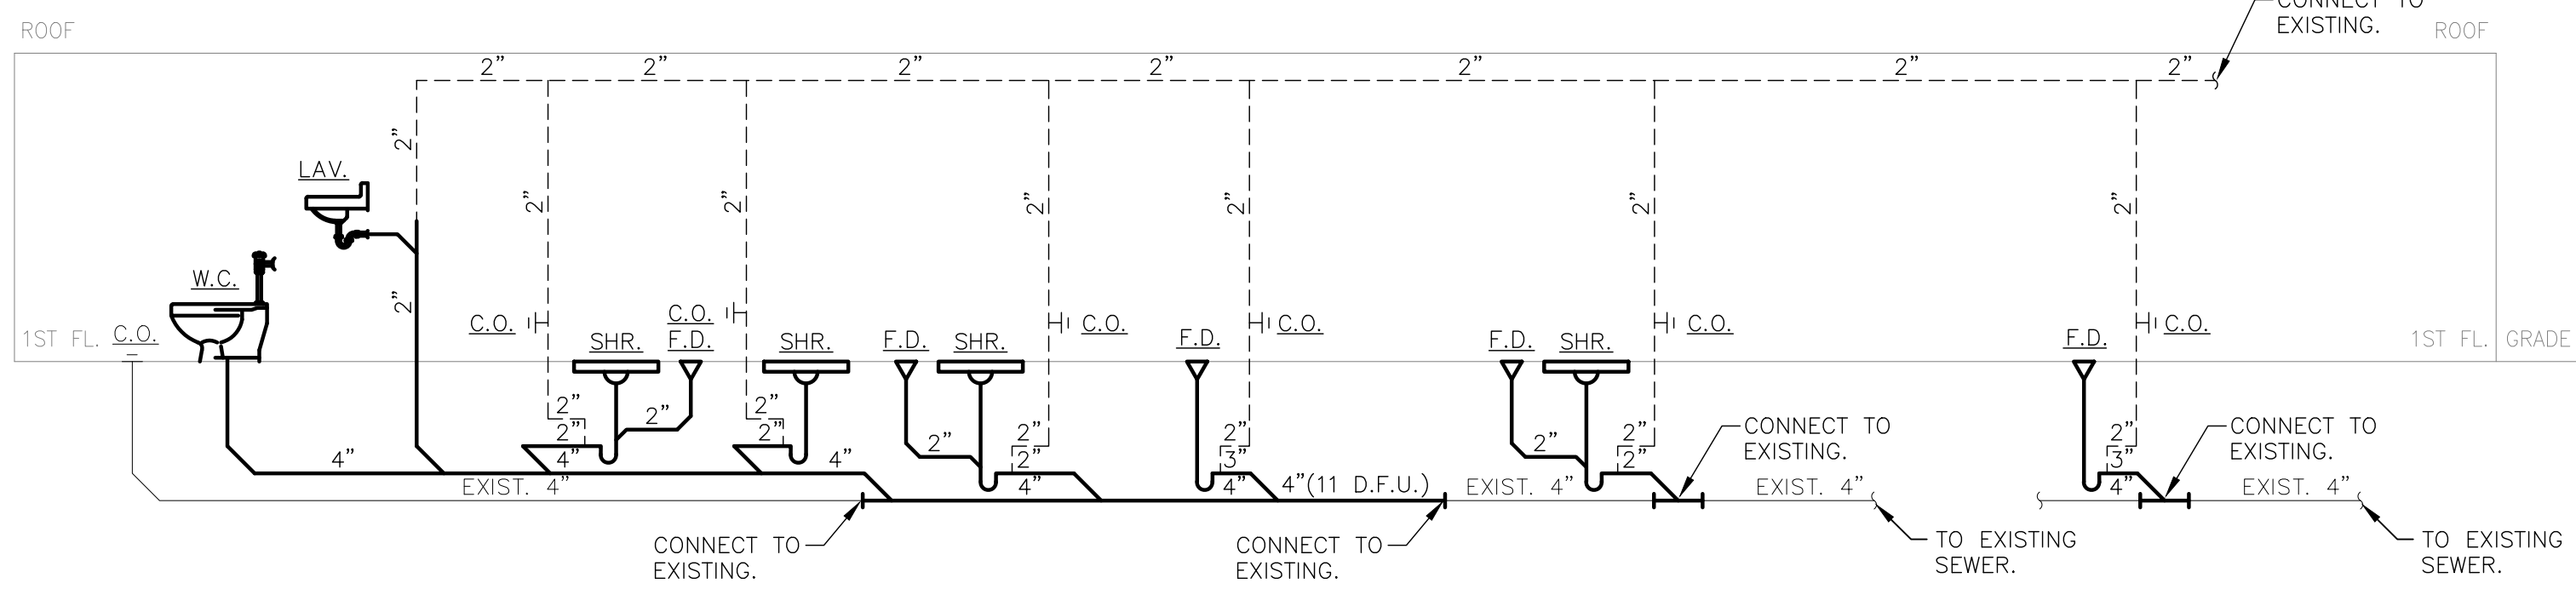

05 SANITARY RISER DIAGRAM
P1.1 N.T.S.

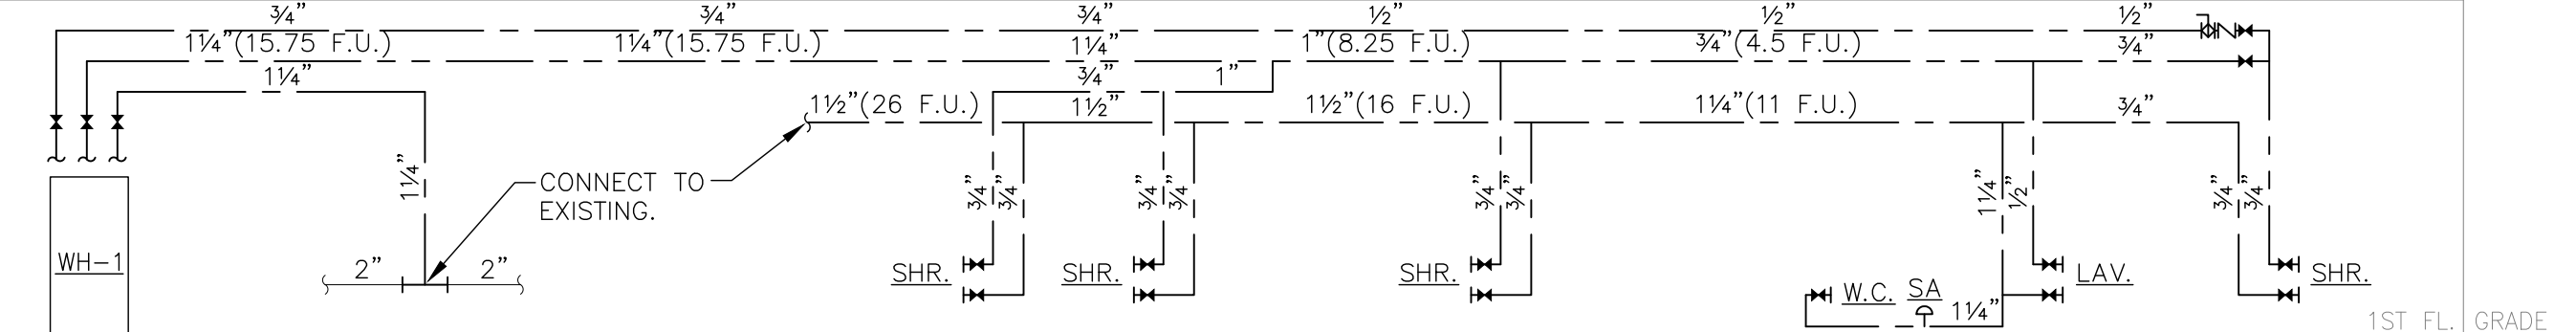

06 WATER RISER DIAGRAM
P1.1 N.T.S.

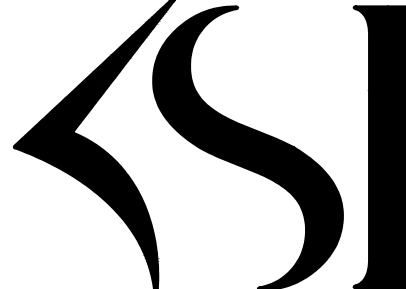

KSI CONSULTING ENGINEERS, LLC
ADDRESS:
P.O. BOX 628 FARMINGDALE, NJ 07727
PHONE:
732.938.2666
FAX:
732.938.2521
CERTIFICATE OF AUTHORIZATION NO.
24GA28124300

PAUL RIBBEL, P.E.
Professional Engineer
State of New Jersey
DATE: 3/31/26
KSI PROJECT #: 25004 27
NEW JERSEY PROFESSIONAL ENGINEER
LICENSE NUMBER: 4315806



1729 ROUTE 35
WALL, NEW JERSEY 07719
phone 732.262.0046
facsimile 732.262.0045
Email info@tm-architects.com

Michael J. Millemann, AIA
NJ LICENSE # A114550
N.Y. LICENSE # 028885

CERTIFICATE OF AUTHORIZATION
No. AC33200

LATRINE ALTERATIONS FOR:
MT HOLLY ARMORY
1670 NJ-38
MT HOLLY, NEW JERSEY 08060
DMA PROJECT NO. MH008

REV: DATE: DESCRIPTION:

PLUMBING
DEMOLITION &
NEW WORK
PART PLANS

PROJECT NO: 2557 DRAWN BY: JAH

DATE ISSUED: 3/30/26

SHEET NO:

P1.1